


Order Plans @ [www.LDILine.com](http://www.LDILine.com)



SITE PLAN PROVIDED FOR GENERAL REFERENCE OF EXISTING CONDITIONS.

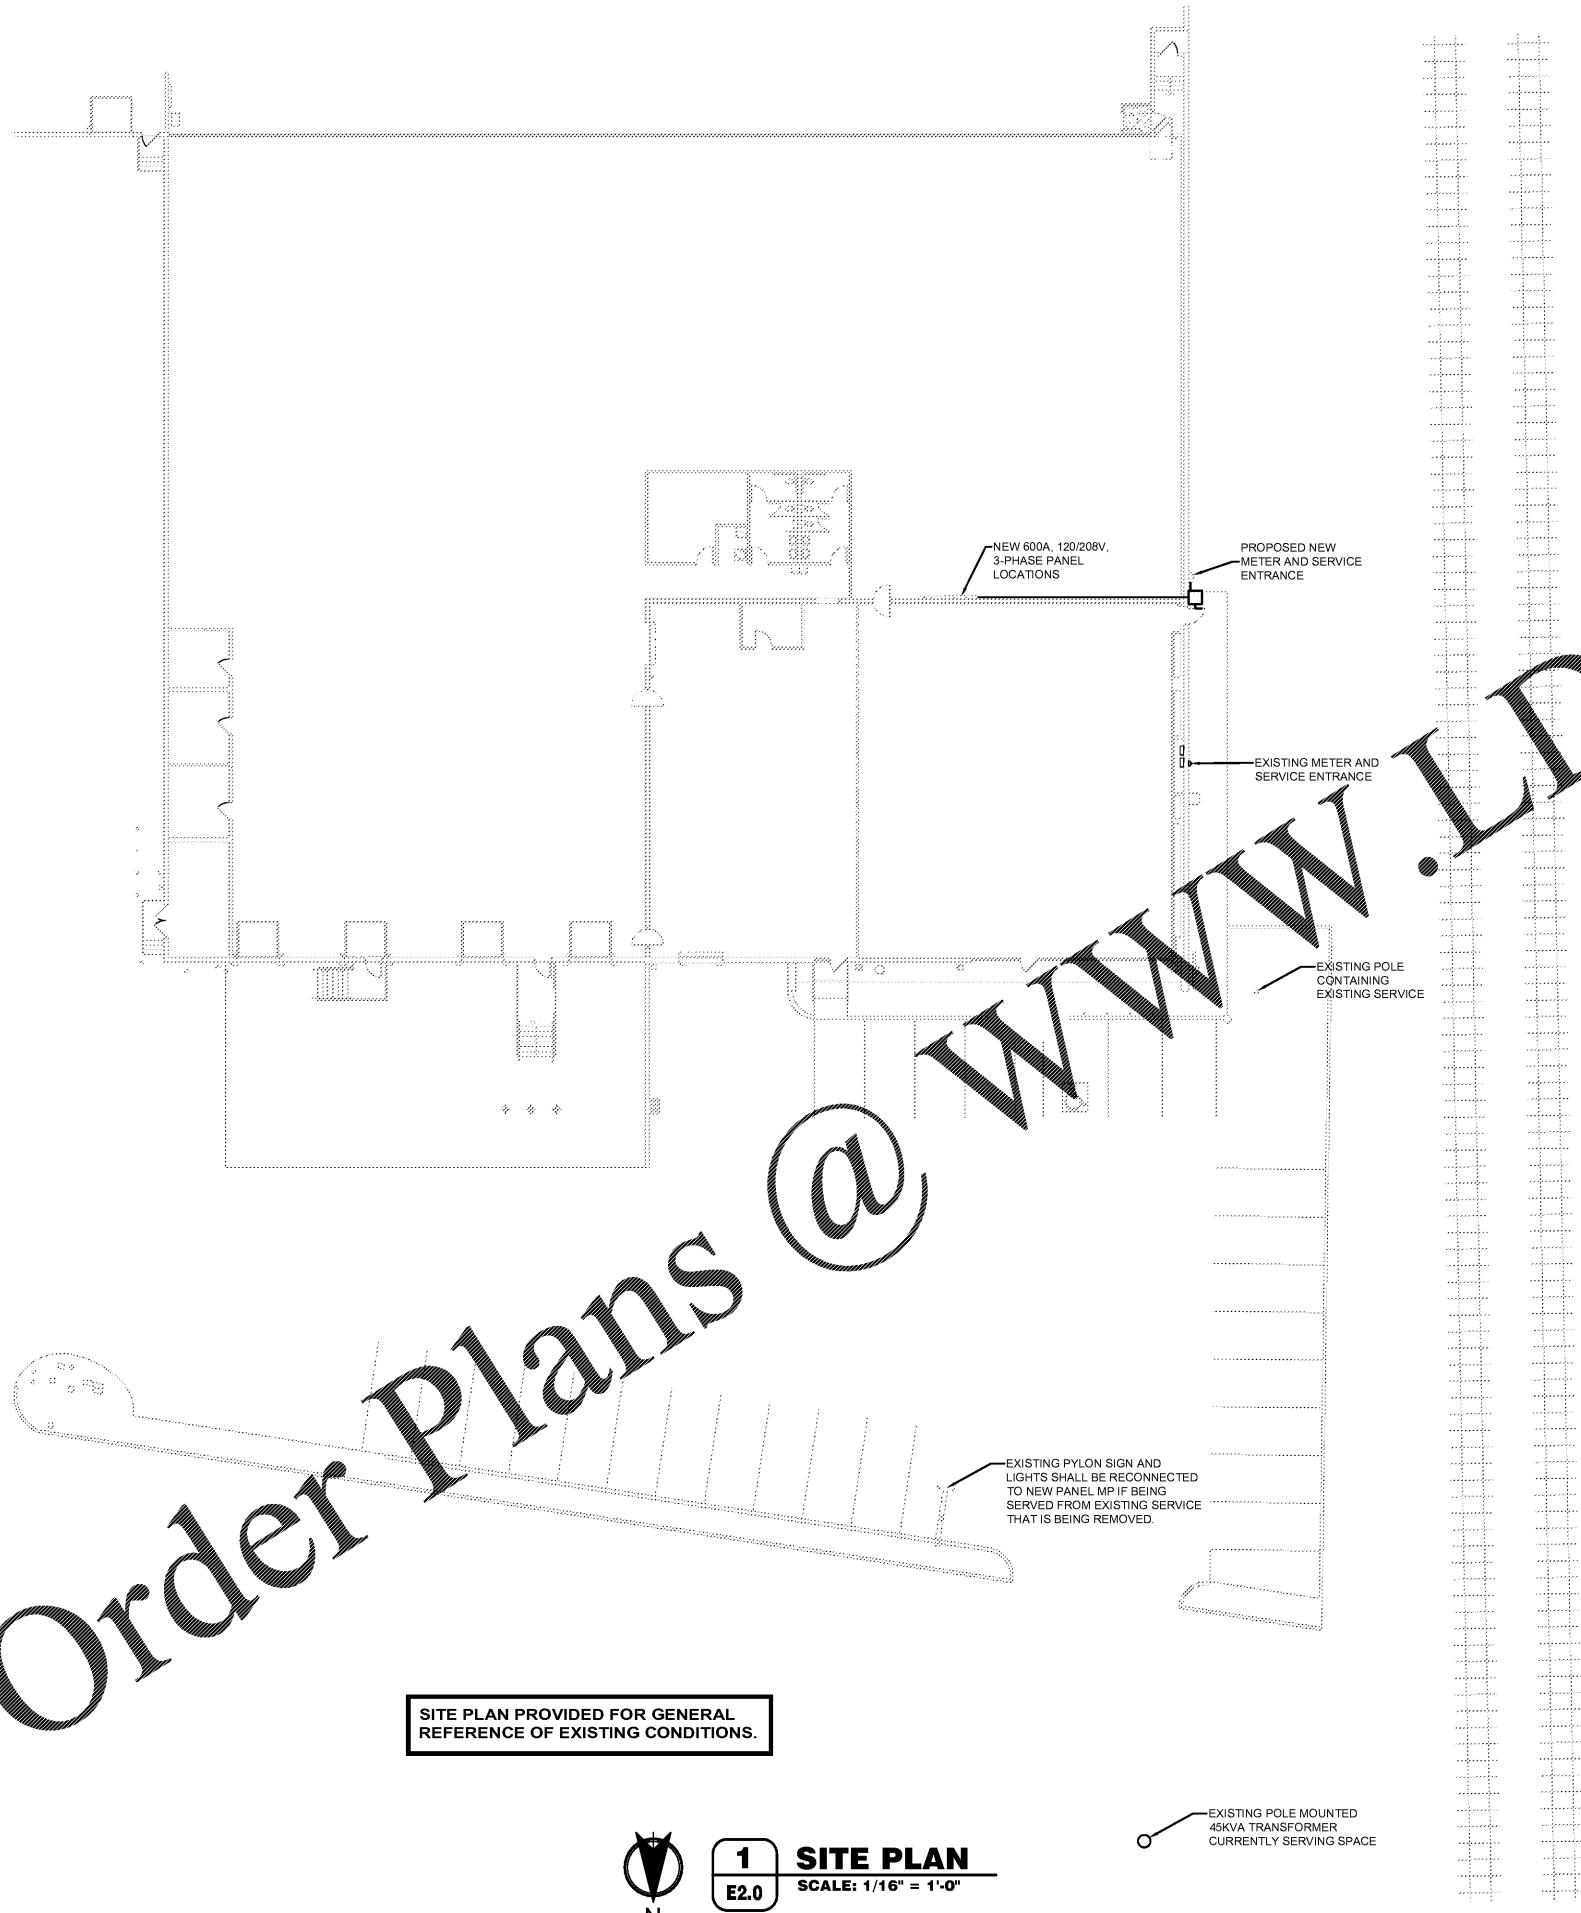

**1** **SITE PLAN**  
E2.0 **SCALE: 1/16" = 1'-0"**

EXISTING POLE MOUNTED 48KVA TRANSFORMER CURRENTLY SERVING SPACE

**CAUTION:**  
INFORMATION ON THIS DRAWING CONCERNING TYPE AND LOCATION OF UNDERGROUND AND OTHER UTILITIES IS NOT GUARANTEED TO BE ACCURATE OR ALL INCLUSIVE. THE CONTRACTOR IS RESPONSIBLE FOR MAKING HIS OWN DETERMINATION AS TO THE TYPE AND LOCATION OF UNDERGROUND AND OTHER UTILITIES AS MAY BE NECESSARY TO AVOID DAMAGE THERETO.



**O'Reilly AUTO PARTS**  
CORPORATE OFFICES: 233 SOUTH PATTERSON  
SPRINGFIELD, MISSOURI 65802, PHONE: 417-862-2674

**CASCO**  
12 Sunnen Drive, Suite 100, St. Louis, MO 63143 T: 314.821.1100  
CASCO DIVERSIFIED CORPORATION  
LIC. #2256 CODE 1325

COPYRIGHT 2018 - DESIGNS, DRAWINGS AND SPECIFICATIONS ARE INSTRUMENTS OF SERVICE AND ARE THE PROPERTY OF CASCO DIVERSIFIED CORPORATION. REPRODUCTION OR TRANSMISSION WITHOUT THE EXPRESSED WRITTEN CONSENT OF THE DESIGN PROFESSIONAL.

PROJECT:  
EXPANSION O'REILLY AUTO PARTS STORE  
493 CRAIGHEAD STREET  
NASHVILLE, TN 37204  
**ELECTRICAL SITE PLAN**

△ REVISIONS		
NO.	DESCRIPTION	DATE

Harry J. Auman  
License #102815  
Exp. Date: 03/31/22  
Professional of Record

DRAWN: BJG  
CHECKED: HJA  
DATE: 04-22-2020  
JOB NO.: 120237 (NV3)  
SHEET:

**E2.0**