



**FOOD LION**  
REMODEL  
STORE #1208  
13490 DUMFRIES RD  
MANASSAS, VA 20112

PROJECT NO: 2019.0917  
DATE: 2-13-20

41 OF 47

**E4.03**

CUST. SERV. WORKRM &  
CHECK OUT COMM. PLAN  
CHECKED: BKJ DRAWN: MM

NOTES:  
• ALL CAT 5 CABLE SHALL BE BELDEN 1212 CMR CAT-5E 4 PAIR 24 AWG(BELDEN 1200 DATATWIST CABLE SERIES)  
• ALL CAT 5 CABLE TO BE INSTALLED IN 3/4" CONDUIT UNLESS NOTED OTHERWISE

TYPE "C" TELEPOLE ON COUNTER.  
PRECUT  
2 1/2" x 2 1/2" HOLES BY KIOSK  
MANUFACTURER. PROVIDE SADDLE FOR  
TELEPOLE INSIDE CABINET. SEE SHEET  
E1.02 FOR TELEPOLE NOTES.

TYPE "DL" TELEPOLE, SEE SHT.  
E1.02

3/4" C WITH PULLSTRING TO MIC IN WORK ROOM

3/4" WITH (1) CAT-5E UNSHIELDED  
ETHERNET CABLES TO TELEPHONE  
OR TELEPHONES,  
WESTERN UNION AND MONEY ORDER

- 3/4" WITH (7) CAT-5E UNSHIELDED ETHERNET CABLES TO PC COMMUNICATION JUNCTION BOX IN  
WORK ROOM FOR:
- REGISTER
  - CATALINA PRINTER
  - TERMINAL
  - WESTERN UNION PRINTER
  - WESTERN UNION TERMINAL
  - ONLINE LOTTERY
  - SPARE


2 CUSTOMER SERVICE KIOSK COMMUNICATIONS PLAN  
E4.03 SCALE: 1/2" = 1'-0"



1 ENLARGED COMMUNICATION WIRING PLAN  
E4.03 SCALE: 3/16" = 1'-0"



*www.DIline.com*

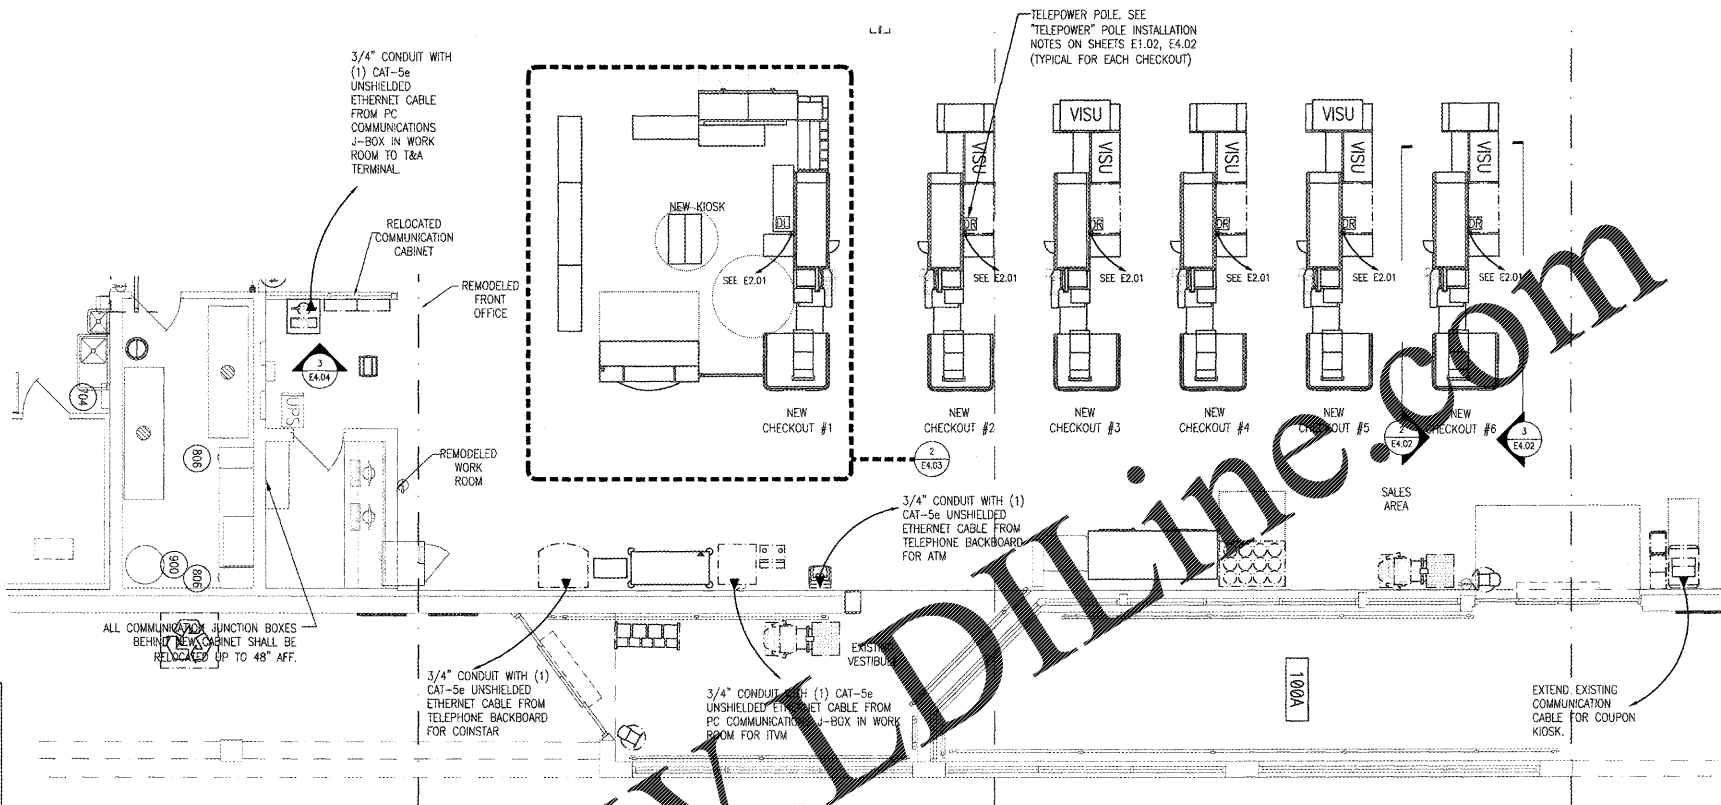

COPYRIGHT © 2020 INTERPLAN, LLC. ALL RIGHTS RESERVED. REPRODUCTION OF THESE DOCUMENTS TO THE ORIGINAL SIZE OR PURPOSE FOR WHICH THEY WERE PREPARED, REPRODUCTIONS, CHANGES OR ASSIGNMENTS ARE PROHIBITED.