

ARCHITECT'S SEAL:

ENGINEER'S SEAL:



REVISIONS
NO. DATE REMARKS

FOOD LION
2118 Executive Dr., Spotsylvania, VA 20145
Telephone: 784.633.2528
foodlion.com
Food Lion is a DELAWARE AMERICA company.

FOOD LION
REMODEL
STORE #1208
13490 DUMFRIES RD
MANASSAS, VA 20112


PROJECT NO: 2019.0917
DATE: 2-13-20

42 OF 47
E4.04


DEPARTMENT MANAGERS
OFFICE POWER & COMM.

CHECKED: BKJ DRAWN: MVI


COPYRIGHT © 2020 INTERPLAN, LLC. RESERVES COPYRIGHT & OTHER RIGHTS RESTRICTING THE REPRODUCTION OR ASSASSINMENT ARE PROHIBITED.

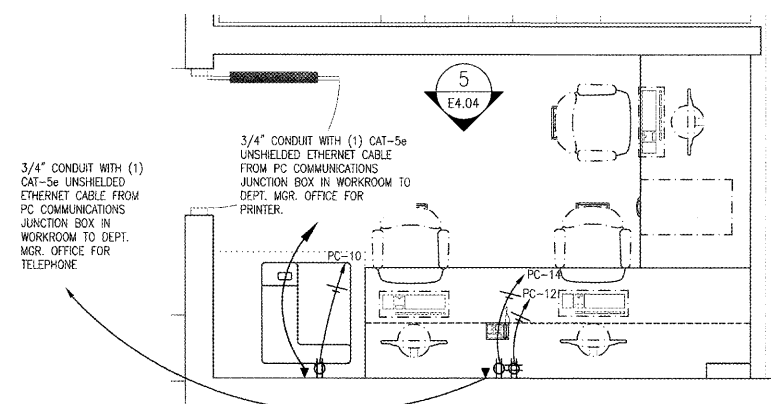

4 ENLARGED ELECTRICAL POWER PLAN - DEPT. MANAGER'S OFFICE
E4.04 SCALE: 1/2" = 1'-0"

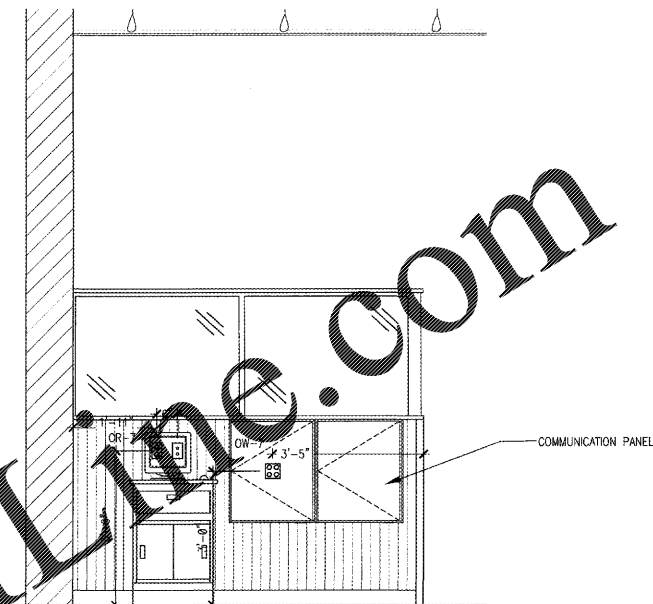

3 OUTSIDE WORKROOM
E4.04 SCALE: 1/2" = 1'-0"

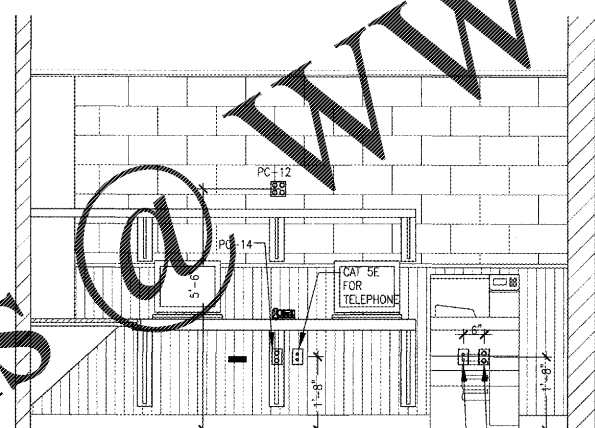

5 DEPT. MANAGER'S OFFICE ELEVATION
E4.04 SCALE: 1/2" = 1'-0"

Order Plans @ WWW.LDILLINE.COM