

Urban Engineers, Inc.
 1904 MONROE DRIVE, N.E., SUITE 150
 ATLANTA, GEORGIA 30324
 PHONE: (404) 873-5874
 www.urbanengineers.net




REVISIONS	
DATE	DESCRIPTION
04/15/2020	1 SUBMITTAL SET

SITE PLAN
 RENEWED MEDICAL
 OLD NATIONAL HIGHWAY
 SOUTH FULTON, GA


PROJECT NO.	21802-4
LAND LOT(S)	132, 133
DISTRICT	13TH
COUNTY	FULTON
SCALE	1" = 30'
DATE	04/09/2020

DRAWING NO.: **C-4.0**

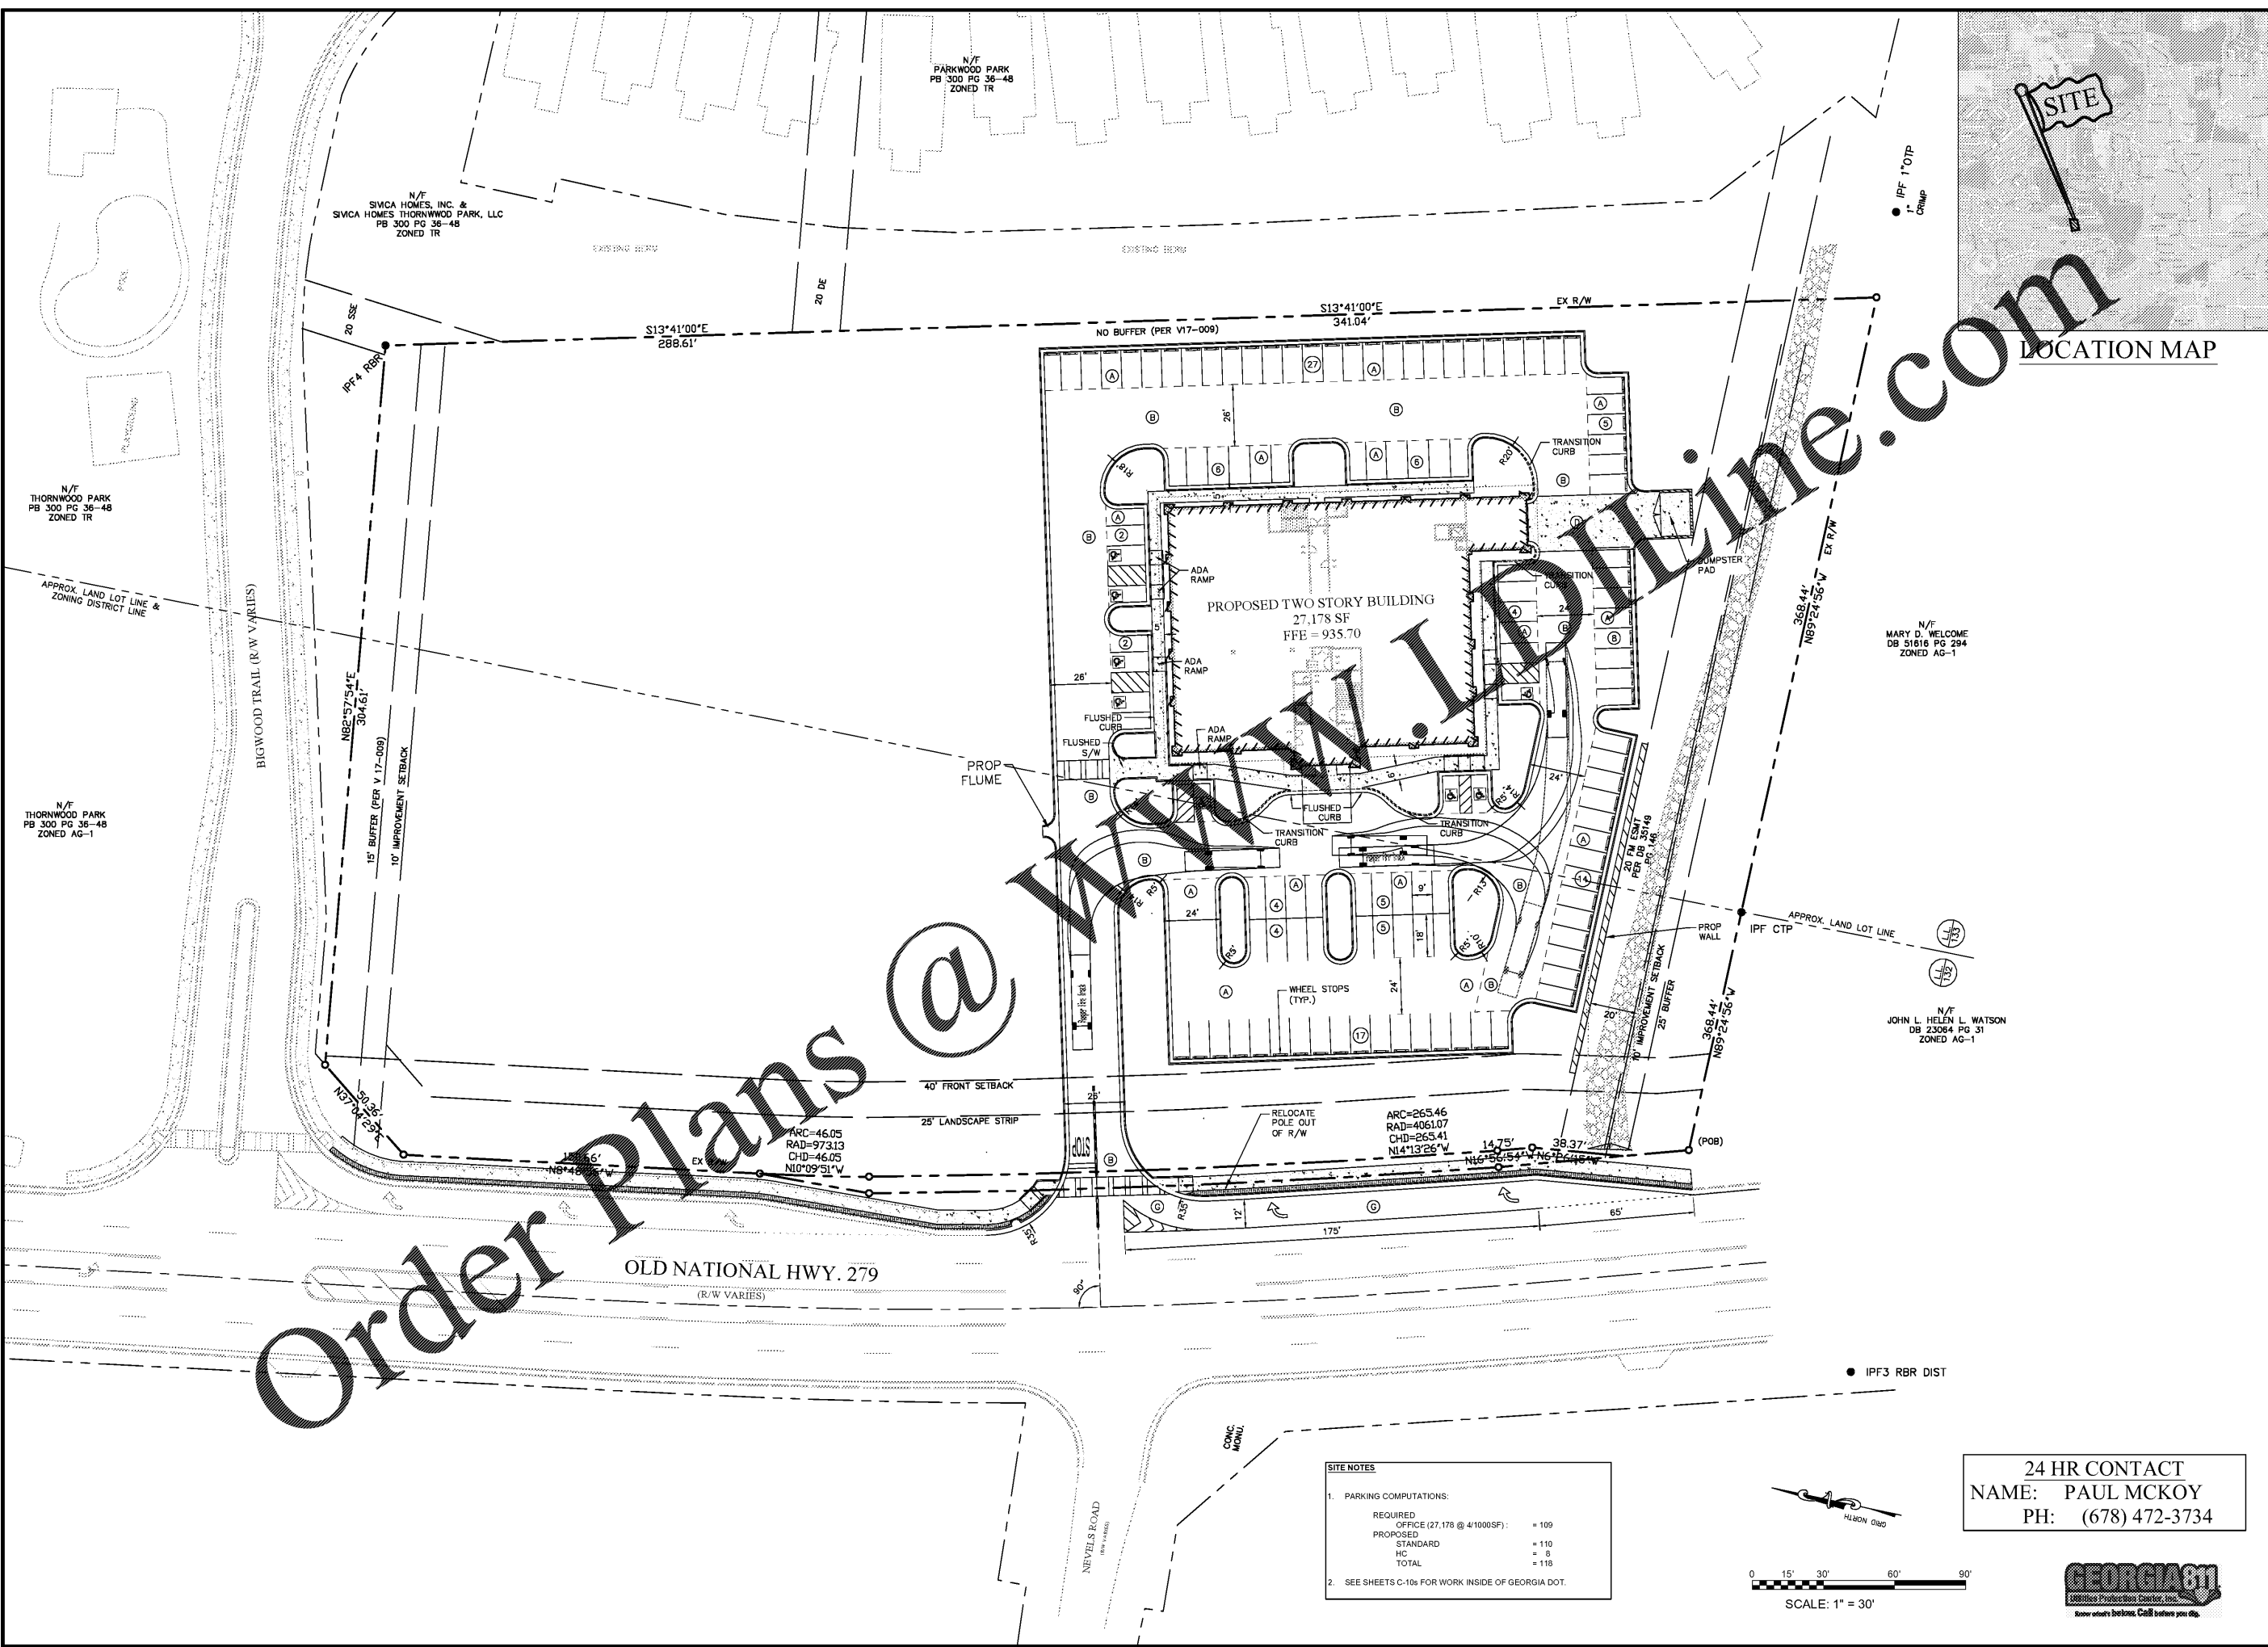

SITE NOTES

- PARKING COMPUTATIONS:
 REQUIRED OFFICE (27,178 @ 4/1000SF): = 109
 PROPOSED STANDARD = 110
 HC = 8
 TOTAL = 118
- SEE SHEETS C-10a FOR WORK INSIDE OF GEORGIA DOT.

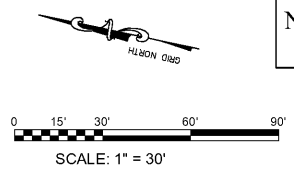

24 HR CONTACT
 NAME: PAUL MCKOY
 PH: (678) 472-3734



V:\URB00\urbaeng\luc-2018\21802-4 - Renewed Medical\21802-4 - Site.dwg
 04/09/2020 1:41 PM

Order Plans @ www.UrbanEngineers.com