



\\urban\projects\16-2018\12180204 - Renewed Medical\12180204 - G&D.dwg
04/09/2020 1:41:18 PM

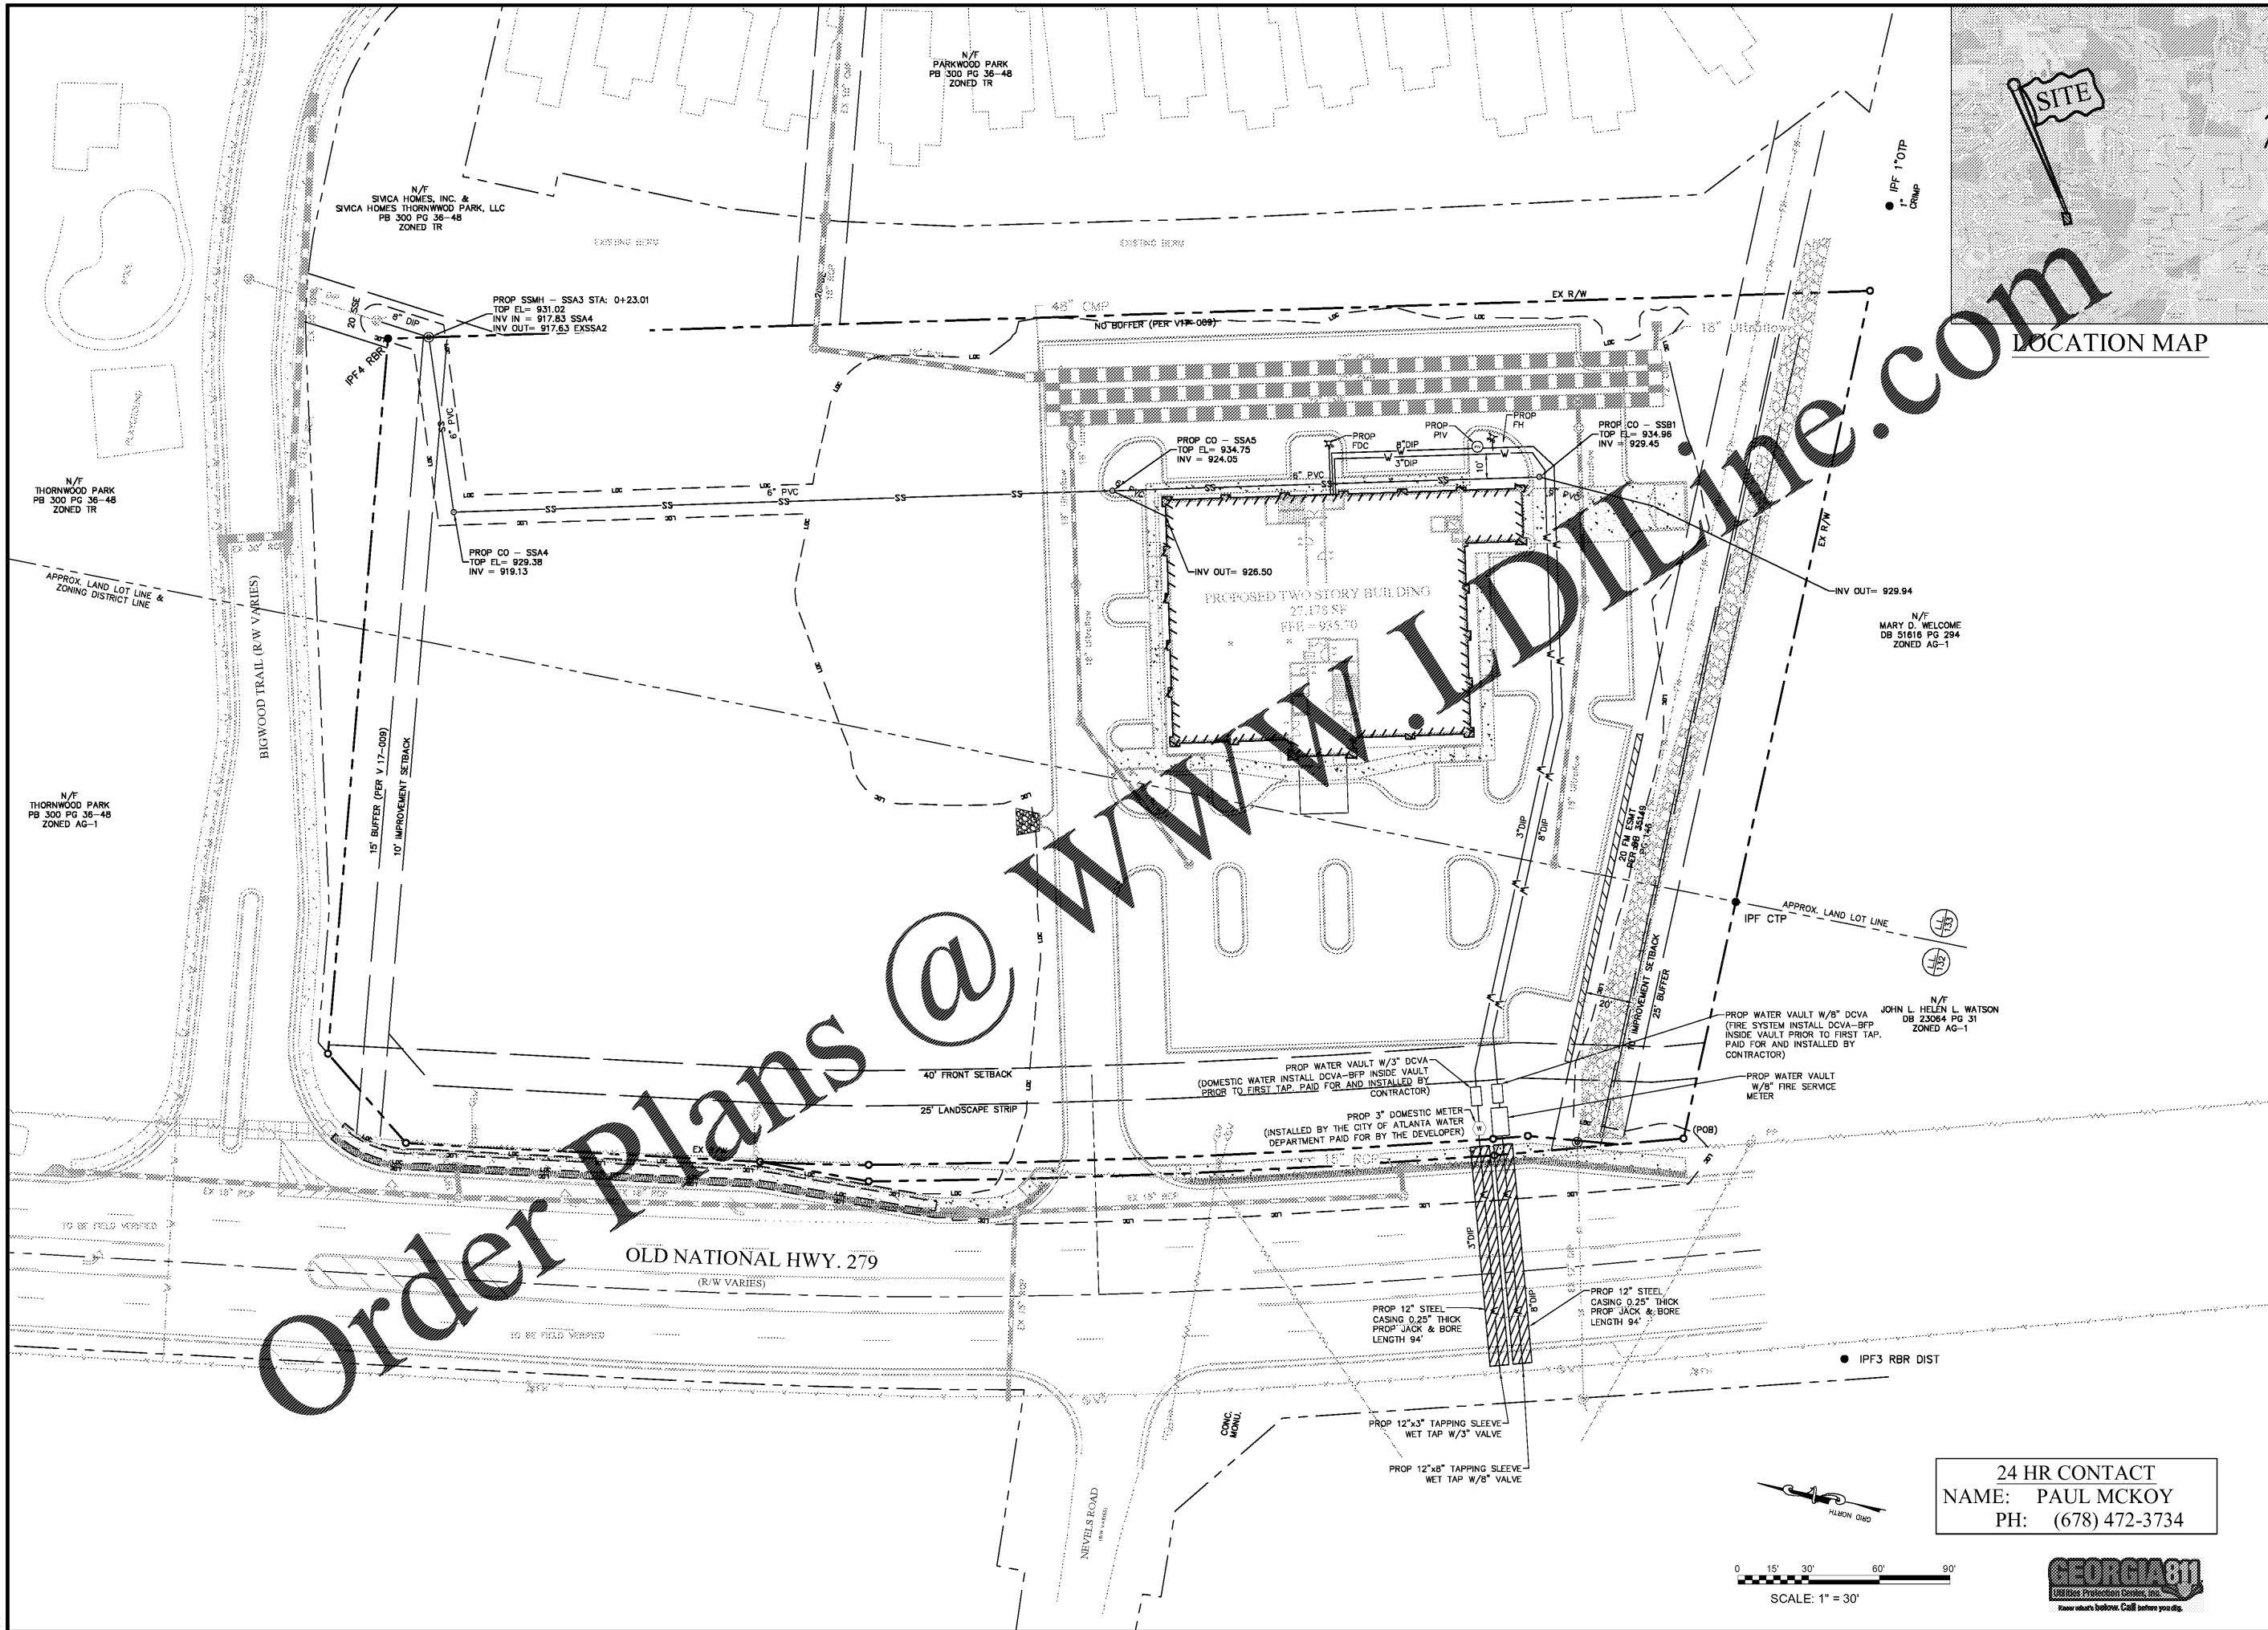


Order Plans @ www.JDilline.com



 LOCATION MAP



24 HR CONTACT
 NAME: PAUL MCKOY
 PH: (678) 472-3734

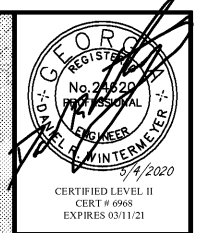

Urban Engineers, Inc.
 1904 MONROE DRIVE, N.E., SUITE 150
 ATLANTA, GEORGIA 30324
 PHONE: (404) 873-5874
 www.urbanengineers.net



REVISIONS	
DATE	DESCRIPTION
04/15/2020	1 SUBMITTAL SET

UTILITY PLAN
 RENEWED MEDICAL
 OLD NATIONAL HIGHWAY
 SOUTH FULTON, GA

PROJECT NO.	21802-4
LAND LOT(S)	132, 133
DISTRICT	13TH
COUNTY	FULTON
SCALE	1" = 30'
DATE	04/09/2020

DRAWING NO.: **C-6.0**