


Order Plans @ www.LDILine.com

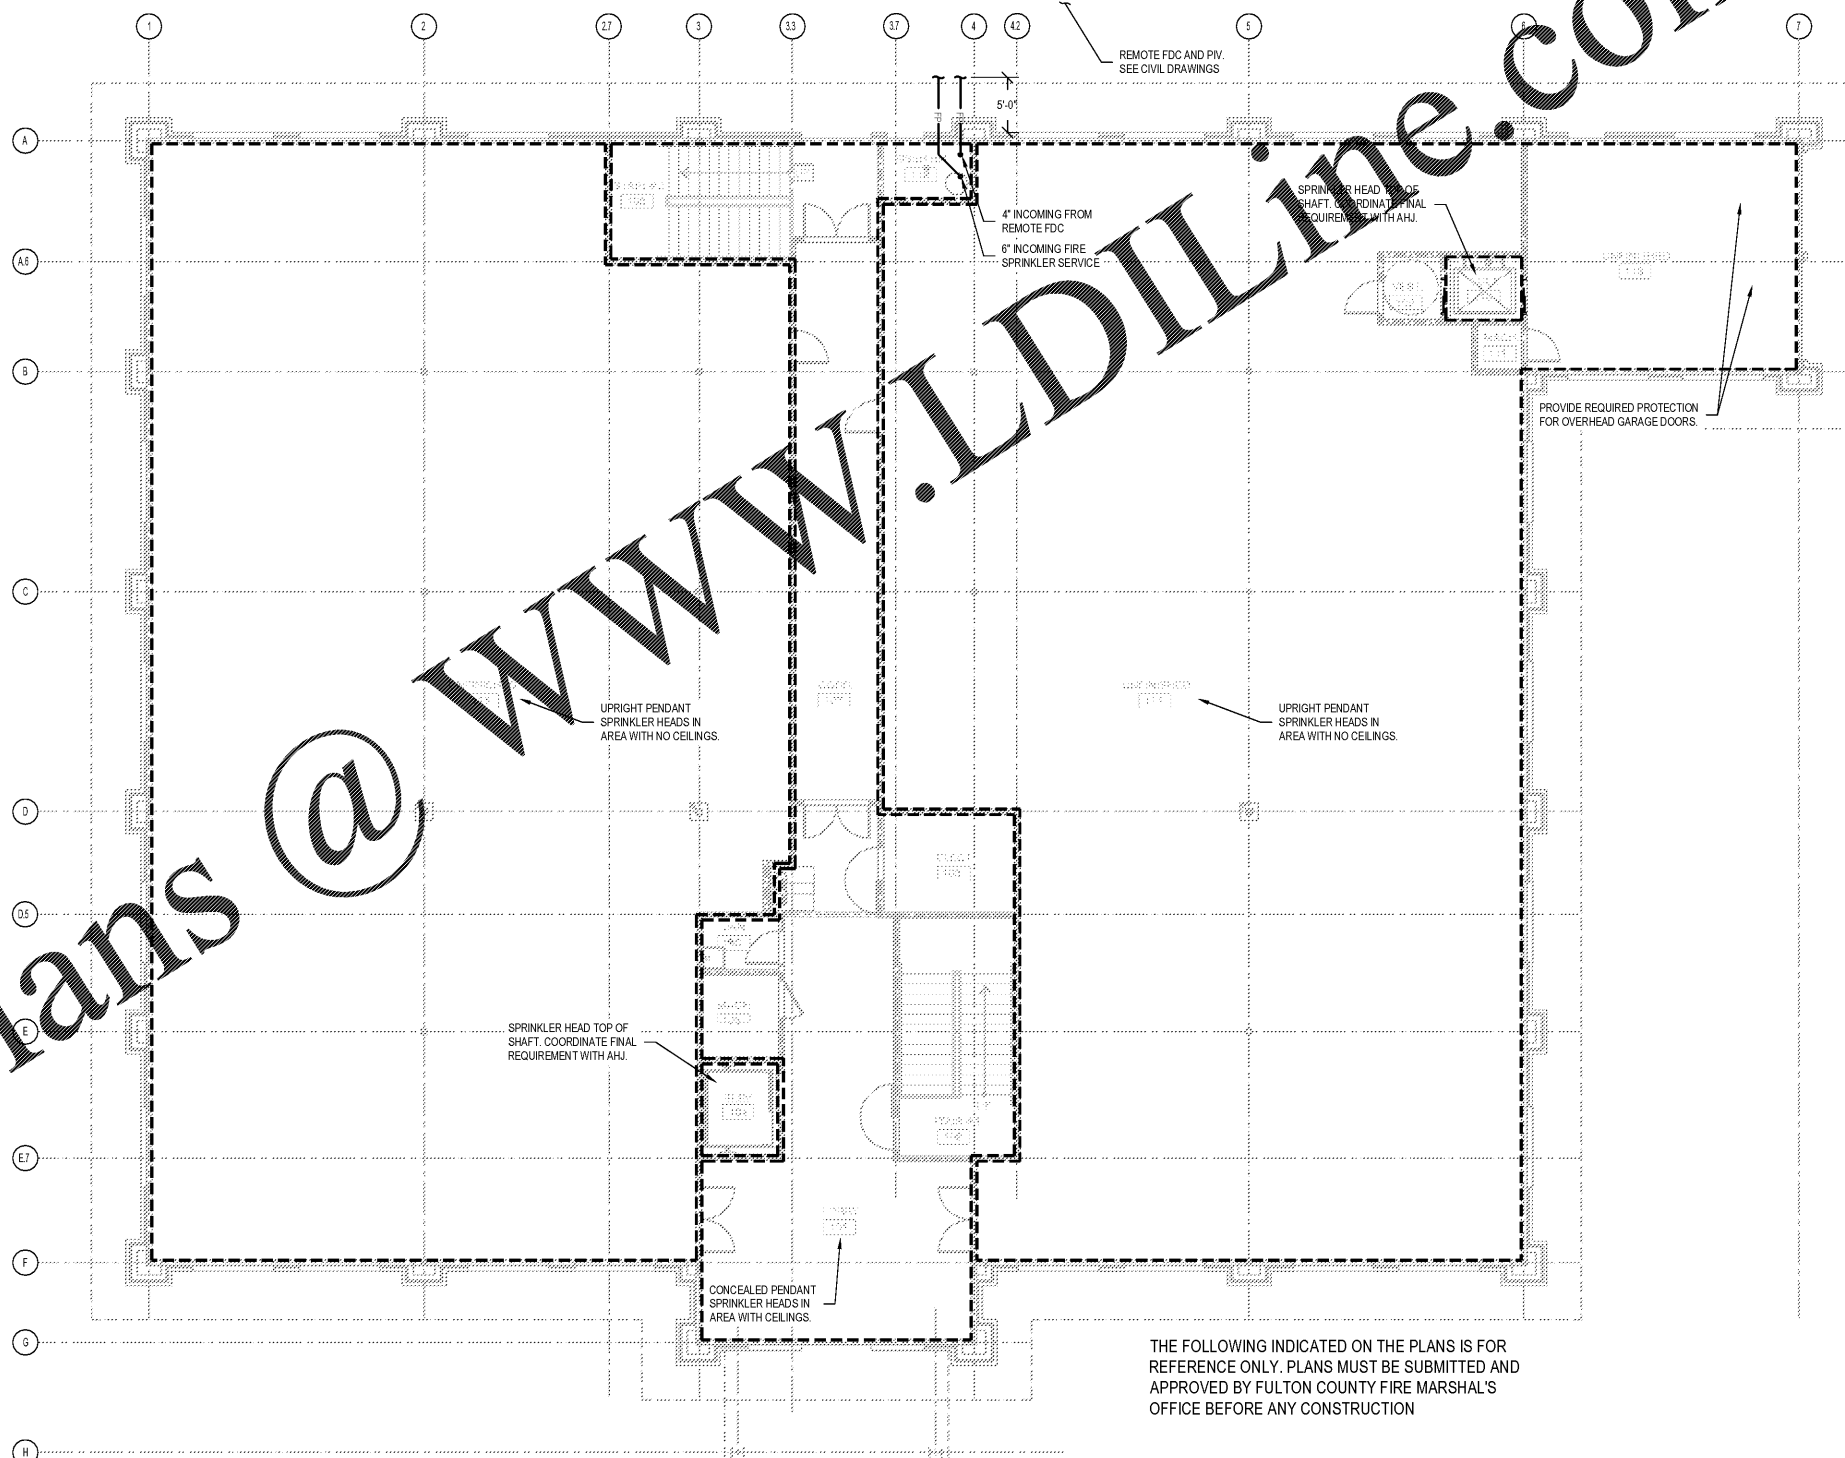

THE FOLLOWING INDICATED ON THE PLANS IS FOR REFERENCE ONLY. PLANS MUST BE SUBMITTED AND APPROVED BY FULTON COUNTY FIRE MARSHAL'S OFFICE BEFORE ANY CONSTRUCTION

1 FIRE SPRINKLER PLAN - FIRST FLOOR
SCALE: 1/8"=1'-0"



JEFFERSON BROWNE GRESHAM ARCHITECTS
180 MADISON ROAD, SUITE 1000
FACREE CITY, GEORGIA 30809
770-638-9948
JEFFERSONBROWNEARCHITECTS.COM

REVISIONS	
NO.	DESCRIPTION

RENEWED MEDICAL BUILDING
CORE & SHELL ONLY

SOUTH FULTON, GEORGIA
PROJECT #19-2983

03/27/2020



BRIAN J. FAGAN - PROFESSIONAL ENGINEER
GA LICENSE NUM: 32550 - EXP: 12/31/2020
SEAL

MARCH 27, 2020

PERMIT SET

RELEASE DATE

Fire Sprinkler Plan
First Floor

DRAWING TITLE

© COPYRIGHT 2020 JEFFERSON BROWNE GRESHAM ARCHITECTS, INC. THIS DOCUMENT AS AN INSTRUMENT OF SERVICE REMAINS THE PROPERTY OF JEFFERSON BROWNE GRESHAM ARCHITECTS AND NO PART THEREOF MAY BE REPRODUCED IN ANY FORM WITHOUT WRITTEN PERMISSION FROM JEFFERSON BROWNE GRESHAM ARCHITECTS.

FES PROJECT: 20007



Drawn By: CH, J2
Checked By: BF
PROJECT # 19-9883
SHEET 3 of 3

FP100