


Order Plans @ www.LDILine.com

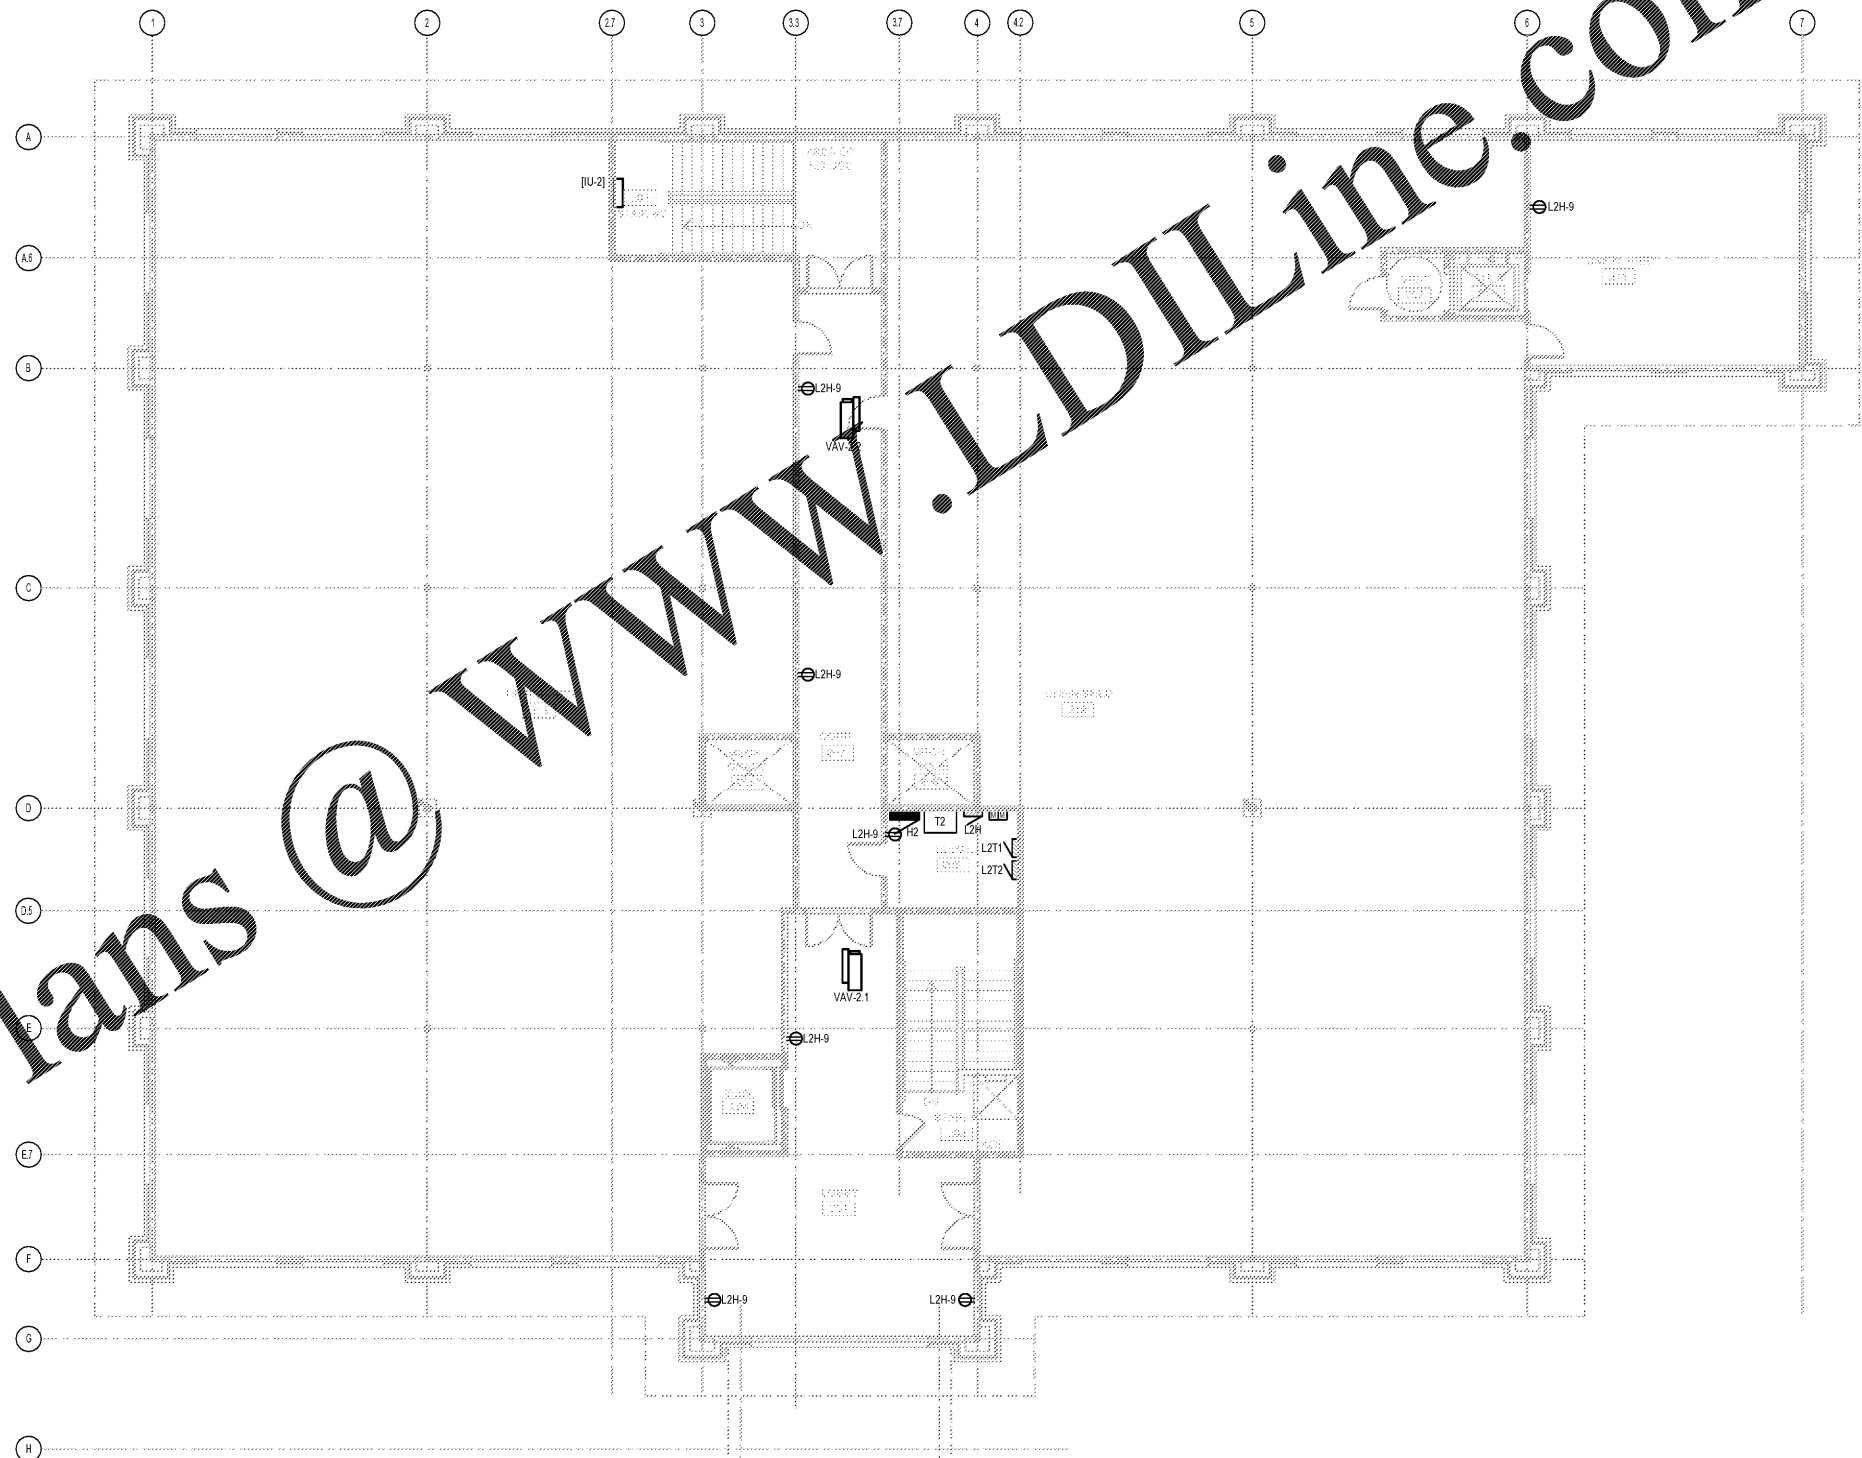

1 ELECTRICAL POWER PLAN - SECOND FLOOR
SCALE: 1/8"=1'-0"



JEFFERSON BROWNE GRESHAM ARCHITECTS
180 HUNTERTON ROAD, SUITE 1000
FACELLE CITY, GEORGIA 30209
770-638-9548
JEFFERSONBROWNEARCHITECTS.COM

REVISIONS	
NO.	DESCRIPTION

RENEWED MEDICAL BUILDING
CORE & SHELL ONLY

SOUTH FULTON, GEORGIA
PROJECT #19-2983



BRIAN J. FAGAN - PROFESSIONAL ENGINEER
GA LICENSE NUM: 32550 - EXP: 12/31/2020

MARCH 27, 2020
PERMIT SET
RELEASE DATE

Power Plan
Second Floor

© COPYRIGHT 2020 JEFFERSON BROWNE GRESHAM ARCHITECTS, INC. THIS DOCUMENT IS AN INSTRUMENT OF SERVICE AND REMAINS THE PROPERTY OF JEFFERSON BROWNE GRESHAM ARCHITECTS AND NO PART THEREOF MAY BE REPRODUCED IN ANY FORM WITHOUT WRITTEN PERMISSION FROM JEFFERSON BROWNE GRESHAM ARCHITECTS.



Drawn By: CH JS
Checked By: BF
PROJECT # 19-2983
SHEET 3 of 3

E101