

REVISIONS

NO.	DESCRIPTION

RENEWED MEDICAL BUILDING  
CORE & SHELL ONLY

SOUTH FULTON, GEORGIA  
PROJECT #19-2983

03/27/2020



BRIAN J. FAGAN - PROFESSIONAL ENGINEER  
GA LICENSE NUM: 32550 - EXP: 12/31/2020

MARCH 27, 2020

PERMIT SET

RELEASE DATE

Lighting Plan  
First Floor

DRAWING TITLE


© COPYRIGHT 2020 JEFFERSON BROWNE GRESHAM ARCHITECTS, INC. THIS DOCUMENT IS AN INSTRUMENT OF SERVICE AND REMAINS THE PROPERTY OF JEFFERSON BROWNE GRESHAM ARCHITECTS AND NO PART THEREOF MAY BE REPRODUCED IN ANY FORM WITHOUT WRITTEN PERMISSION FROM JEFFERSON BROWNE GRESHAM ARCHITECTS.

FES PROJECT: 20007

FES Engineering Services, LLC  
M.E.P. ENGINEERING  
327 DAHLONEGA ST. STE 1018  
CUMMING, GA 30040  
(678) 648-4884

Drawn By: CH, #2  
Checked By: BF  
PROJECT # 19-9883  
SHEET 3 of 3

E200

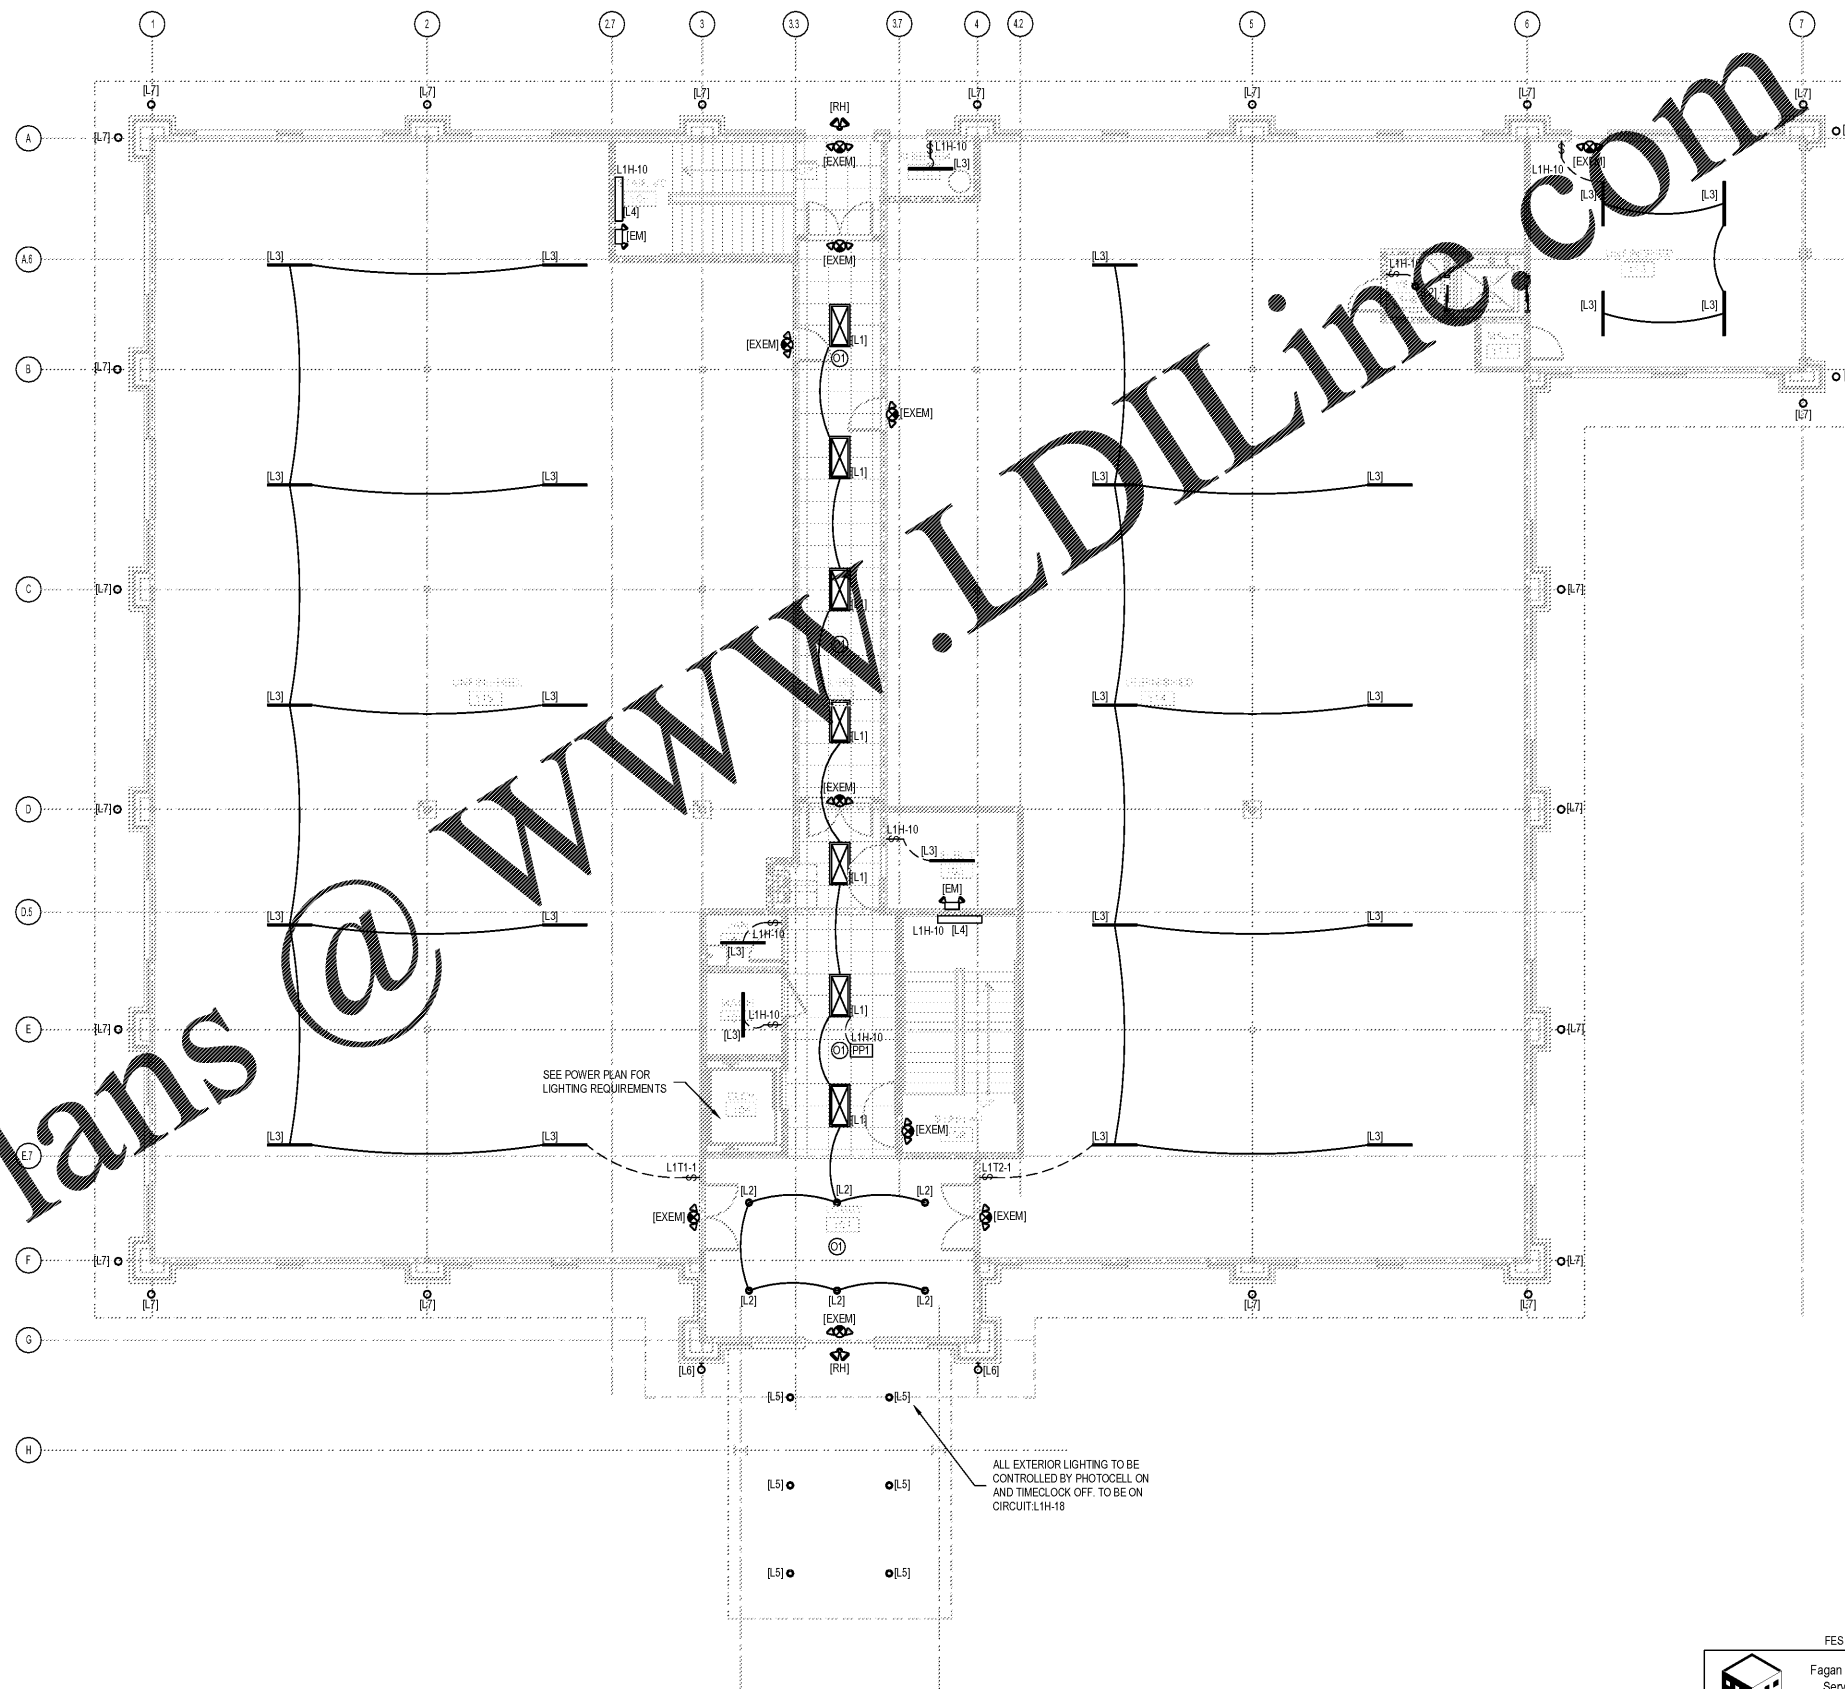

LIGHTING CONTROL SCHEDULE		
SYMBOL	DESCRIPTION	BASIS OF DESIGN: ACUITY CONTROLS
⓪	LOW VOLTAGE SMALL AREA OCCUPANCY SENSOR	CM PDT 9
Ⓟ	DUAL VOLTAGE POWER PACK W/ RELAY CONTACT PROTECTION	PP20

NOTE: COORDINATE SWITCH COLOR WITH ARCHITECT BEFORE ORDERING

**1** ELECTRICAL LIGHTING PLAN - FIRST FLOOR  
SCALE: 1/8"=1'-0"

Order Plans @ [www.LDILine.com](http://www.LDILine.com)