


Order Plans @ WWW.LDILine.com

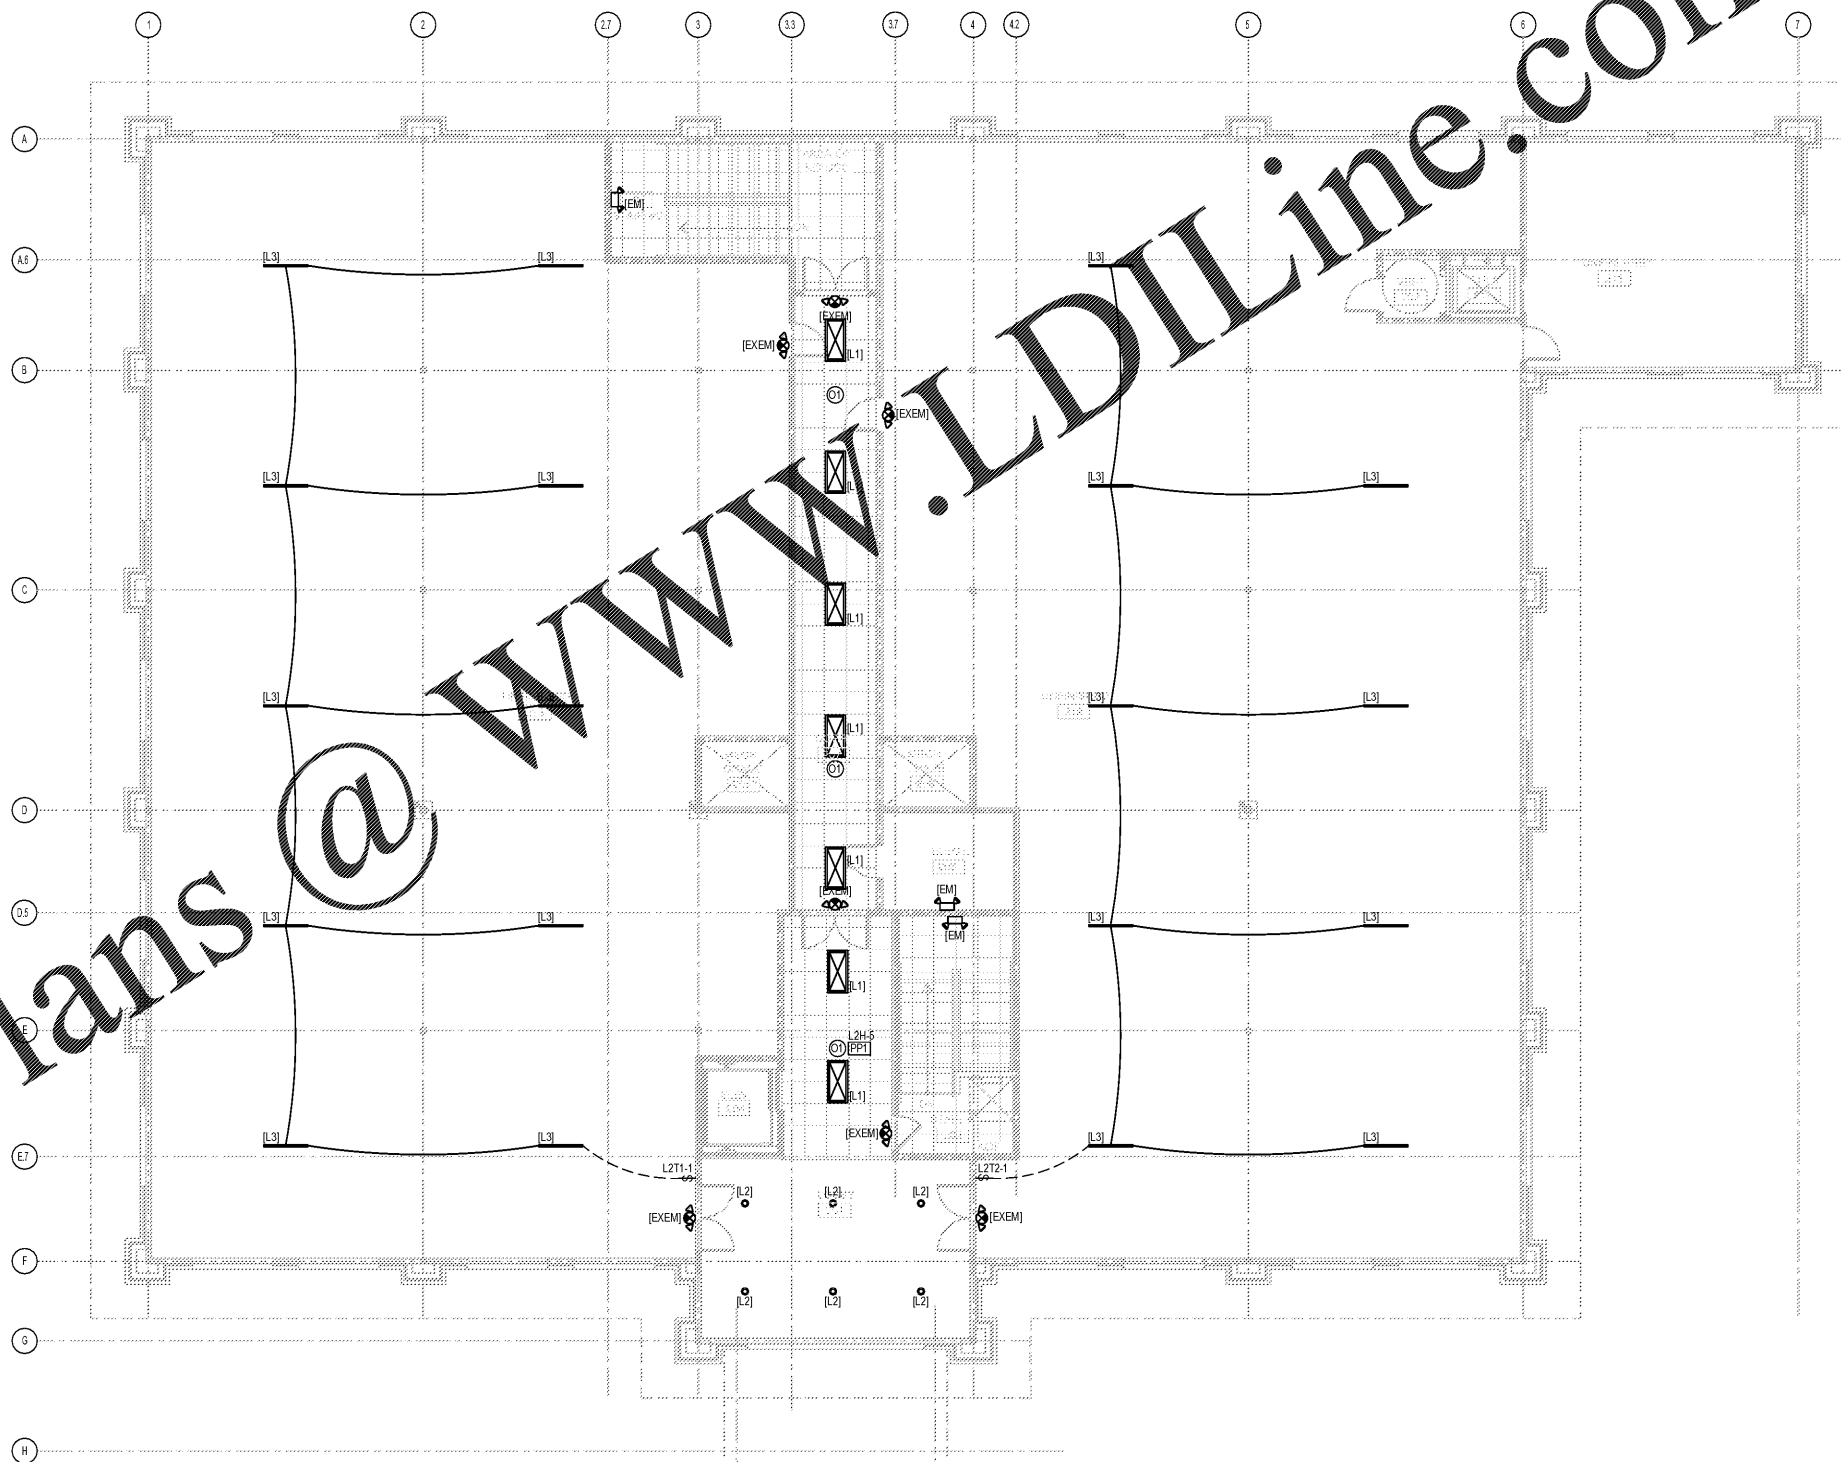

1 ELECTRICAL LIGHTING PLAN - SECOND FLOOR
SCALE: 1/8"=1'-0"



JEFFERSON BROWNE GRESHAM ARCHITECTS
180 MADISON ROAD, SUITE 1000
FACILEE CITY, GEORGIA 30809
770-638-9548
JEFFERSONBROWNEARCHITECTS.COM

REVISIONS

NO.	DESCRIPTION

RENEWED MEDICAL BUILDING
CORE & SHELL ONLY

SOUTH FULTON, GEORGIA
PROJECT #19-2883

03/27/2020



BRIAN J. FAGAN - PROFESSIONAL ENGINEER
GA LICENSE NUM: 32550 - EXP: 12/31/2020

MARCH 27, 2020

PERMIT SET

RELEASE DATE

Lighting Plan
Second Floor

DRAWING TITLE

© COPYRIGHT 2020 JEFFERSON BROWNE GRESHAM ARCHITECTS, INC. THIS DOCUMENT IS AN INSTRUMENT OF SERVICE AND REMAINS THE PROPERTY OF JEFFERSON BROWNE GRESHAM ARCHITECTS AND NO PART THEREOF MAY BE REPRODUCED IN ANY FORM WITHOUT WRITTEN PERMISSION FROM JEFFERSON BROWNE GRESHAM ARCHITECTS.

FES PROJECT: 20007

FES Fagan Engineering Services, LLC
M.E.P. ENGINEERING
327 DAHLONEGA ST. STE 101B
CUMMING, GA 30040
(678) 648-4804

Drawn By:

CH, ES

Checked By:

BF

PROJECT #

19-9883

E201

SHEET 3 of 3