



**DEKALB PEACHTREE  
AIRPORT**  
DEKALB COUNTY, GEORGIA

**Michael Baker  
INTERNATIONAL**

Designer:  
**W. MCNAMARA**  
Technician:  
**G. SUMMERS**  
Checked by:  
**D. SKURKY**  
Project Number:  
**174297**



GSWCC LEVEL II DESIGN PROF.  
#0000072532 EXP. 10/21/2022

**AULICK ENGINEERING LLC**  
HYDRAULICS & HYDROLOGY | EROSION CONTROL  
AIRFIELD DESIGN | CONSTRUCTION MANAGEMENT


Notes:

REVISIONS			
No.	Description	Date	By

Project Name:  
**RUNWAY INCURSION  
MITIGATION IMPROVEMENTS  
(PDK 11)**

Drawing Name:  
**DRAINAGE  
DETAILS  
NO. 7**

ITB# 20-101257  
Date: **FEBRUARY, 2020** Sheet Number: **37** of **72**  
Scale: **N/A** Drawing Number: **DD-7**

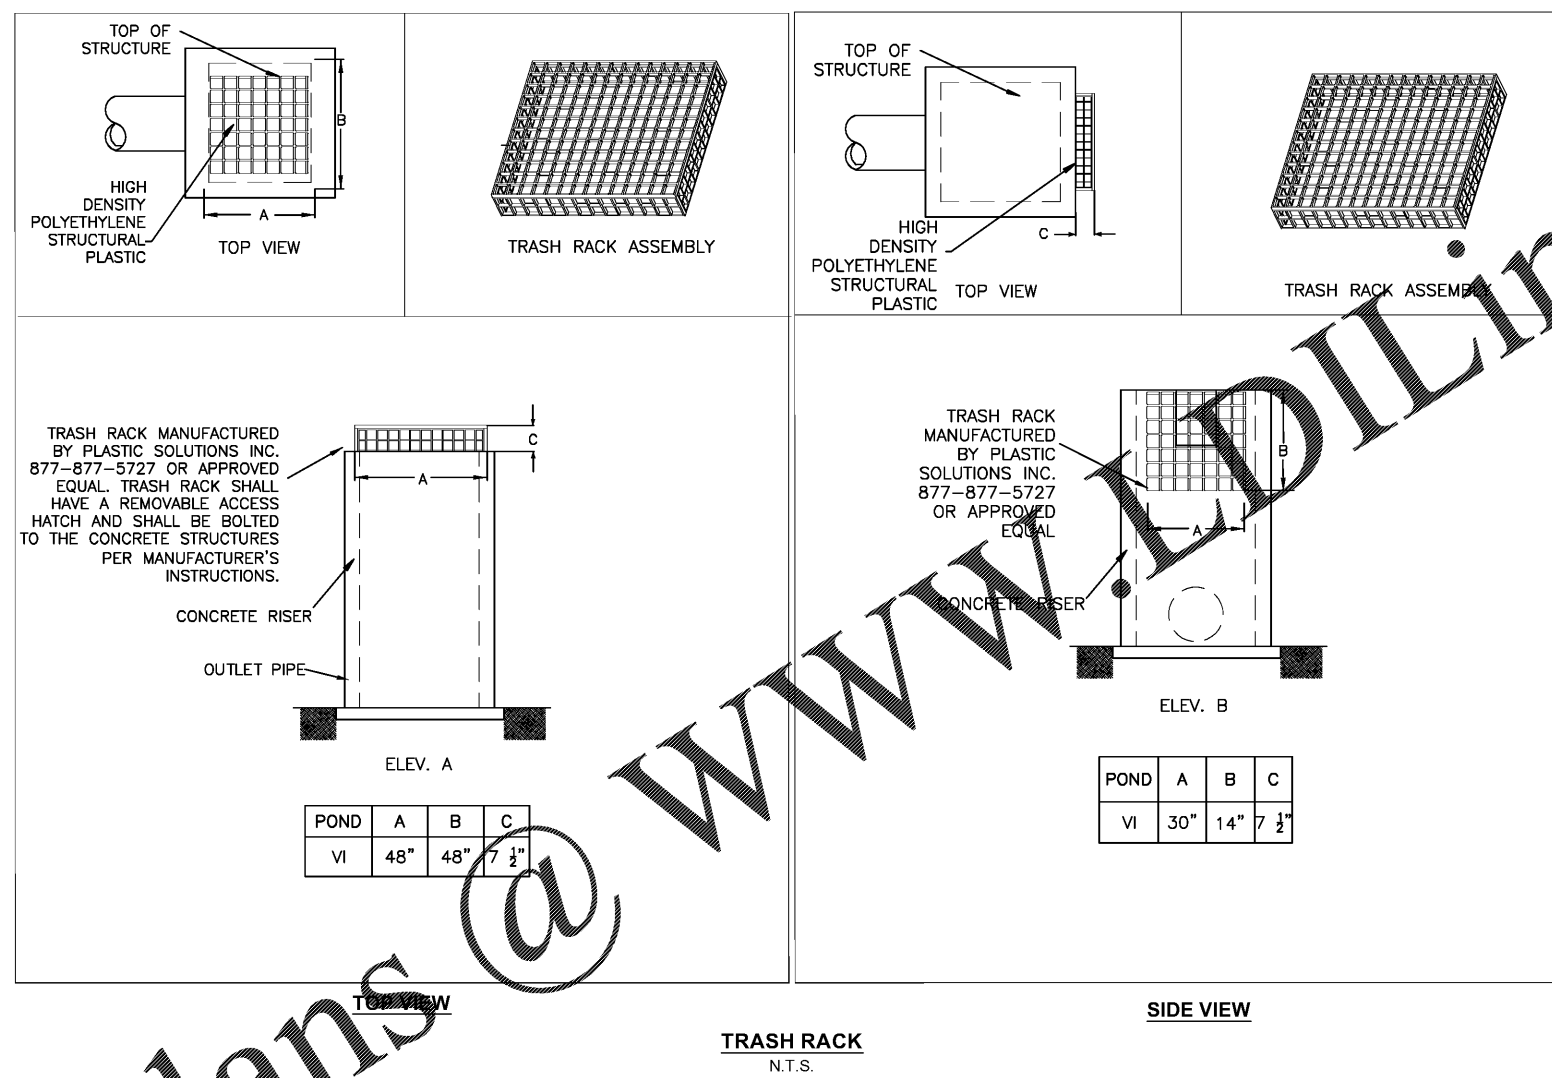

Order Plans @ WWW.DILine.com