

CITY OF CHAMBLEE NOTES

1. ALL STORMWATER DRAINAGE SYSTEMS HAVE BEEN CHECKED FOR PERFORMANCE DURING THE 100-YEAR STORM (DEVELOPED CONDITION) TO EVALUATE LOCAL FLOODING AND POSSIBLE FLOOD HAZARDS TO ADJACENT PROPERTY. THE 100-YEAR STORM IS SAFELY CONVEYED WITH NO ANTICIPATED ADVERSE IMPACTS ON-SITE OR DOWNSTREAM OF THE PROJECT.
2. THERE ARE NO WETLANDS LOCATED ON THIS PROJECT SITE.
3. ACCEPTANCE OF THESE PLANS DOES NOT CONSTITUTE APPROVAL BY THE CITY OF CHAMBLEE OF ANY LAND DISTURBING ACTIVITIES WITHIN WETLAND AREAS. IT IS THE OWNER'S RESPONSIBILITY TO CONTACT THE APPROPRIATE REGULATORY AGENCY FOR APPROVAL OF ANY WETLAND DISTURBANCE AREA.

POND MAINTENANCE NOTES

1. SEDIMENT EXCAVATED FROM STORMWATER PONDS THAT DO NOT RECEIVE RUNOFF FROM DESIGNATED HOTSPOTS ARE NOT CONSIDERED TOXIC OR HAZARDOUS MATERIAL AND CAN BE SAFELY DISPOSED OF BY EITHER LAND APPLICATION OR LANDFILLING. SEDIMENT TESTING MAY BE REQUIRED PRIOR TO SEDIMENT DISPOSAL WHEN A HOTSPOT LAND USE IS PRESENT.
2. CARE SHOULD BE EXERCISED DURING POND DRAWDOWNS TO PREVENT DOWNSTREAM DISCHARGE OF SEDIMENTS, ANOXIC WATER, OR HIGH FLOWS WITH EROSION VELOCITIES.
3. POND VEGETATION TO BE MAINTAINED AS OTHER INFIELD GRASS AREAS (SHORT LAWN CUT).
4. OUTLET CONTROL STRUCTURE TO BE MONITORED TO ENSURE NO CLOGGING TO AVOID STANDING WATER.

LEGEND

	PROPOSED ASPHALT PAVEMENT		EXISTING PIPE
	EXISTING DRAINAGE STRUCTURES		PROPOSED PIPE
			EXISTING CONTOUR
			PROPOSED CONTOUR



Michael Baker INTERNATIONAL

Designer: **G. SUMMERS**
 Technician: **W. MCNAMARA**
 Checked by: **D. SKURKY**
 Project Number: **174297**

GSWCC LEVEL II DESIGN PROF.
#0000072532 EXP. 10/21/2022

AULICK ENGINEERING LLC
 HYDRAULICS & HYDROLOGY | EROSION CONTROL
 AIRFIELD DESIGN | CONSTRUCTION MANAGEMENT

Notes:

40' 0' 40' 80'
1" = 40'


REVISIONS

No.	Description	Date	By

Project Name:
RUNWAY INCURSION MITIGATION IMPROVEMENTS (PDK 11)

Drawing Name:
STORMWATER MANAGEMENT FACILITIES PLAN - POND VI

ITB# 20-101257
 Date: **FEBRUARY, 2020** Sheet Number: **38** of **72**
 Scale: **1" = 40'** Drawing Number: **SMF-1**

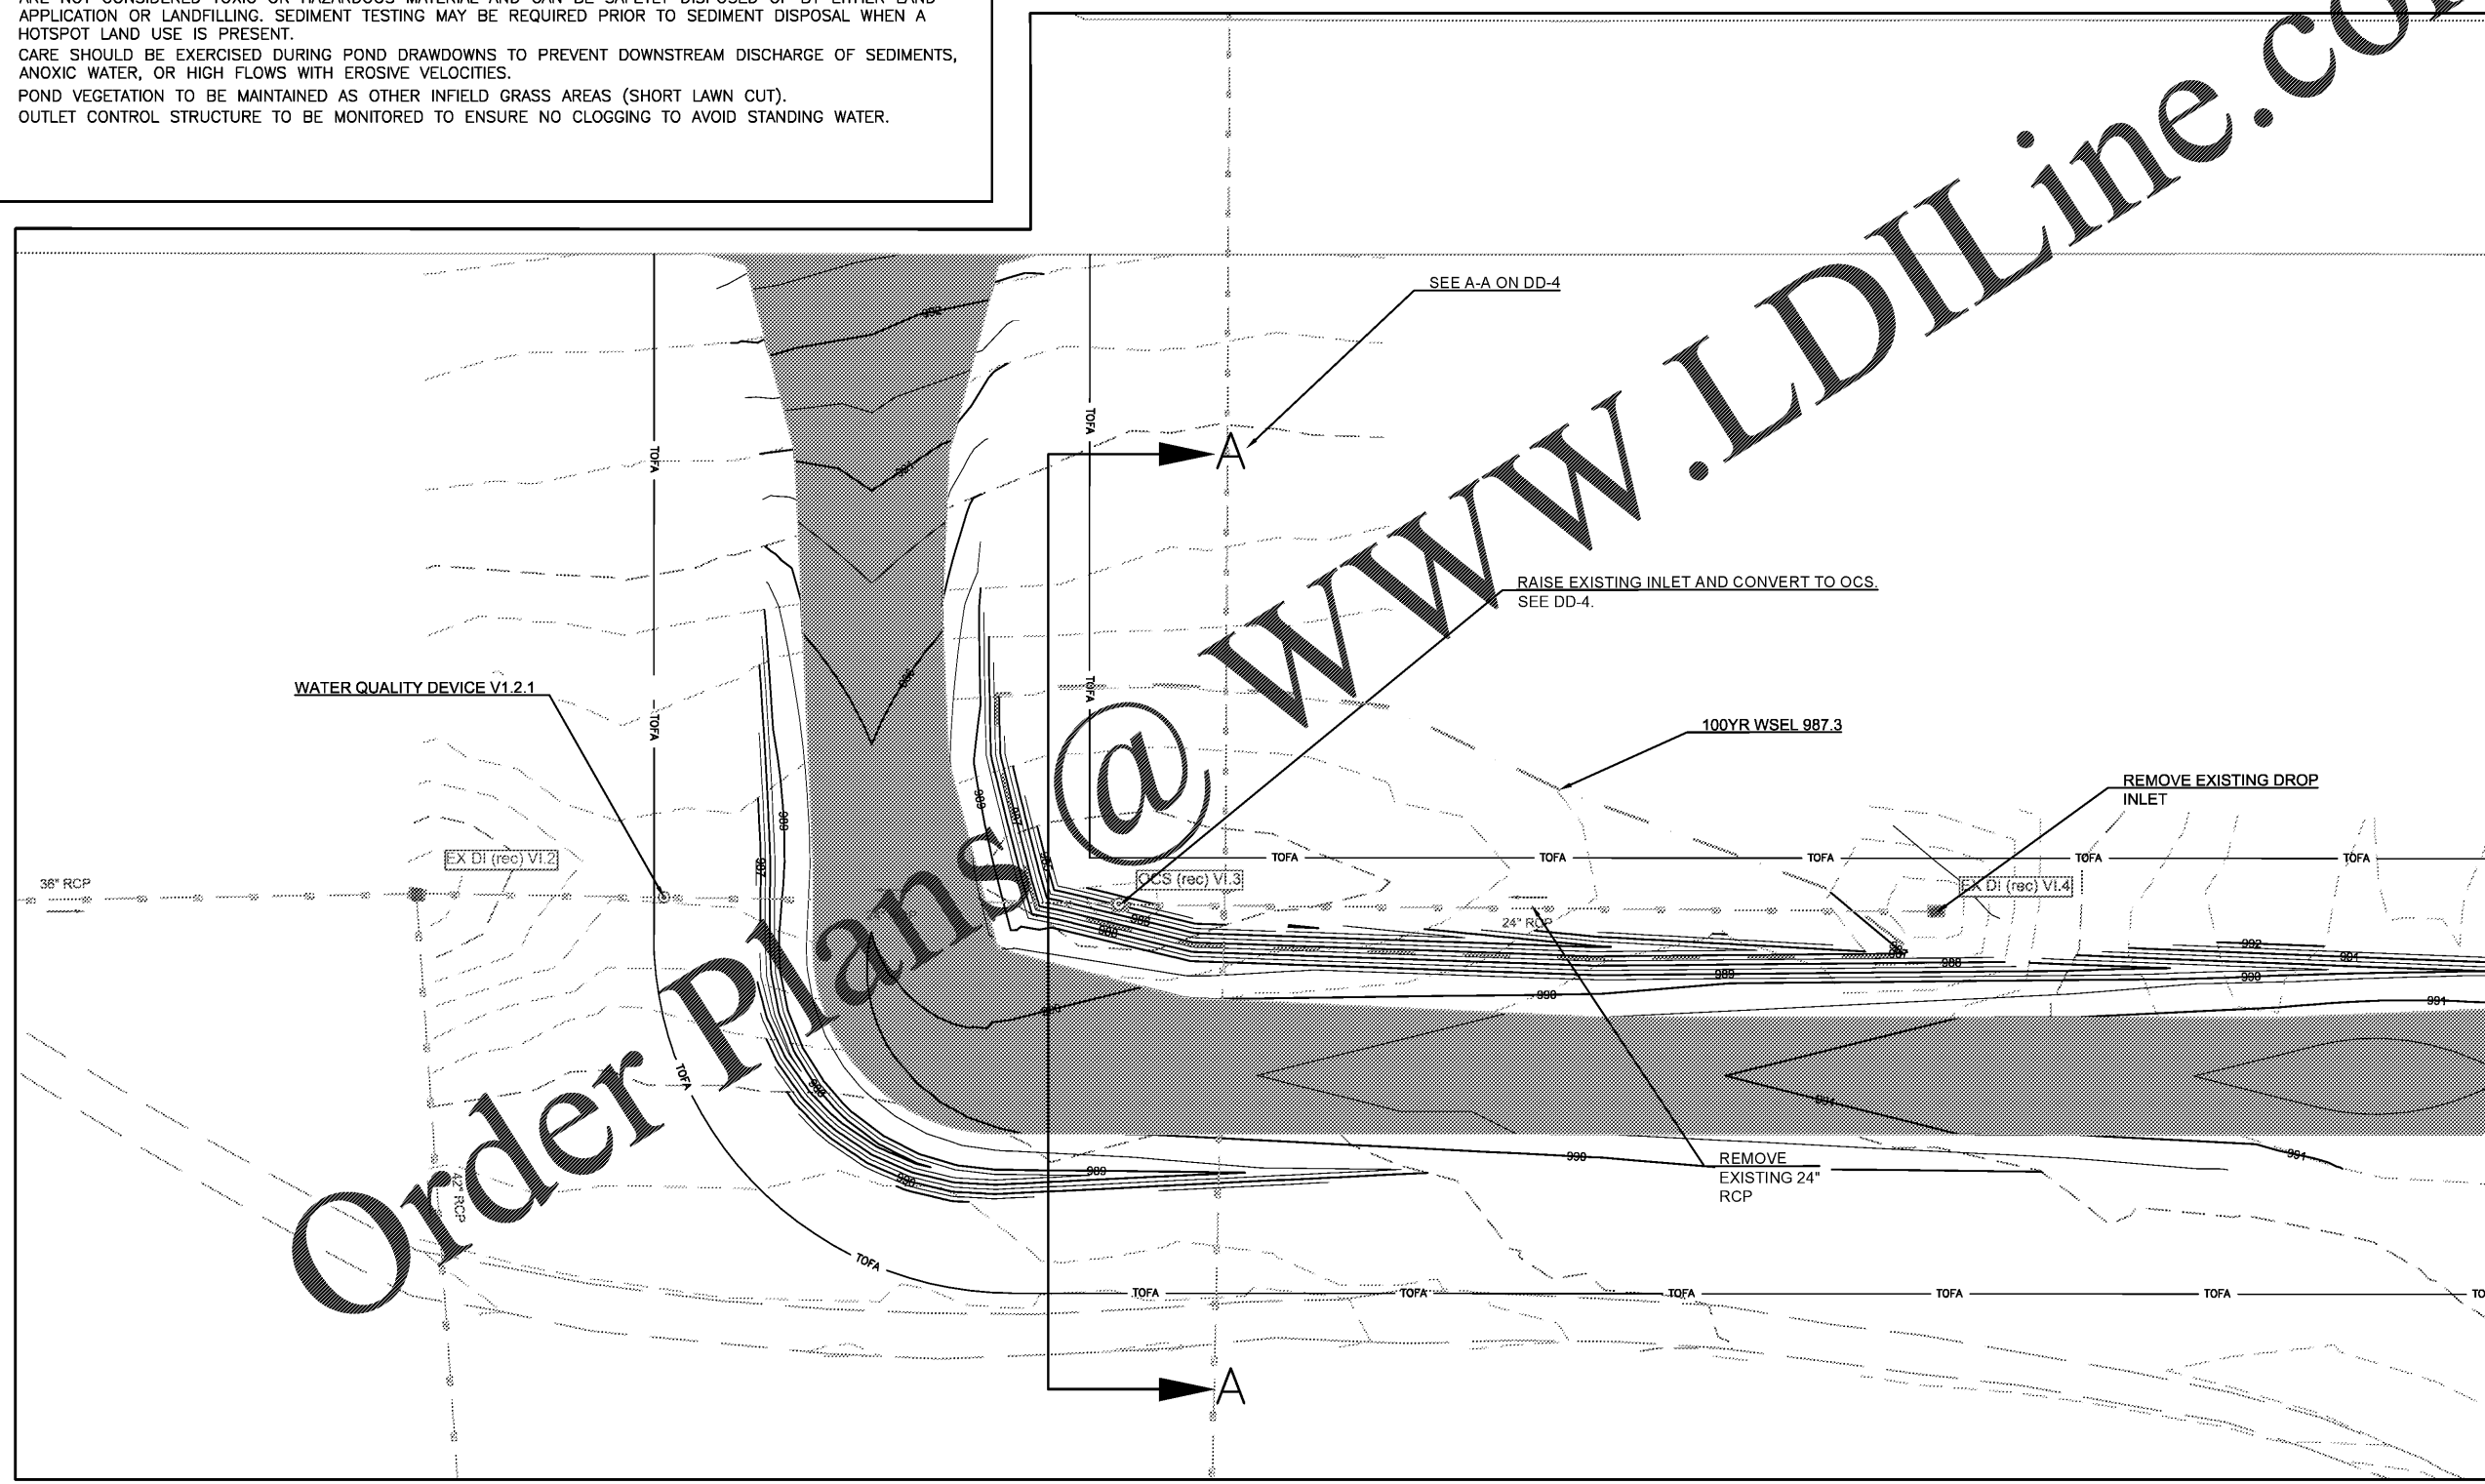

Order Plans @ www.LDILine.com