


MATCHLINE - SEE LIGHTING LAYOUT PLAN NO. 1




DEKALB PEACHTREE AIRPORT
DEKALB COUNTY, GEORGIA

Michael Baker INTERNATIONAL

Designer: **GHL**
 Technician: **GHL/RES**
 Checked by: **GHL**
 Project Number: **174297**

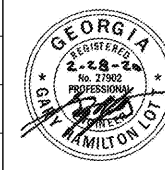

Notes:

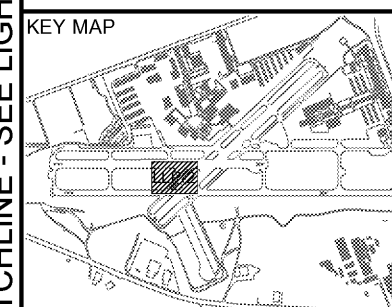

REVISIONS

No.	Description	Date	By

Project Name: **RUNWAY INCURSION MITIGATION IMPROVEMENTS (PDK 11)**

Drawing Name: **LIGHTING LAYOUT PLAN NO. 2**


ITB# 20-101257

Date: **FEBRUARY, 2020** Sheet Number: **52** of **72**

Scale: **1" = 30'** Drawing Number: **LLP-2**

MATCHLINE - SEE LIGHTING LAYOUT PLAN NO. 5

MATCHLINE - SEE LIGHTING LAYOUT PLAN NO. 7

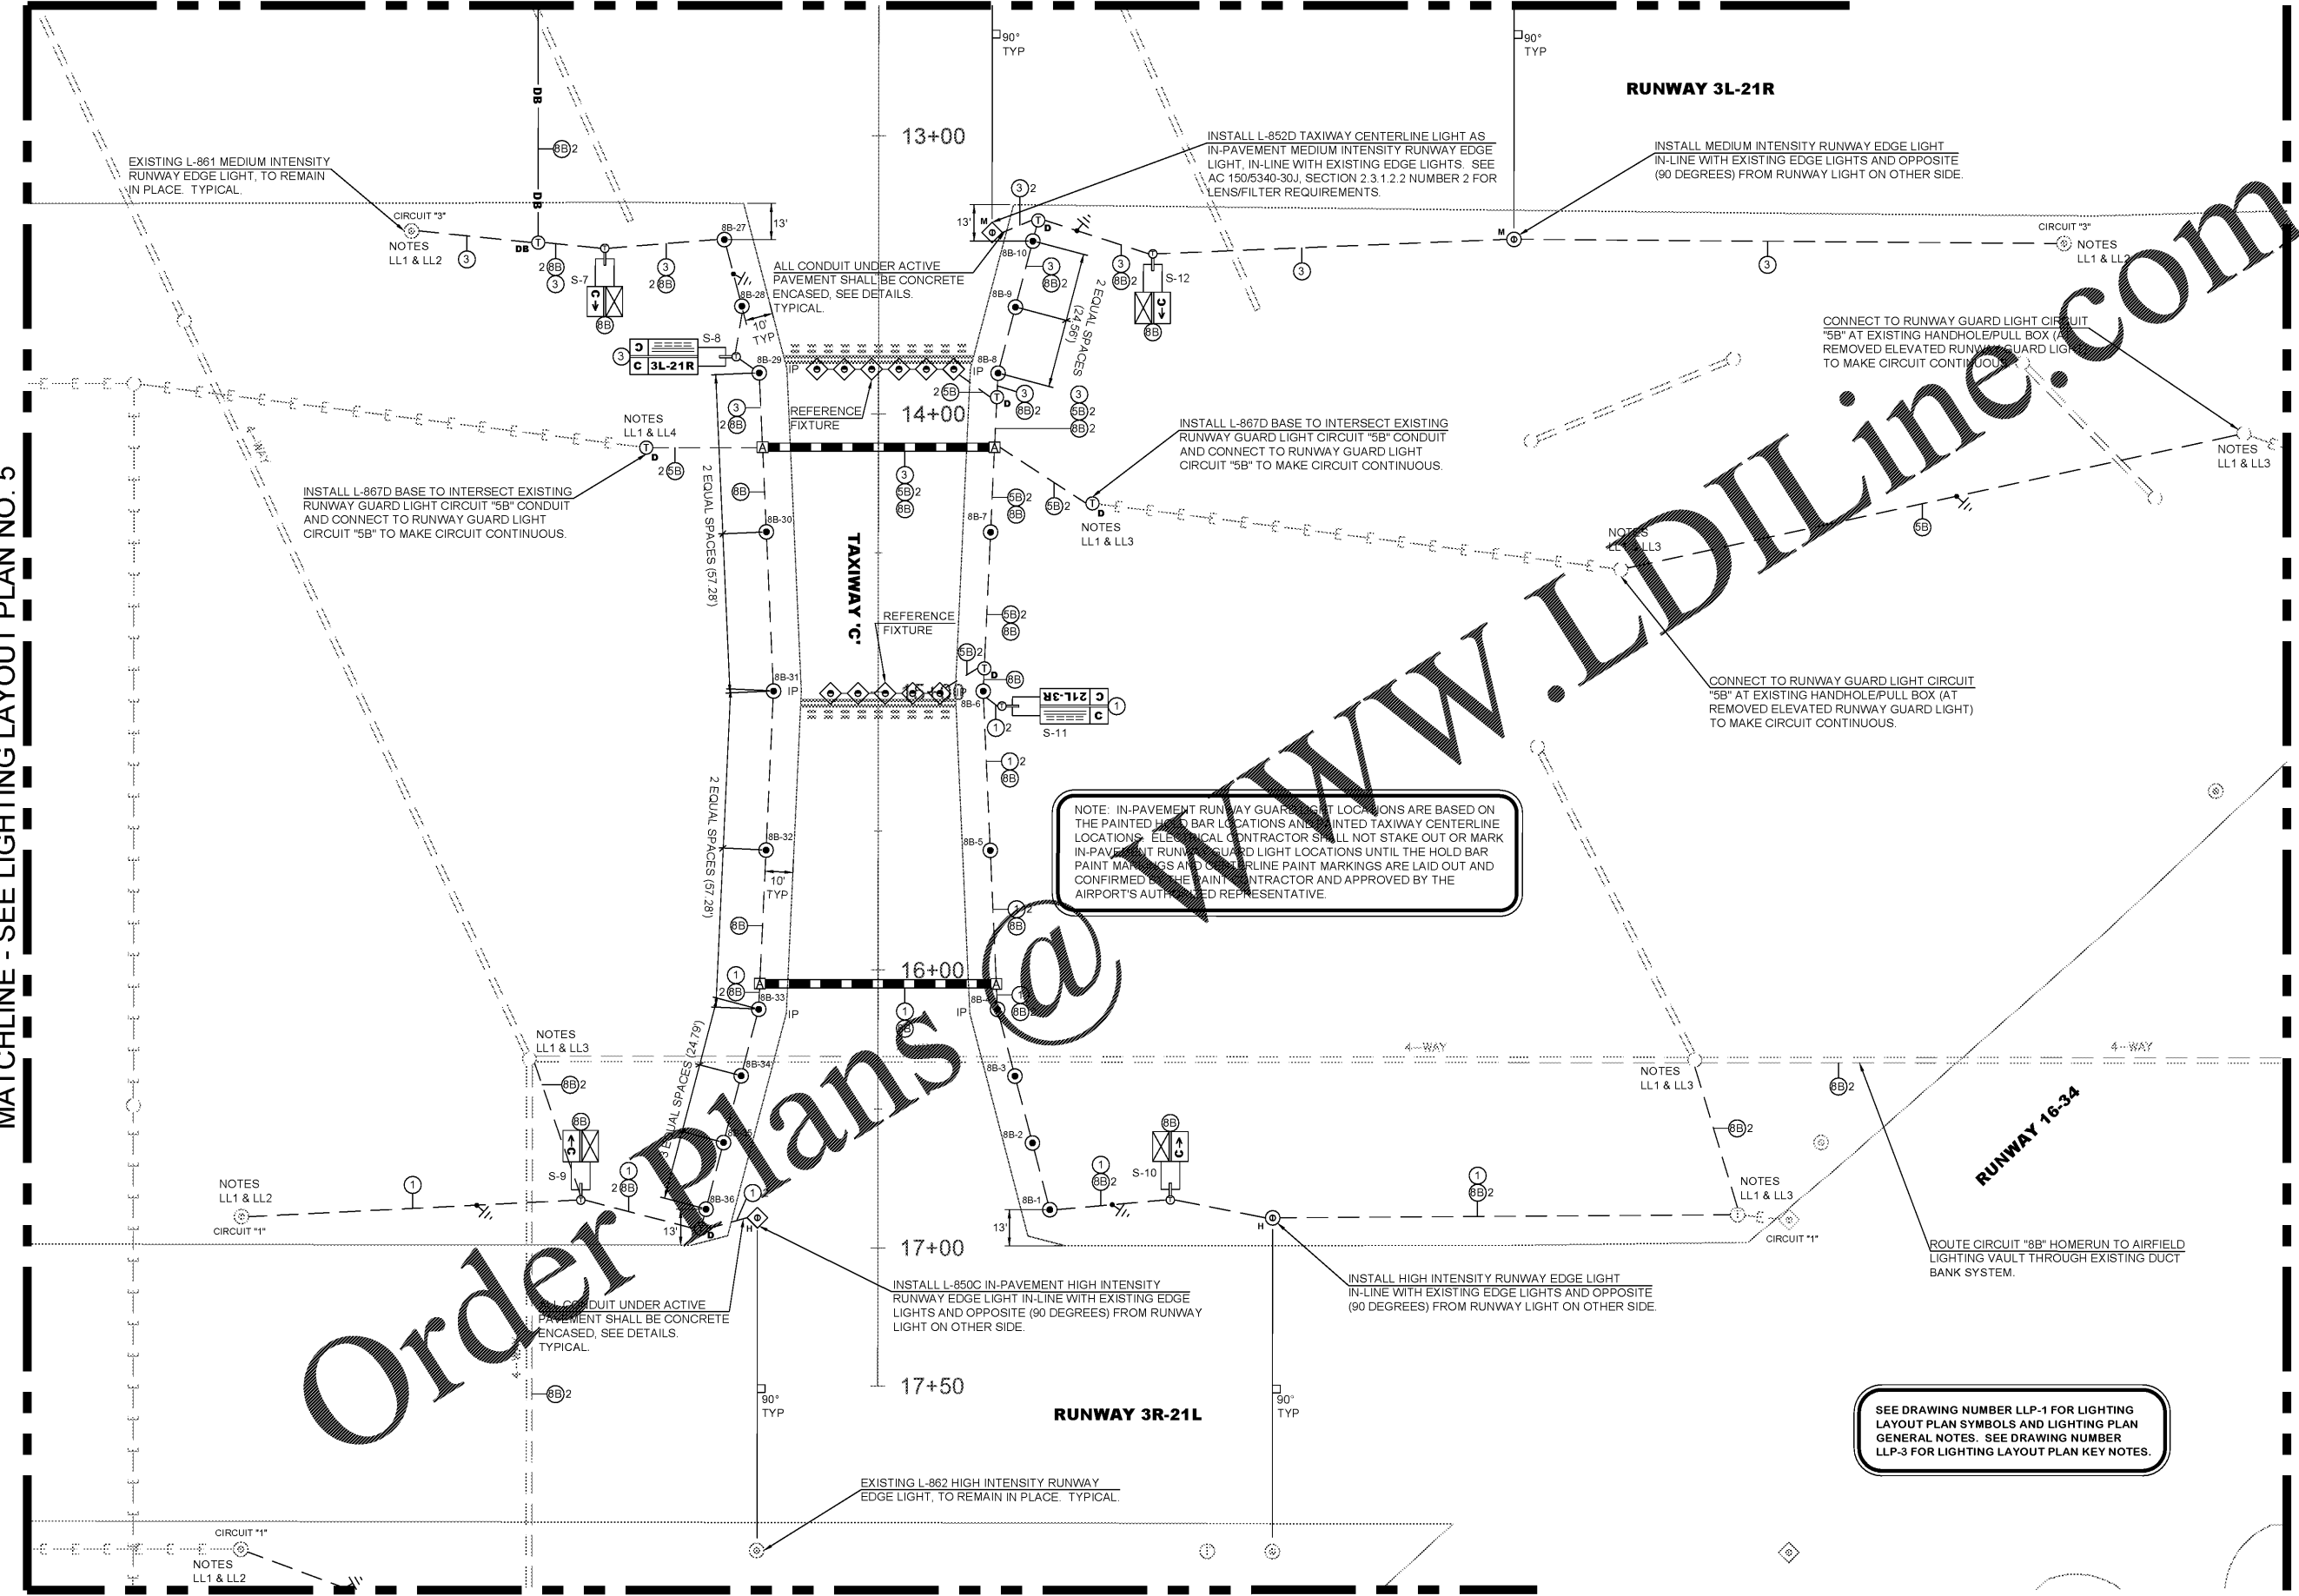

MATCHLINE - SEE LIGHTING LAYOUT PLAN NO. 4

Order Plans @

WWW.LDILine.com