

MATCHLINE - SEE LIGHTING LAYOUT PLAN NO. 8

RUNWAY 3L-21R

RUNWAY 16-34

TAXIWAY 'D'

RUNWAY 3R-21L


ROUTE CIRCUIT "8B" HOMERUN TO AIRFIELD LIGHTING VAULT THROUGH EXISTING DUCT BANK SYSTEM.

ROUTE CIRCUIT "8B" HOMERUN TO AIRFIELD LIGHTING VAULT THROUGH EXISTING DUCT BANK SYSTEM.

ROUTE CIRCUIT "8B" HOMERUN TO AIRFIELD LIGHTING VAULT THROUGH EXISTING DUCT BANK SYSTEM.

SEE DRAWING NUMBER LLP-1 FOR LIGHTING LAYOUT PLAN SYMBOLS AND LIGHTING PLAN GENERAL NOTES. SEE DRAWING NUMBER LLP-3 FOR LIGHTING LAYOUT PLAN KEY NOTES.

MATCHLINE - SEE LIGHTING LAYOUT PLAN NO. 2

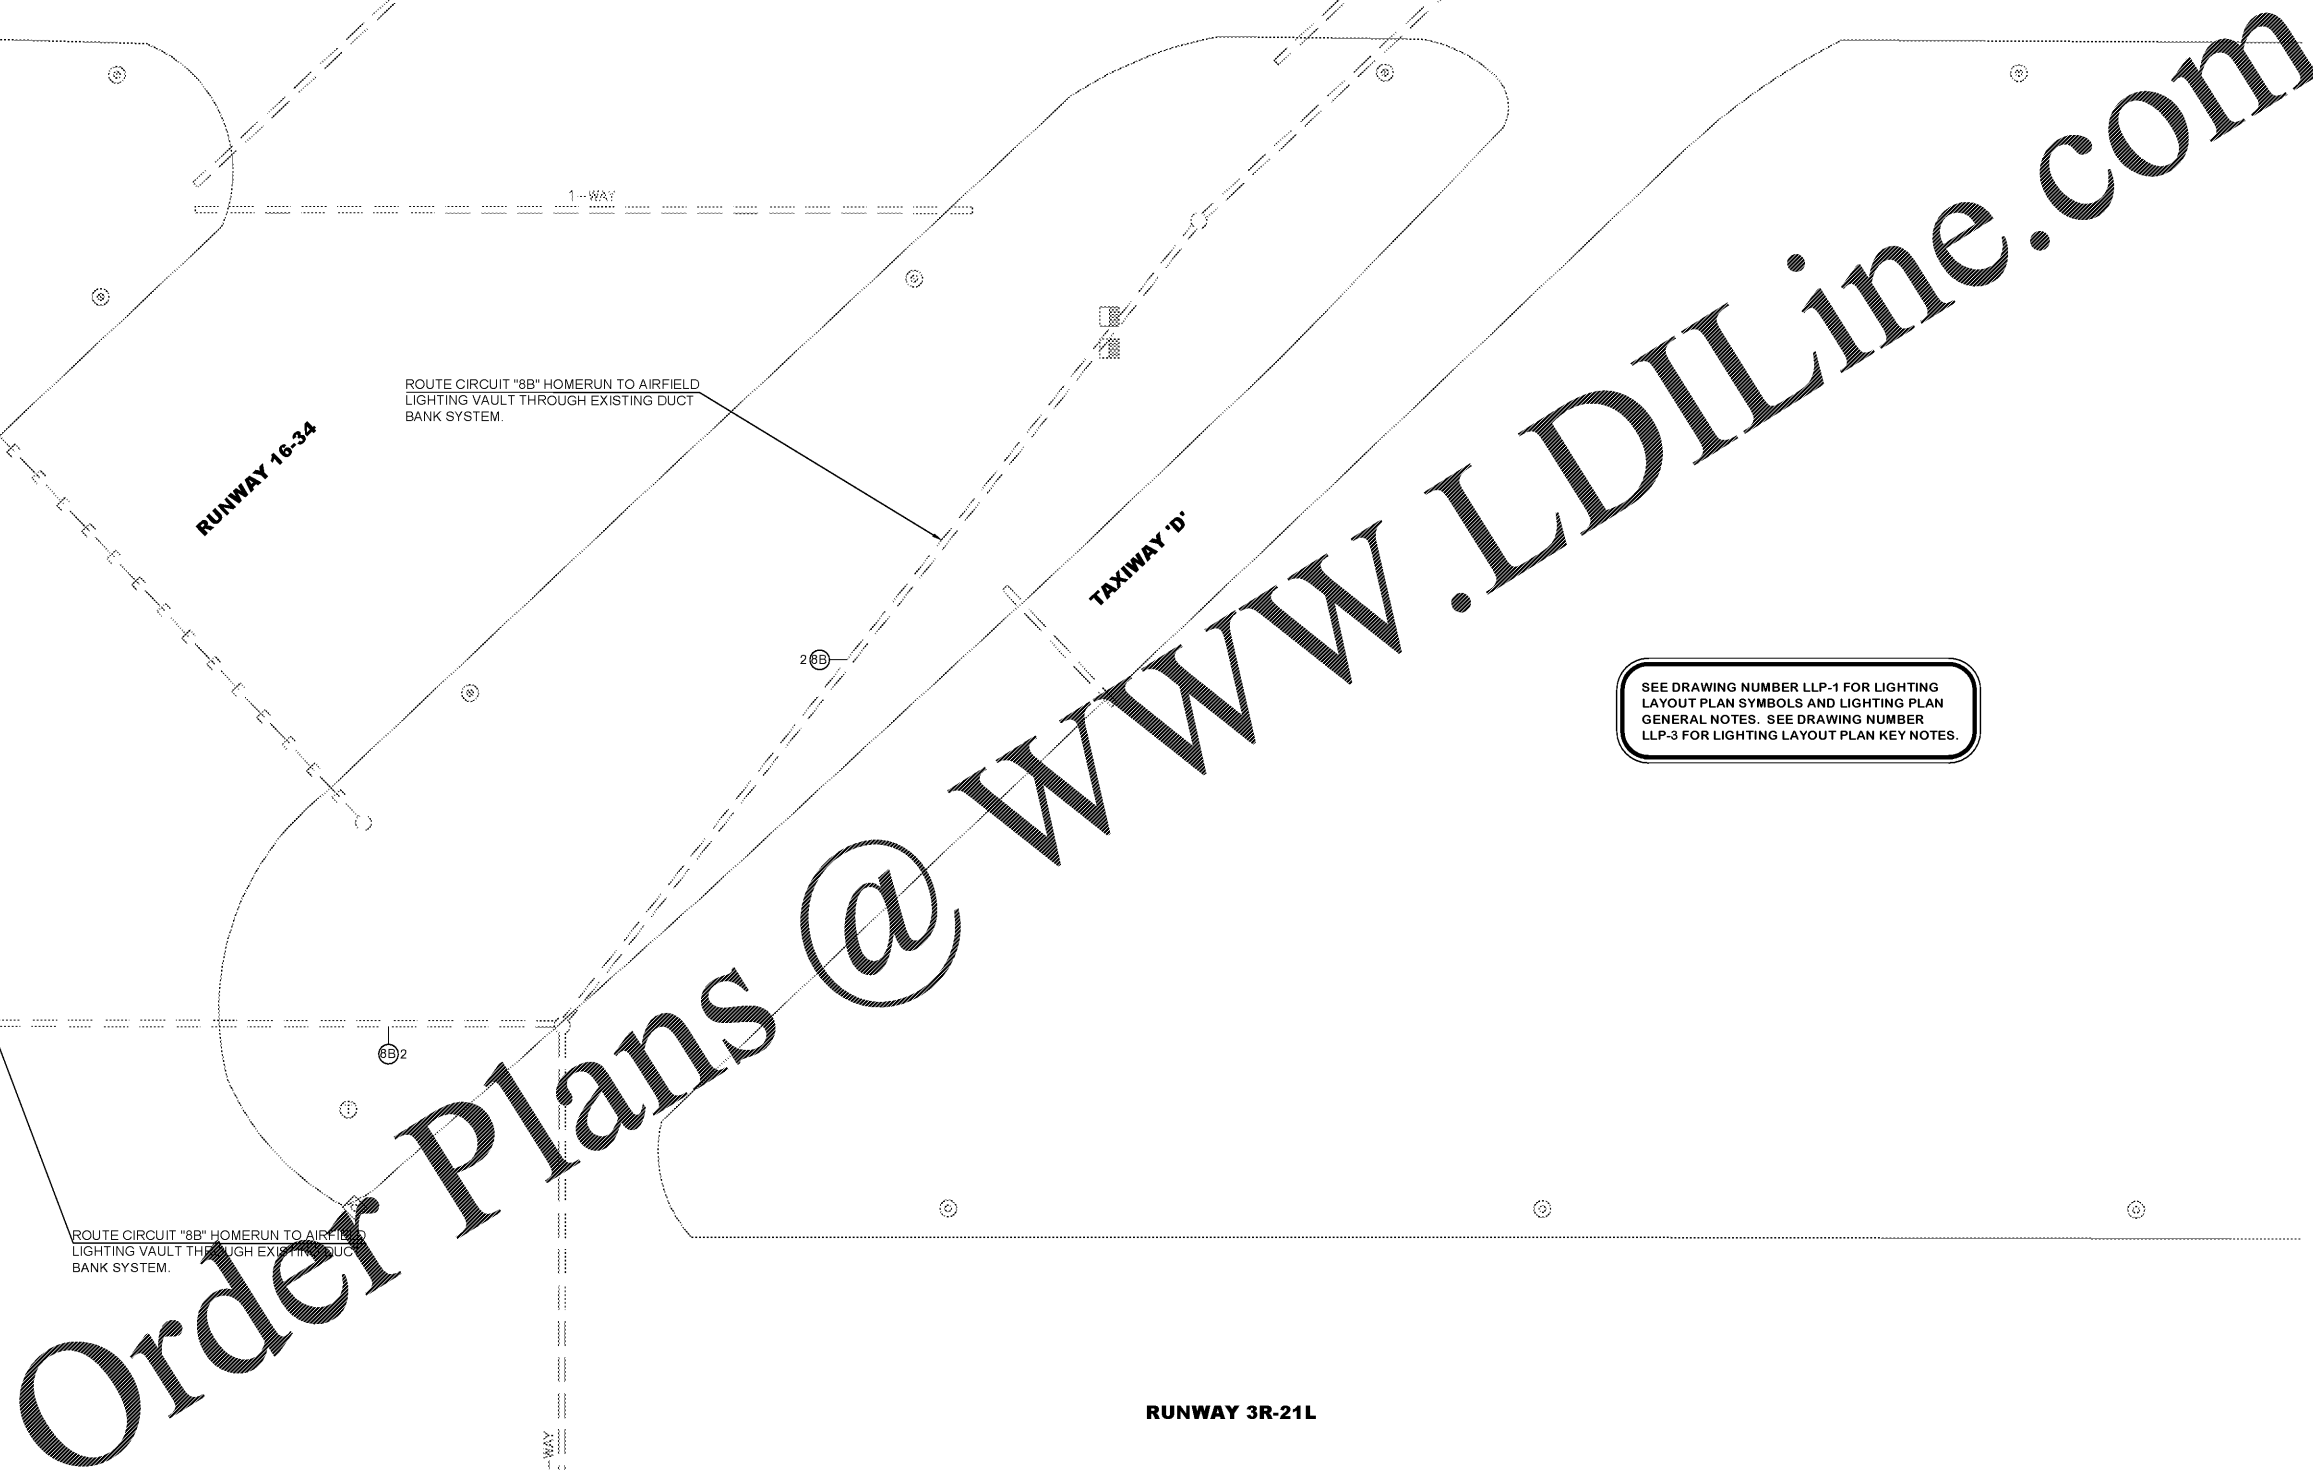


DEKALB PEACHTREE AIRPORT
DEKALB COUNTY, GEORGIA

Michael Baker INTERNATIONAL


Designer:
GHL
Technician:
GHL/RES
Checked by:
GHL
Project Number:
174297



 Notes:



KEY MAP

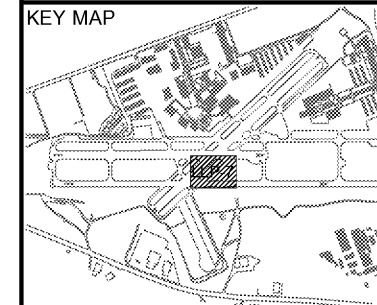

REVISIONS

No.	Description	Date	By

Project Name:

RUNWAY INCURSION MITIGATION IMPROVEMENTS (PDK 11)

Drawing Name:

LIGHTING LAYOUT PLAN NO. 7

ITB# 20-101257

Date: **FEBRUARY, 2020** Sheet Number: **57** of **72**

Scale: **1" = 30'** Drawing Number: **LLP-7**