


MATCHLINE - SEE LIGHTING LAYOUT PLAN NO. 9

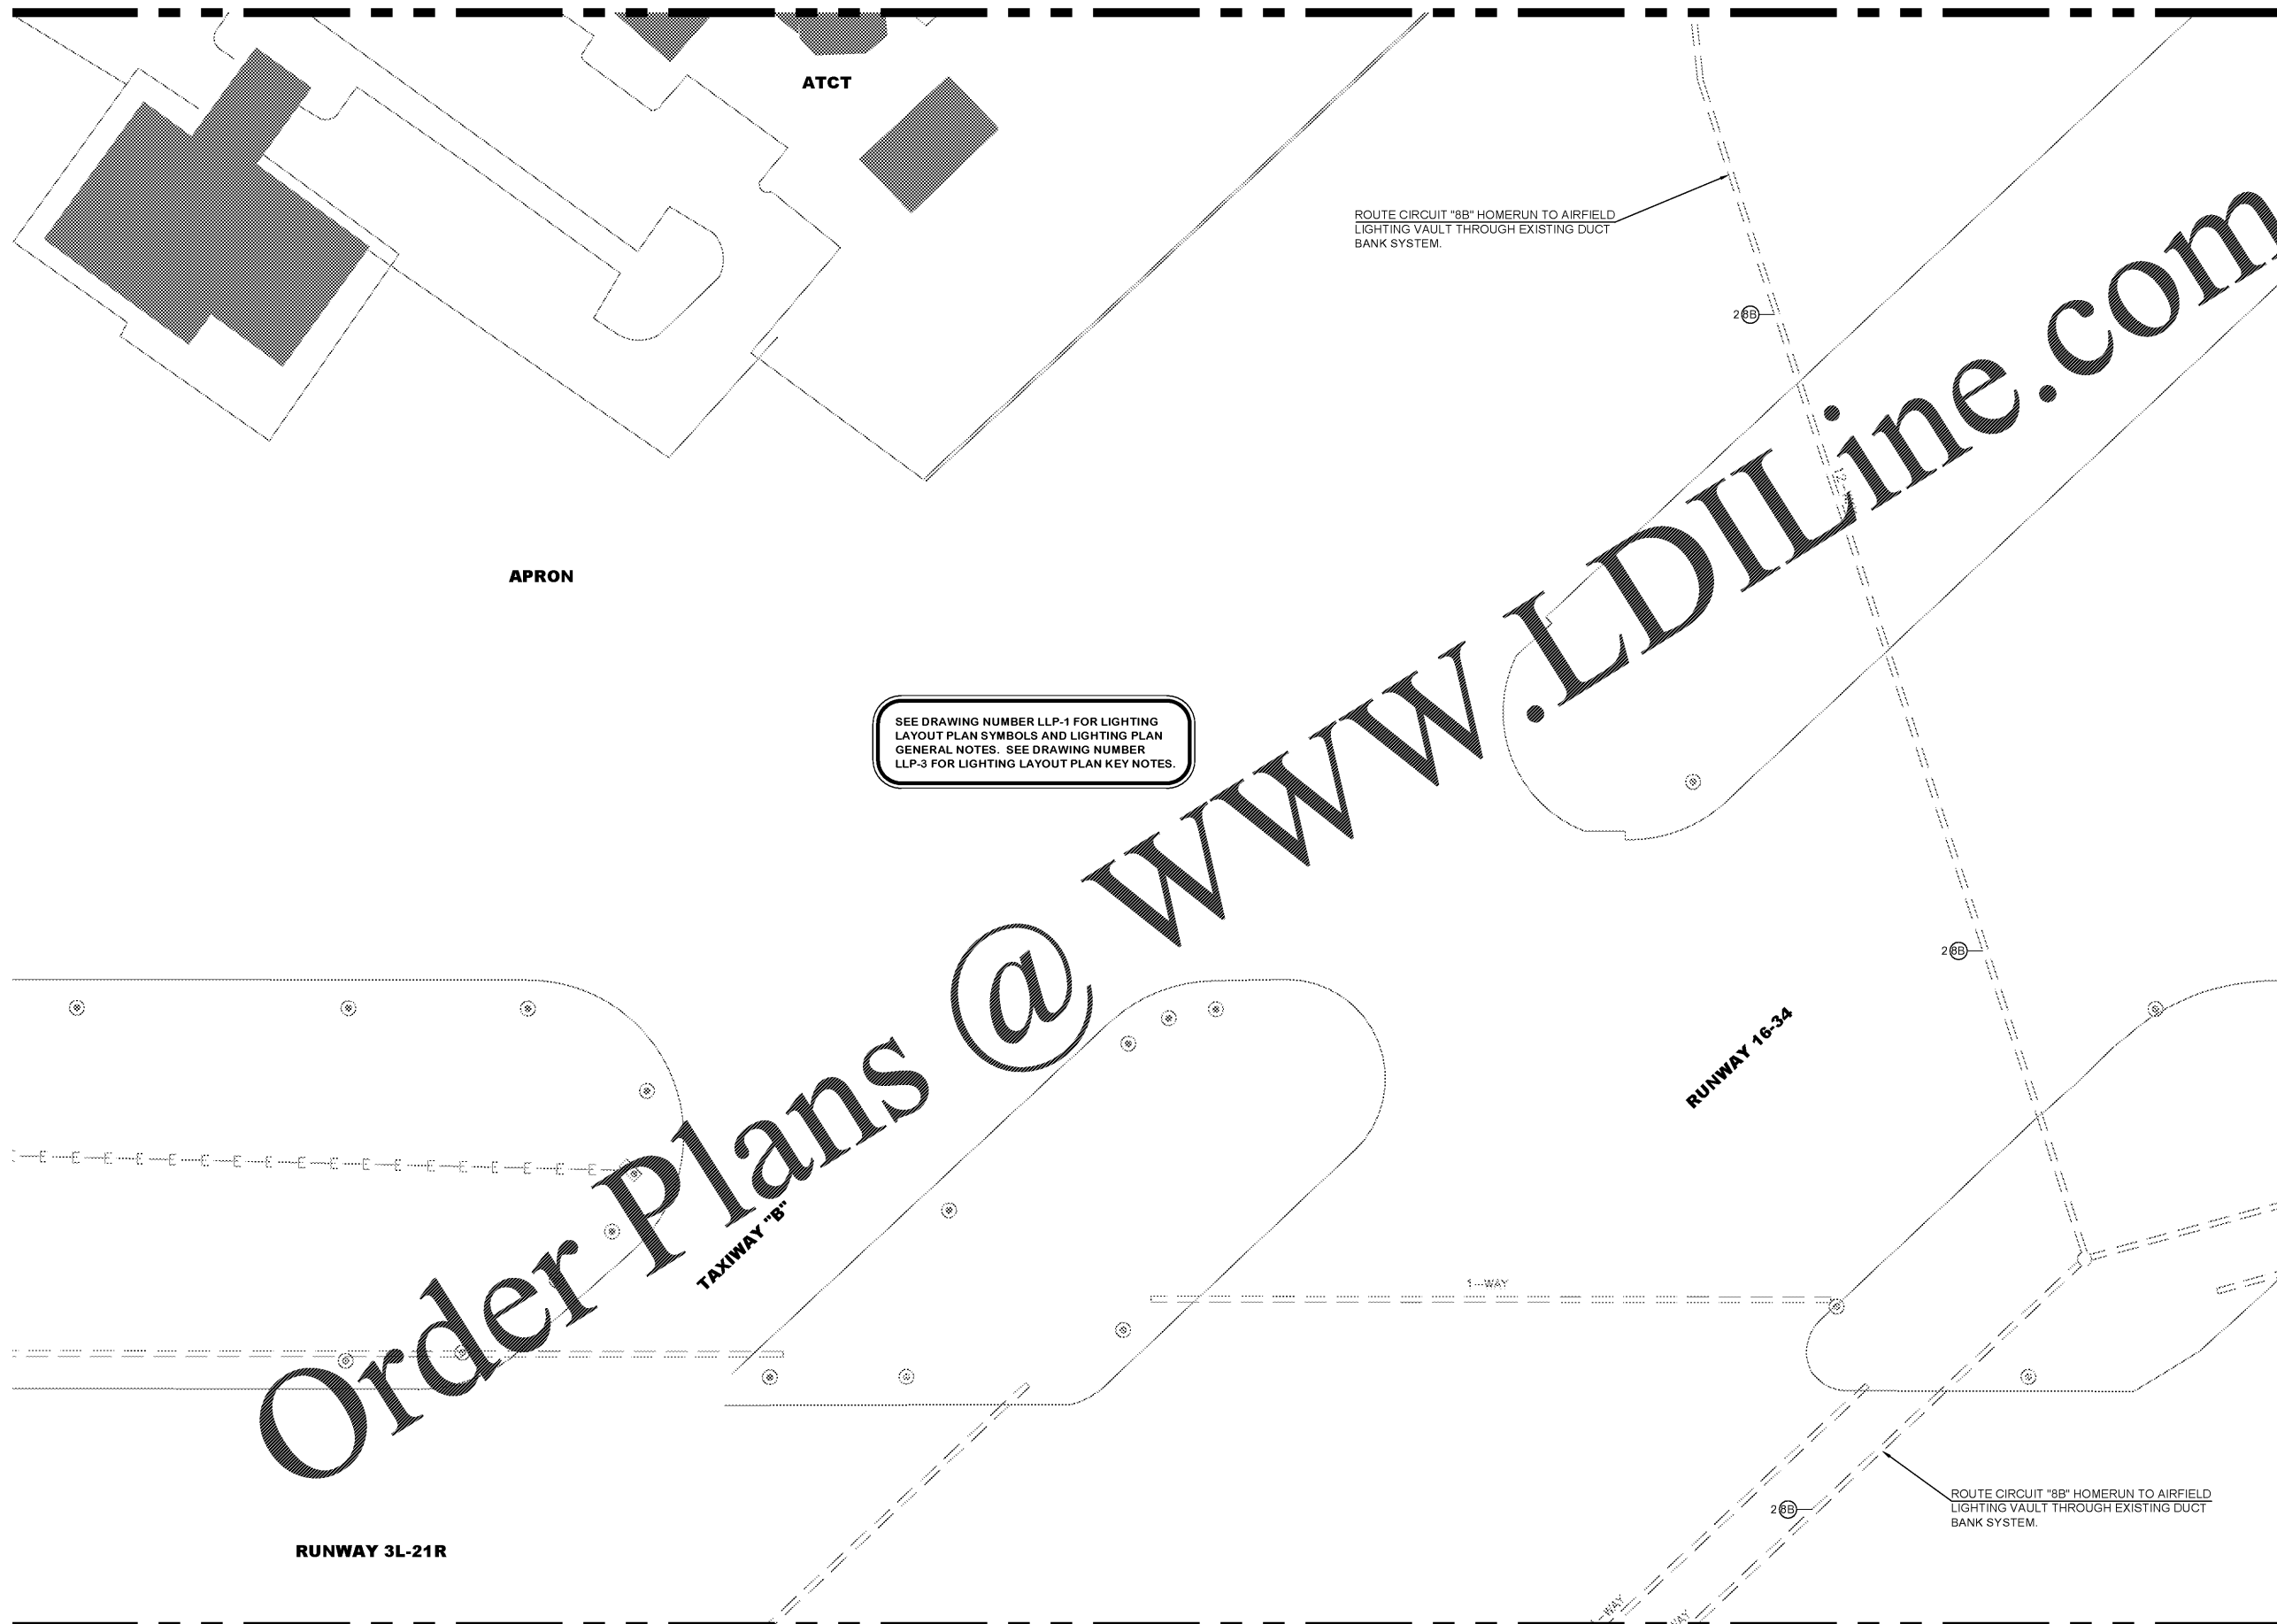

SEE DRAWING NUMBER LLP-1 FOR LIGHTING LAYOUT PLAN SYMBOLS AND LIGHTING PLAN GENERAL NOTES. SEE DRAWING NUMBER LLP-3 FOR LIGHTING LAYOUT PLAN KEY NOTES.

Order Plans @ www.LDILine.com



DEKALB PEACHTREE AIRPORT
DEKALB COUNTY, GEORGIA


Michael Baker INTERNATIONAL

Designer:
GHL
Technician:
GHL/RES
Checked by:
GHL
Project Number:
174297



Notes:

1" = 30'

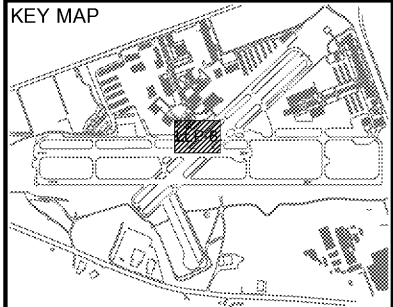

REVISIONS

No.	Description	Date	By

Project Name:
RUNWAY INCURSION MITIGATION IMPROVEMENTS (PDK 11)

Drawing Name:
LIGHTING LAYOUT PLAN NO. 8

ITB# 20-101257

Date: **FEBRUARY, 2020** Sheet Number: **58** of **72**

Scale: **1" = 30'** Drawing Number: **LLP-8**

MATCHLINE - SEE LIGHTING LAYOUT PLAN NO. 7