





www.LDILine.com

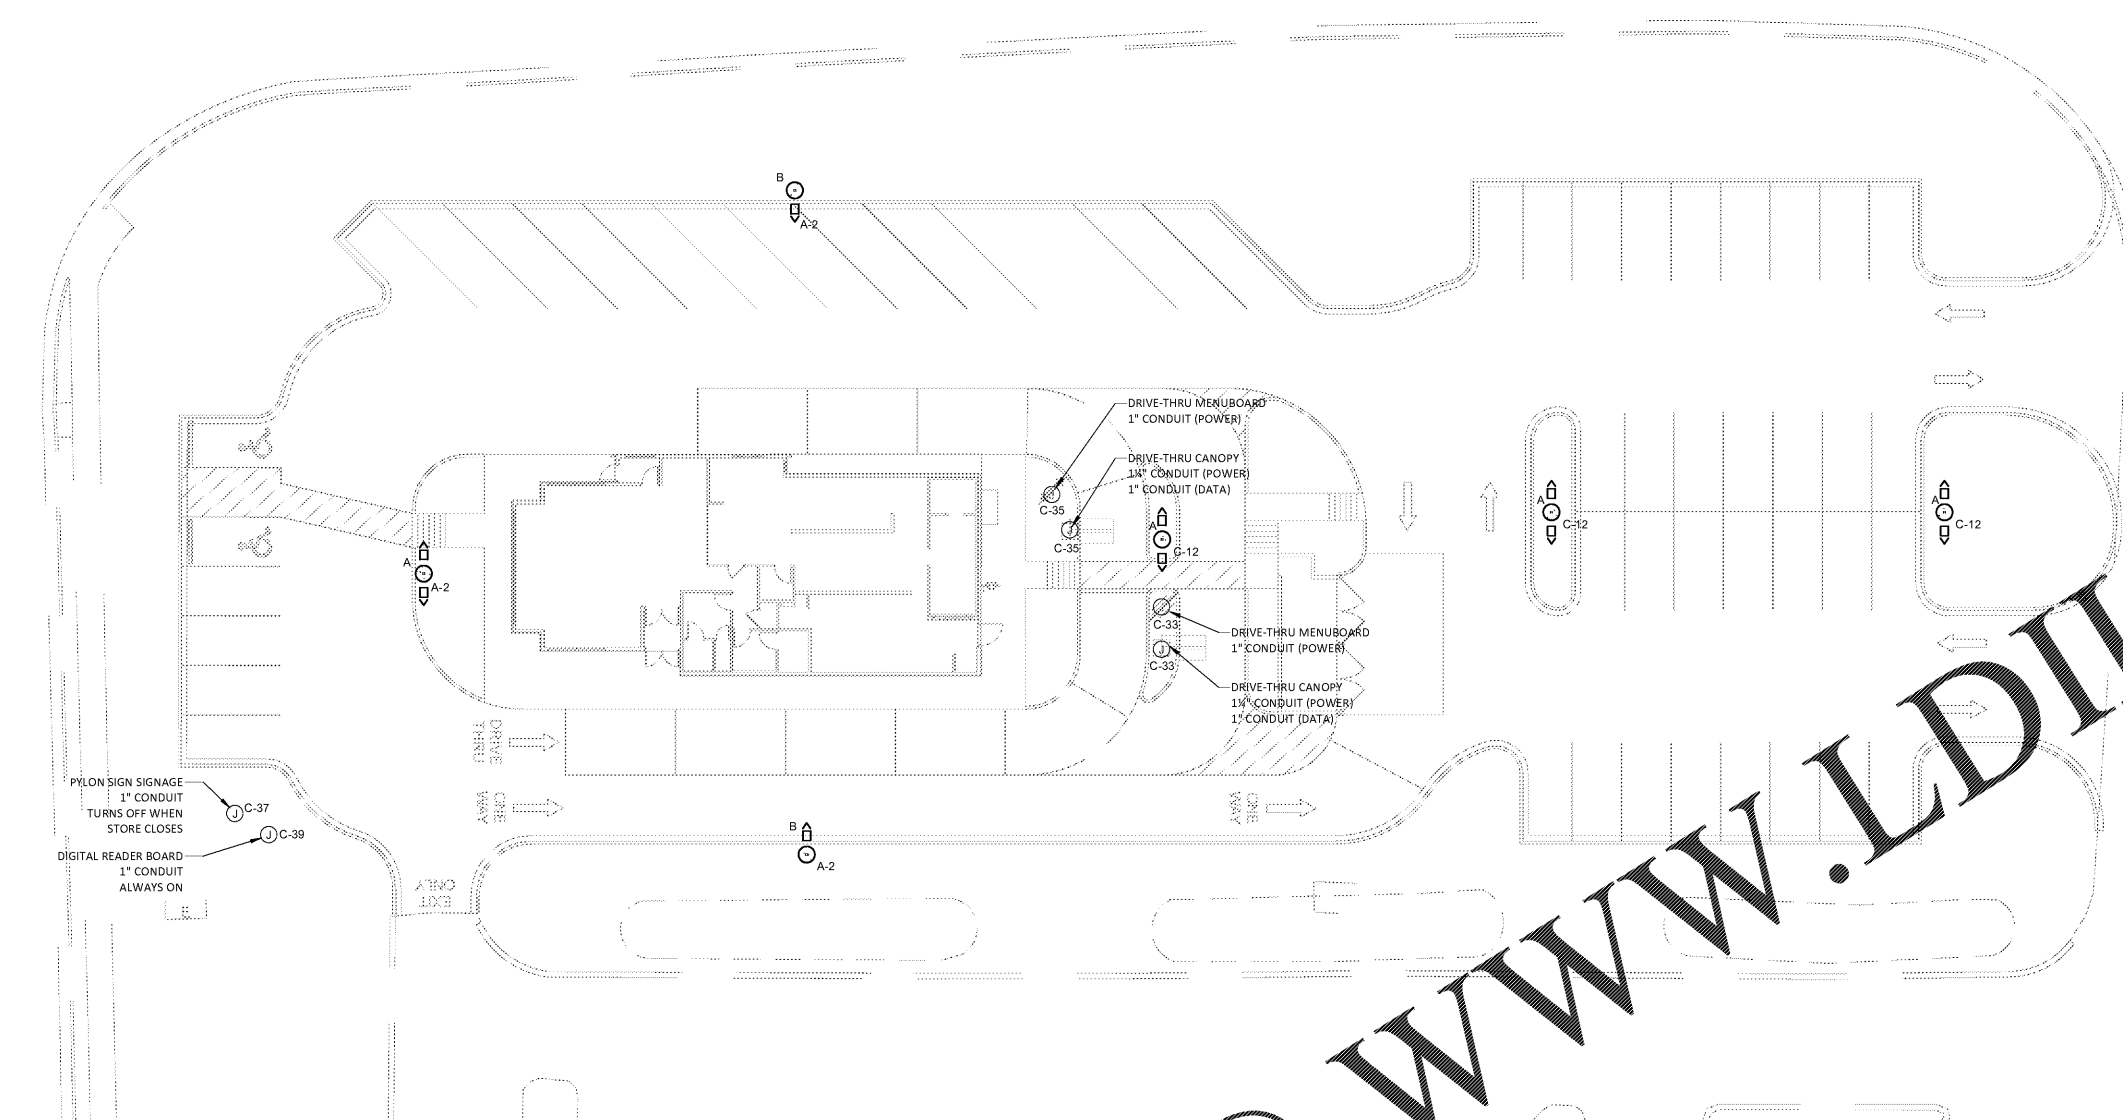

1 SITE POWER PLAN
 E0.1 1/16" = 1'-0"

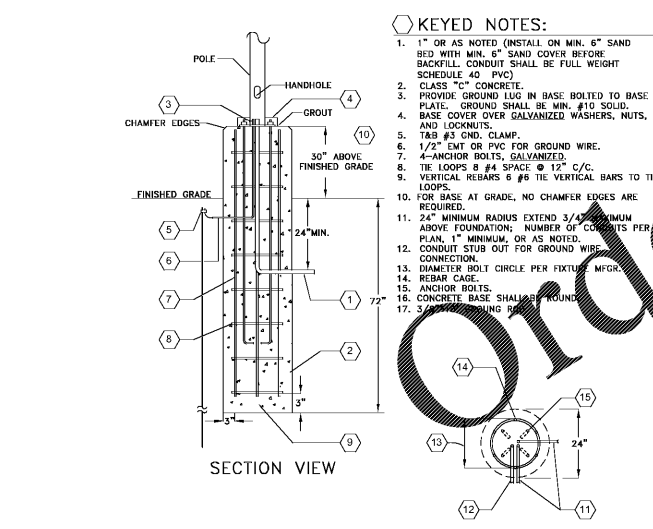

TYPE	SYMBOL	Count	DESCRIPTION	MANUFACTURER	MODEL	Lamp	INPUT WATTS
A		4	AREA AND ROADWAY LUMINAIRE - DOUBLE HEAD	LITHONIA LIGHTING	DSX2 LED P1 50K TSM MVOLT	LED	280 W
B		2	AREA AND ROADWAY LUMINAIRE - SINGLE HEAD W/ HOUSESIDE SHIELD	LITHONIA LIGHTING	DSX2 LED P1 50K T2M MVOLT HS	LED	140 W


JPL MANAGEMENT

ISSUE INFORMATION

REVISIONS

NO.	DATE	DESCRIPTION

Neico Architecture, Inc.

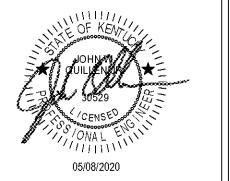

PROJECT INFORMATION

BOWLING GREEN, KY
 DISHMAN LANE
 BOWLING GREEN, KY 42101
 PROJECT #:
 11352

SHEET INFORMATION

SITE POWER PLAN
 DRAWN BY:
 Designer
 REVIEWED BY:
 Checker
 SCALE:
 As indicated
 AUTHORIZED FOR:
 PERMIT

E0.1