



JPL MANAGEMENT

ISSUE INFORMATION

REVISIONS

NO.	DATE	DESCRIPTION

Neico Architecture, Inc.



PROJECT INFORMATION

BOWLING GREEN, KY

DISHMAN LANE
 BOWLING GREEN, KY 42101


PROJECT #:
 11352

SHEET INFORMATION

ROOF POWER PLAN

DRAWN BY:
 ED/ZFB
REVIEWED BY:
 JJC/JWQ
SCALE:
 1/4" = 1'-0"
AUTHORIZED FOR:
 PERMIT

E3

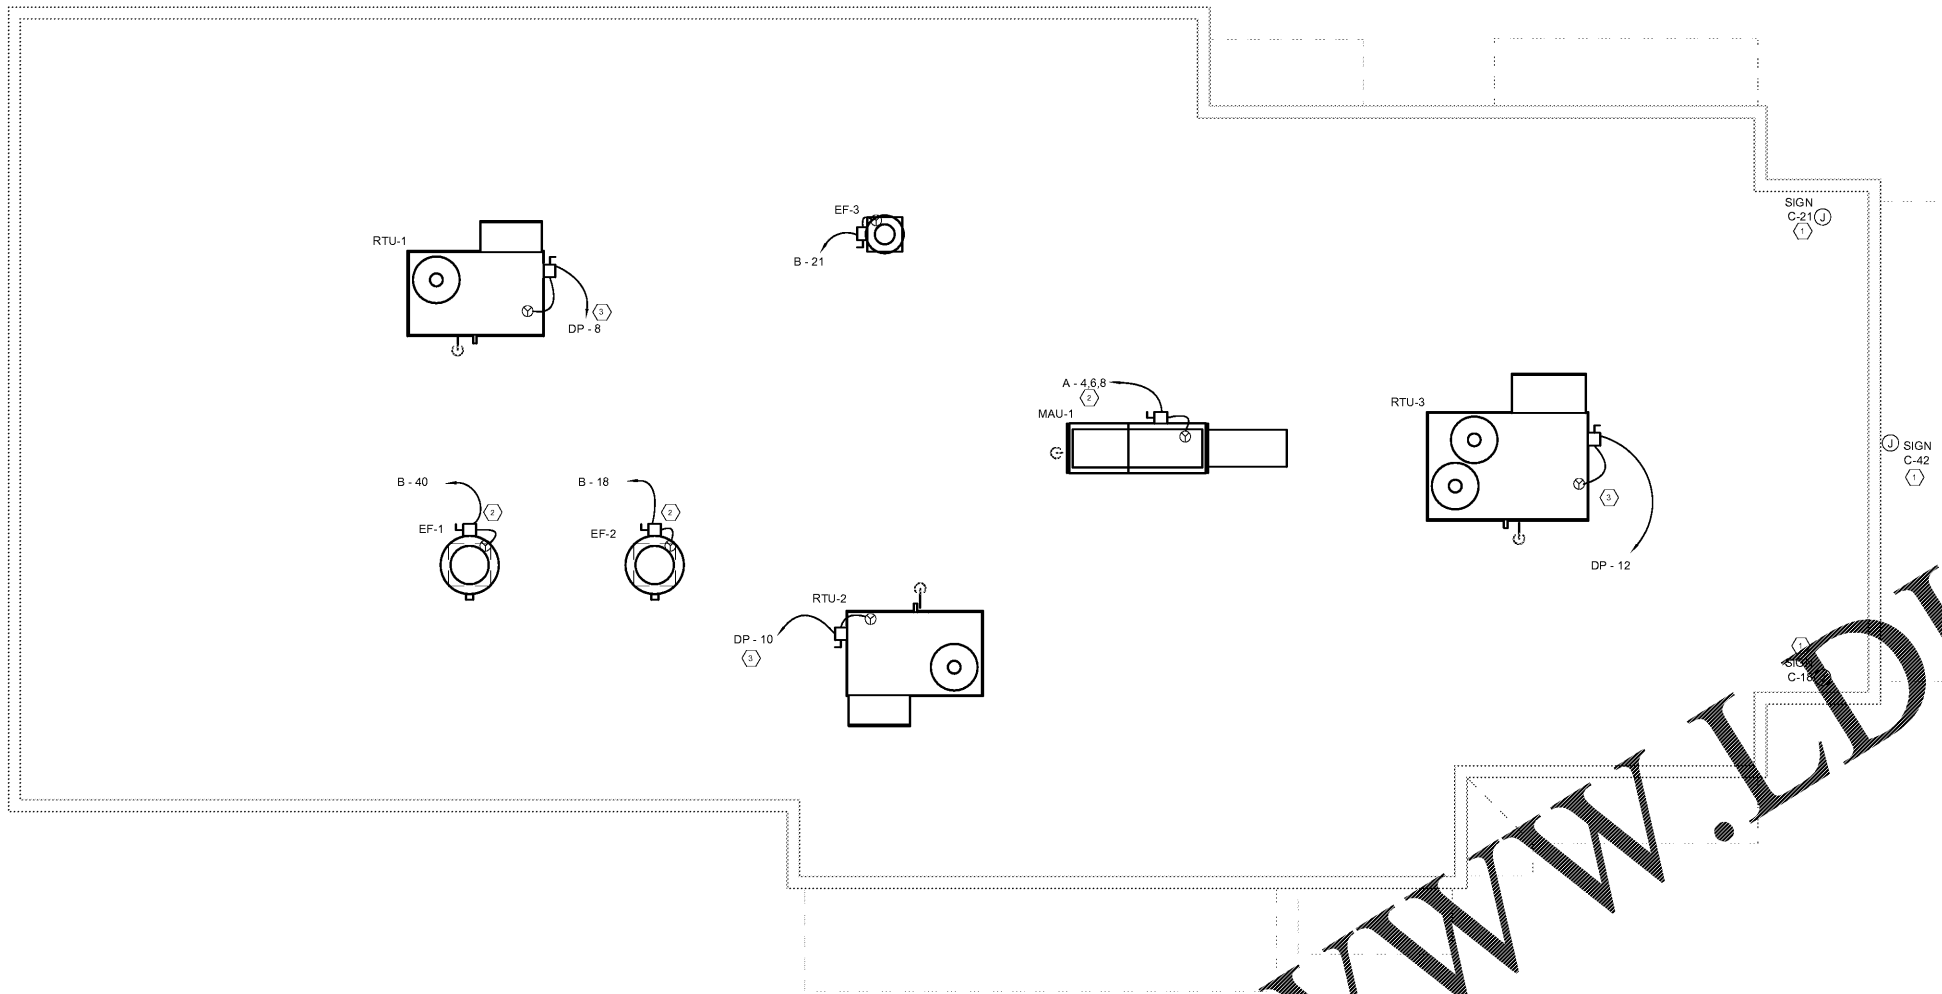

1 ELECTRICAL ROOF PLAN
 E3 1/4" = 1'-0"

##	KEYED NOTES
1.	PROVIDE CONNECTION TO EXTERIOR BUILDING SIGN. COORDINATE WITH SIGN MANUFACTURER FOR FINAL LOCATION.
2.	PROVIDE 50A/3P/NF NEMA-3R DISCONNECT SWITCH AND FINAL CONNECTION TO NEW MECHANICAL EQUIPMENT.
3.	PROVIDE 60A/3P/NF NEMA-3R DISCONNECT SWITCH AND FINAL CONNECTION TO NEW MECHANICAL EQUIPMENT.

Order Plans @ www.LDILine.com