


Order Plans

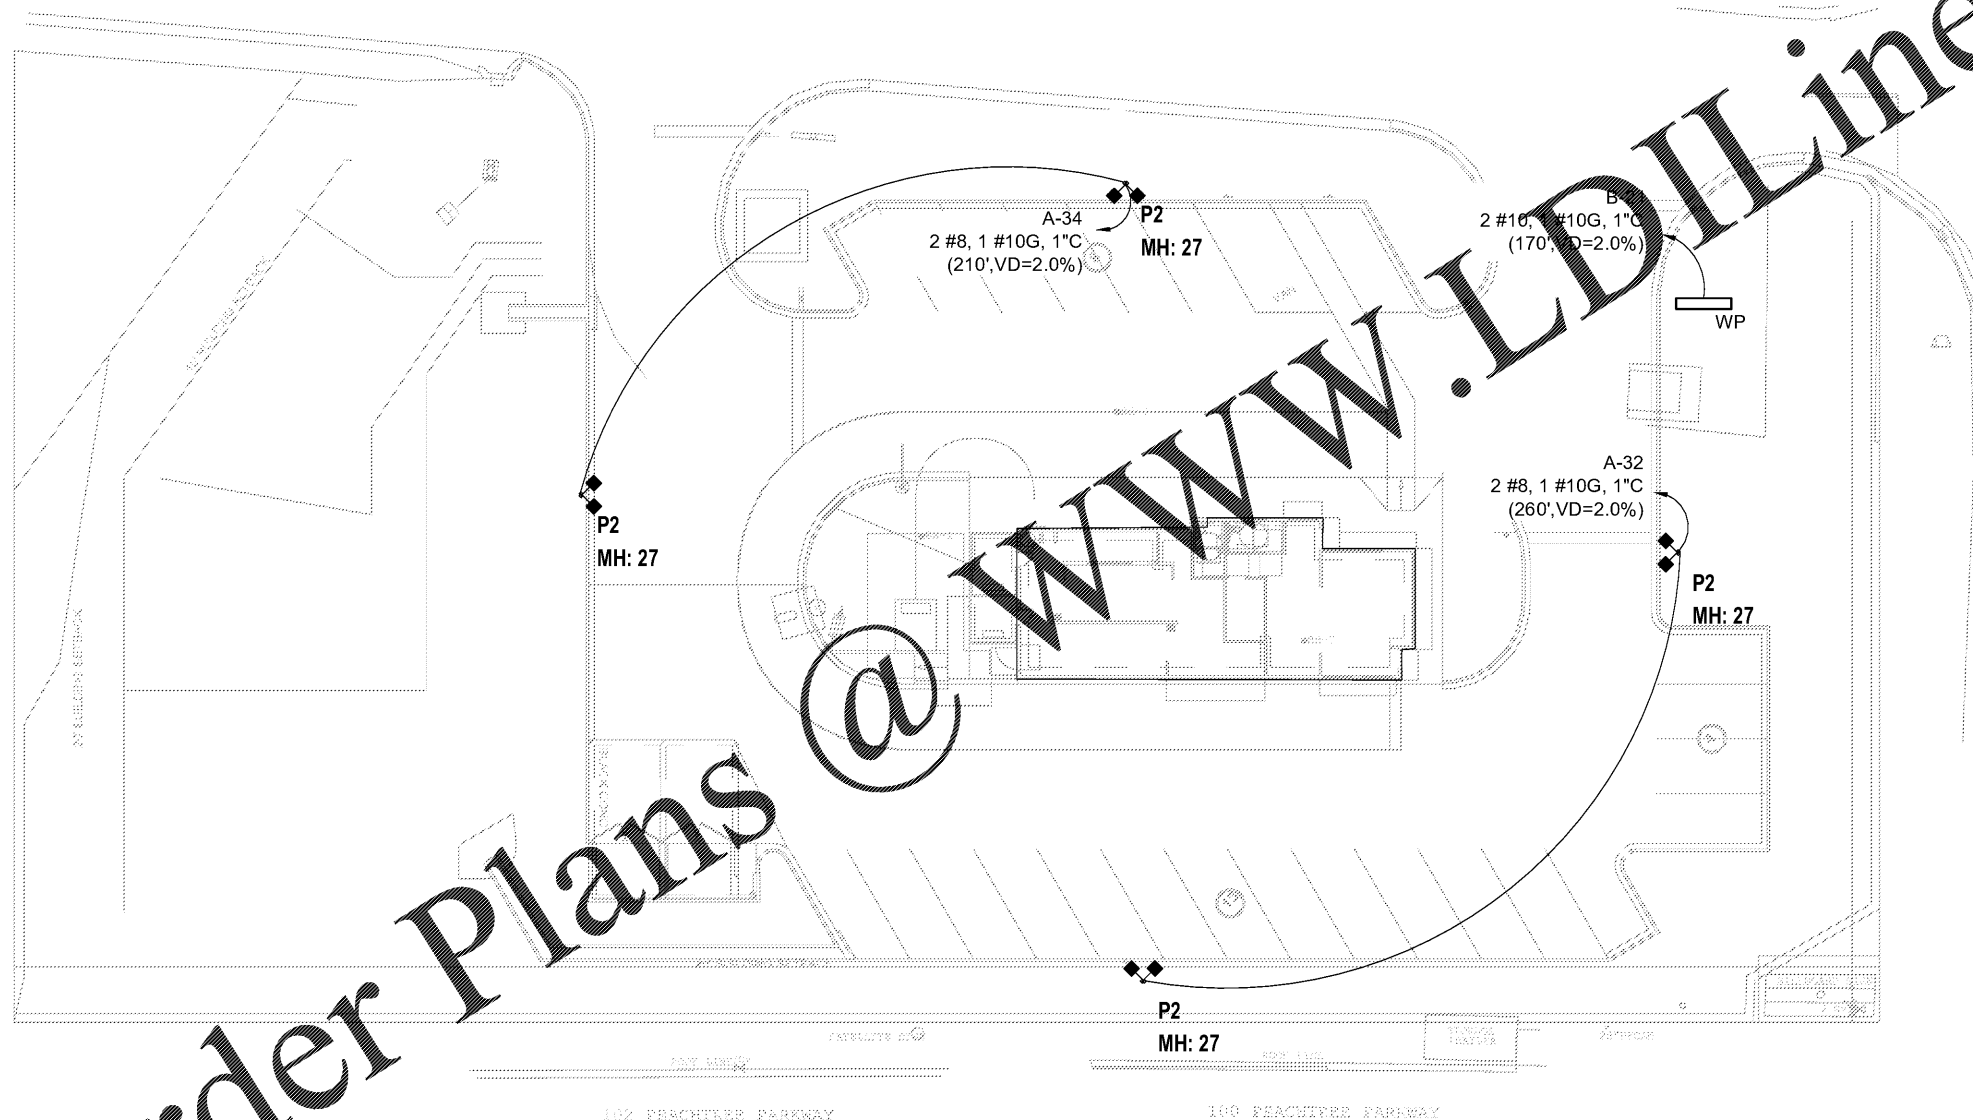

WWW.LDILine.com

LIS EXPRESSLY RESERVES ITS COPYRIGHT AND ALL OTHER PROPERTY RIGHTS TO THESE DOCUMENTS AND THEIR DESIGN. HENCE, THEY ARE NOT TO BE REPRODUCED.

CLIENT NAME  
**SOUTHEASTERN RETAIL DEVELOPMENT, LLC**  
 BLDG M-1, UNIT Z31  
 2050 COUNTY ROAD 30A  
 SANTA ROSA BEACH, FL 32459

PROJECT NAME  
**POPEYES**  
 PLK 1930-28-DL SAILORMEN  
 501 N HWY 49  
 BIRON, GA 31008

SEAL  
 ROBERT W. CASE  
 GEORGIA PE #020594

RELEASE	DATE
1	
2	
3	
4	
5	
6	

PROJECT NO.  
**2020-085**

ISSUE DATE  
**05/07/20**

DRAWN | CHECKED  
 | **CS**

SHEET NO.  
**SL2**  
 SITE ELECTRICAL PLAN

ARCHITECT/ENGINEER  
**LIS**  
 LAND INVESTMENT SERVICES, LLC  
 2572 West State Road 428  
 Suite 2084, Orlando, FL 32705  
 Phone: (407) 244-4419  
 Facsimile: (407) 244-4419  
 ARCHITECTURE  
 ENGINEERING  
 21430 Palm Beach Blvd  
 Avon, FL 32820  
 Phone: (407) 938-8828  
 Facsimile: (321) 938-8828