

Luminaire Schedule							
Symbol	Qty	Label	Arrangement	LMF	Lum. Lumens	Lum. Watts	Part Number
◆	4	P2	2 @ 90 DEGREES	1.000	22330	166	OSQ-A-NM-4ME-T-57K-UL-BZ + OSQ-B-AABZ



Calculation Summary (Footcandles calculated using initial lumen values @ 25°C)						
Label	Units	Avg	Max	Min	Avg/Min	Max/Min
CalcPts_1	Fc	3.68	8.1	1.0	3.68	8.10

Fixture Mounting Height: 27' AFG (25' Pole + 2.0' Base)

POLE SCHEDULE:
 (4) CL-SSP-4011-25-OT-BZ (25' x 4" STEEL SQUARE POLE, 11ga)
 (4) PB-2A4 DOUBLE TENON
 (8) OSQ-B-AABZ (Adjustable Arm Mount)

PROPOSED POLES MEET 100 MPH SUSTAINED WINDS

***CUSTOMER TO VERIFY MOUNTING, VOLTAGE, AND COLOR PRIOR TO PLACING ORDER

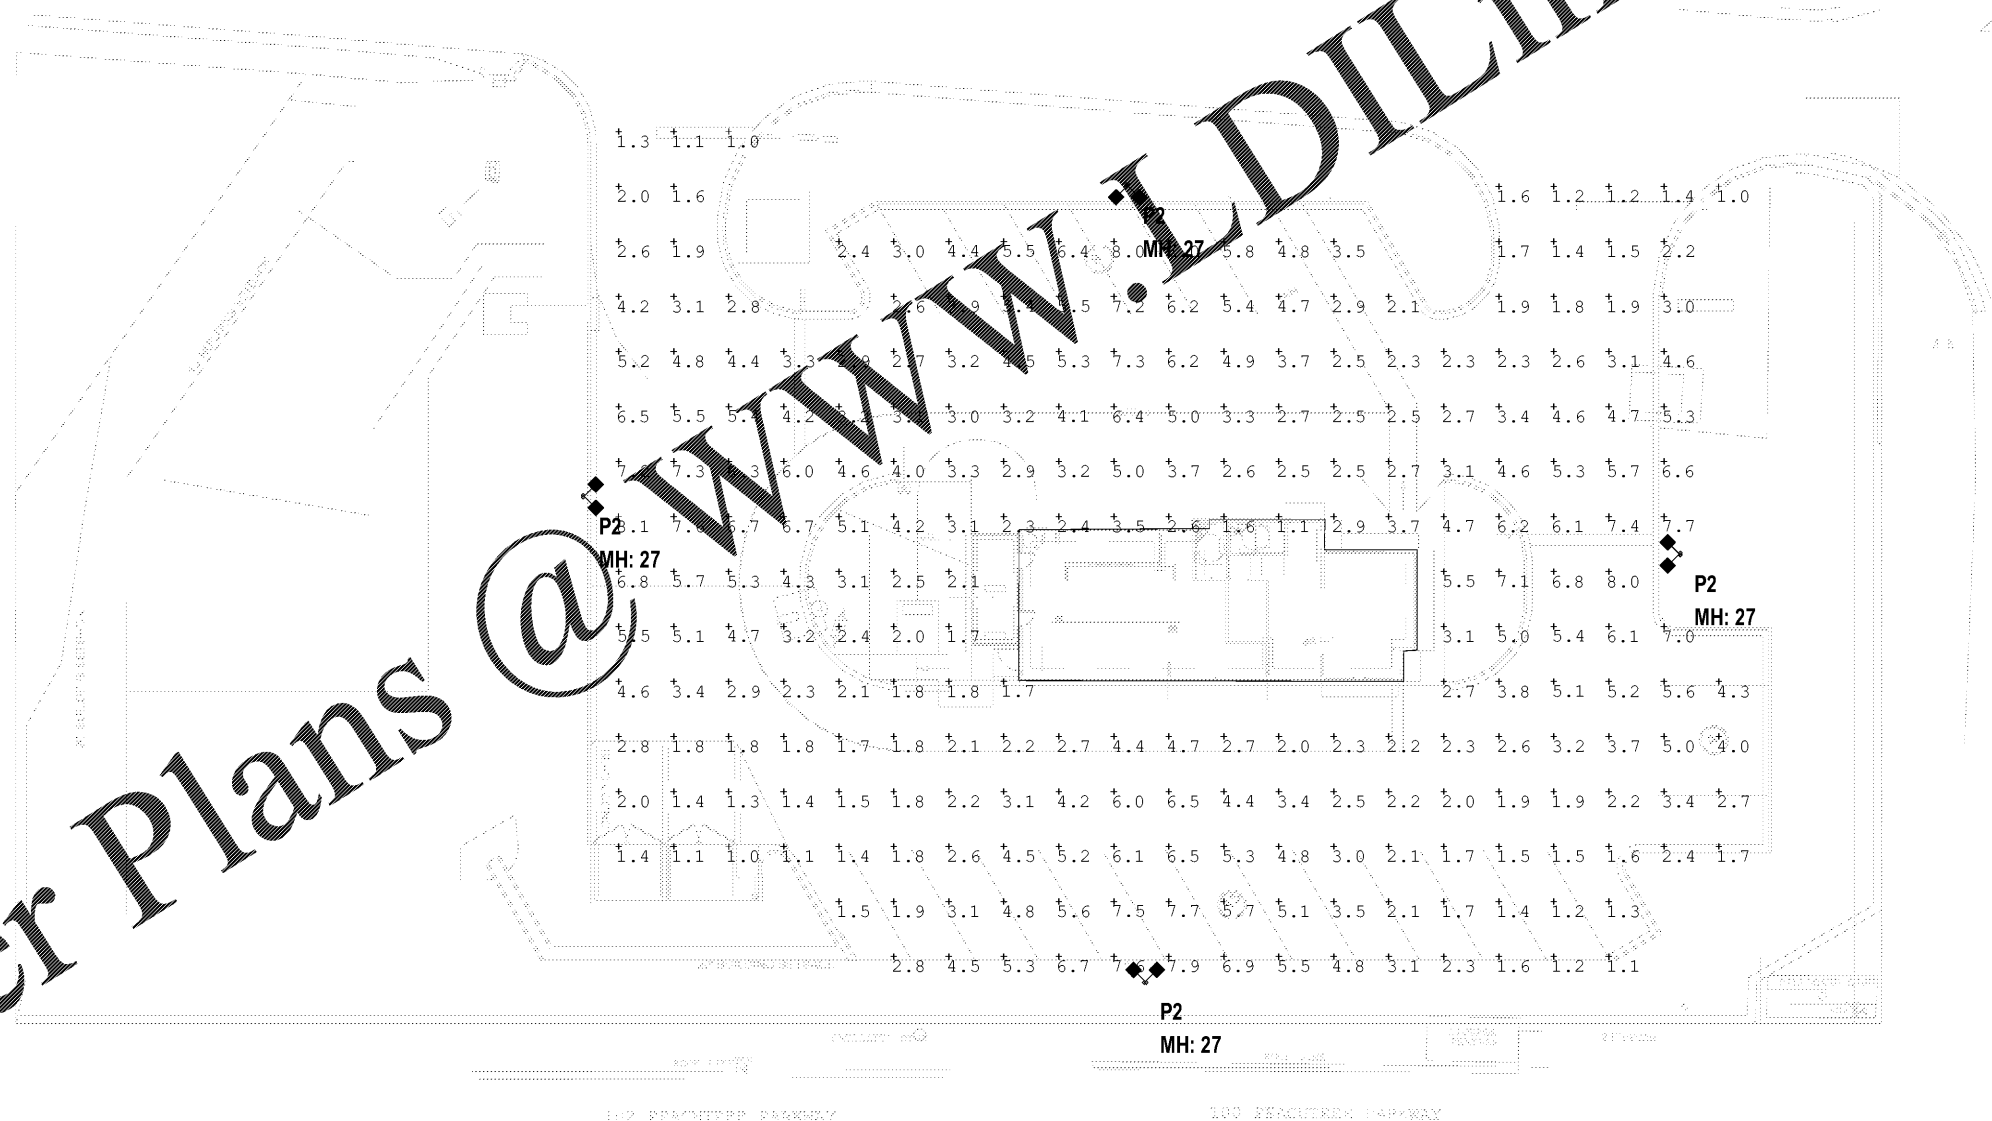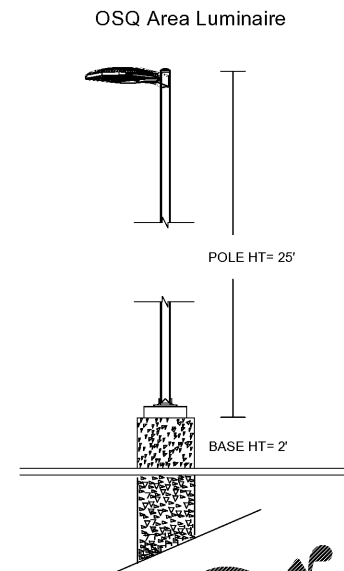

Order Plans @ www.WLDIline.com

ARCHITECTURE
ENGINEERING

LIS

ARCHITECT ENGINEER
LAND INVESTMENT SERVICES, LLC

2160 Palm Beach Blvd
Apt. FL 33500
Orlando, FL 32805
Phone: (329) 983-8829
Facsimile: (329) 983-8829

CLIENT NAME
SOUTHEASTERN RETAIL DEVELOPMENT, LLC
BLDG M-1, UNIT Z31
2050 COUNTY ROAD 30A
SANTA ROSA BEACH, FL 32459

PROJECT NAME
POPEYES
PLK 1930-28-DL SAILORMEN
501 N HWY 49
BRYON, GA 31088

SEAL

ROBERT W. CASE
GEORGIA PE #020594

RELEASE	DATE
1	
2	
3	
4	
5	
6	

PROJECT NO.
2020-085

ISSUE DATE
05/07/20

DRAWN _____ CHECKED _____
CS

SHEET NO.
SL1
SITE LIGHTING PLAN



LIS EXPRESSLY RESERVES ITS COPYRIGHT AND ALL OTHER PROPERTY RIGHTS TO THESE DOCUMENTS AND THEIR DESIGN. HENCE, THEY ARE NOT TO BE REPRODUCED.