


**GENERAL NOTES:**

1. COORDINATE ALL MECHANICAL CONSTRUCTION WITH OTHER TRADES TO AVOID CONFLICTS.
2. DUCT SIZES INDICATED ARE NET FREE AREA.
3. BALANCE SUPPLY AIR DEVICES TO QUANTITIES SHOWN ON PLAN.
4. OA INTAKE SHALL BE MIN 10'-0" FROM KITCHEN HOOD EXHAUST, RESTROOM EXHAUST, GAS VENT (FLUE), OR PLUMBING VENT TERMINATION, INCLUDING THOSE OF ADJACENT TENANTS (CONTRACTOR TO FIELD VERIFY).

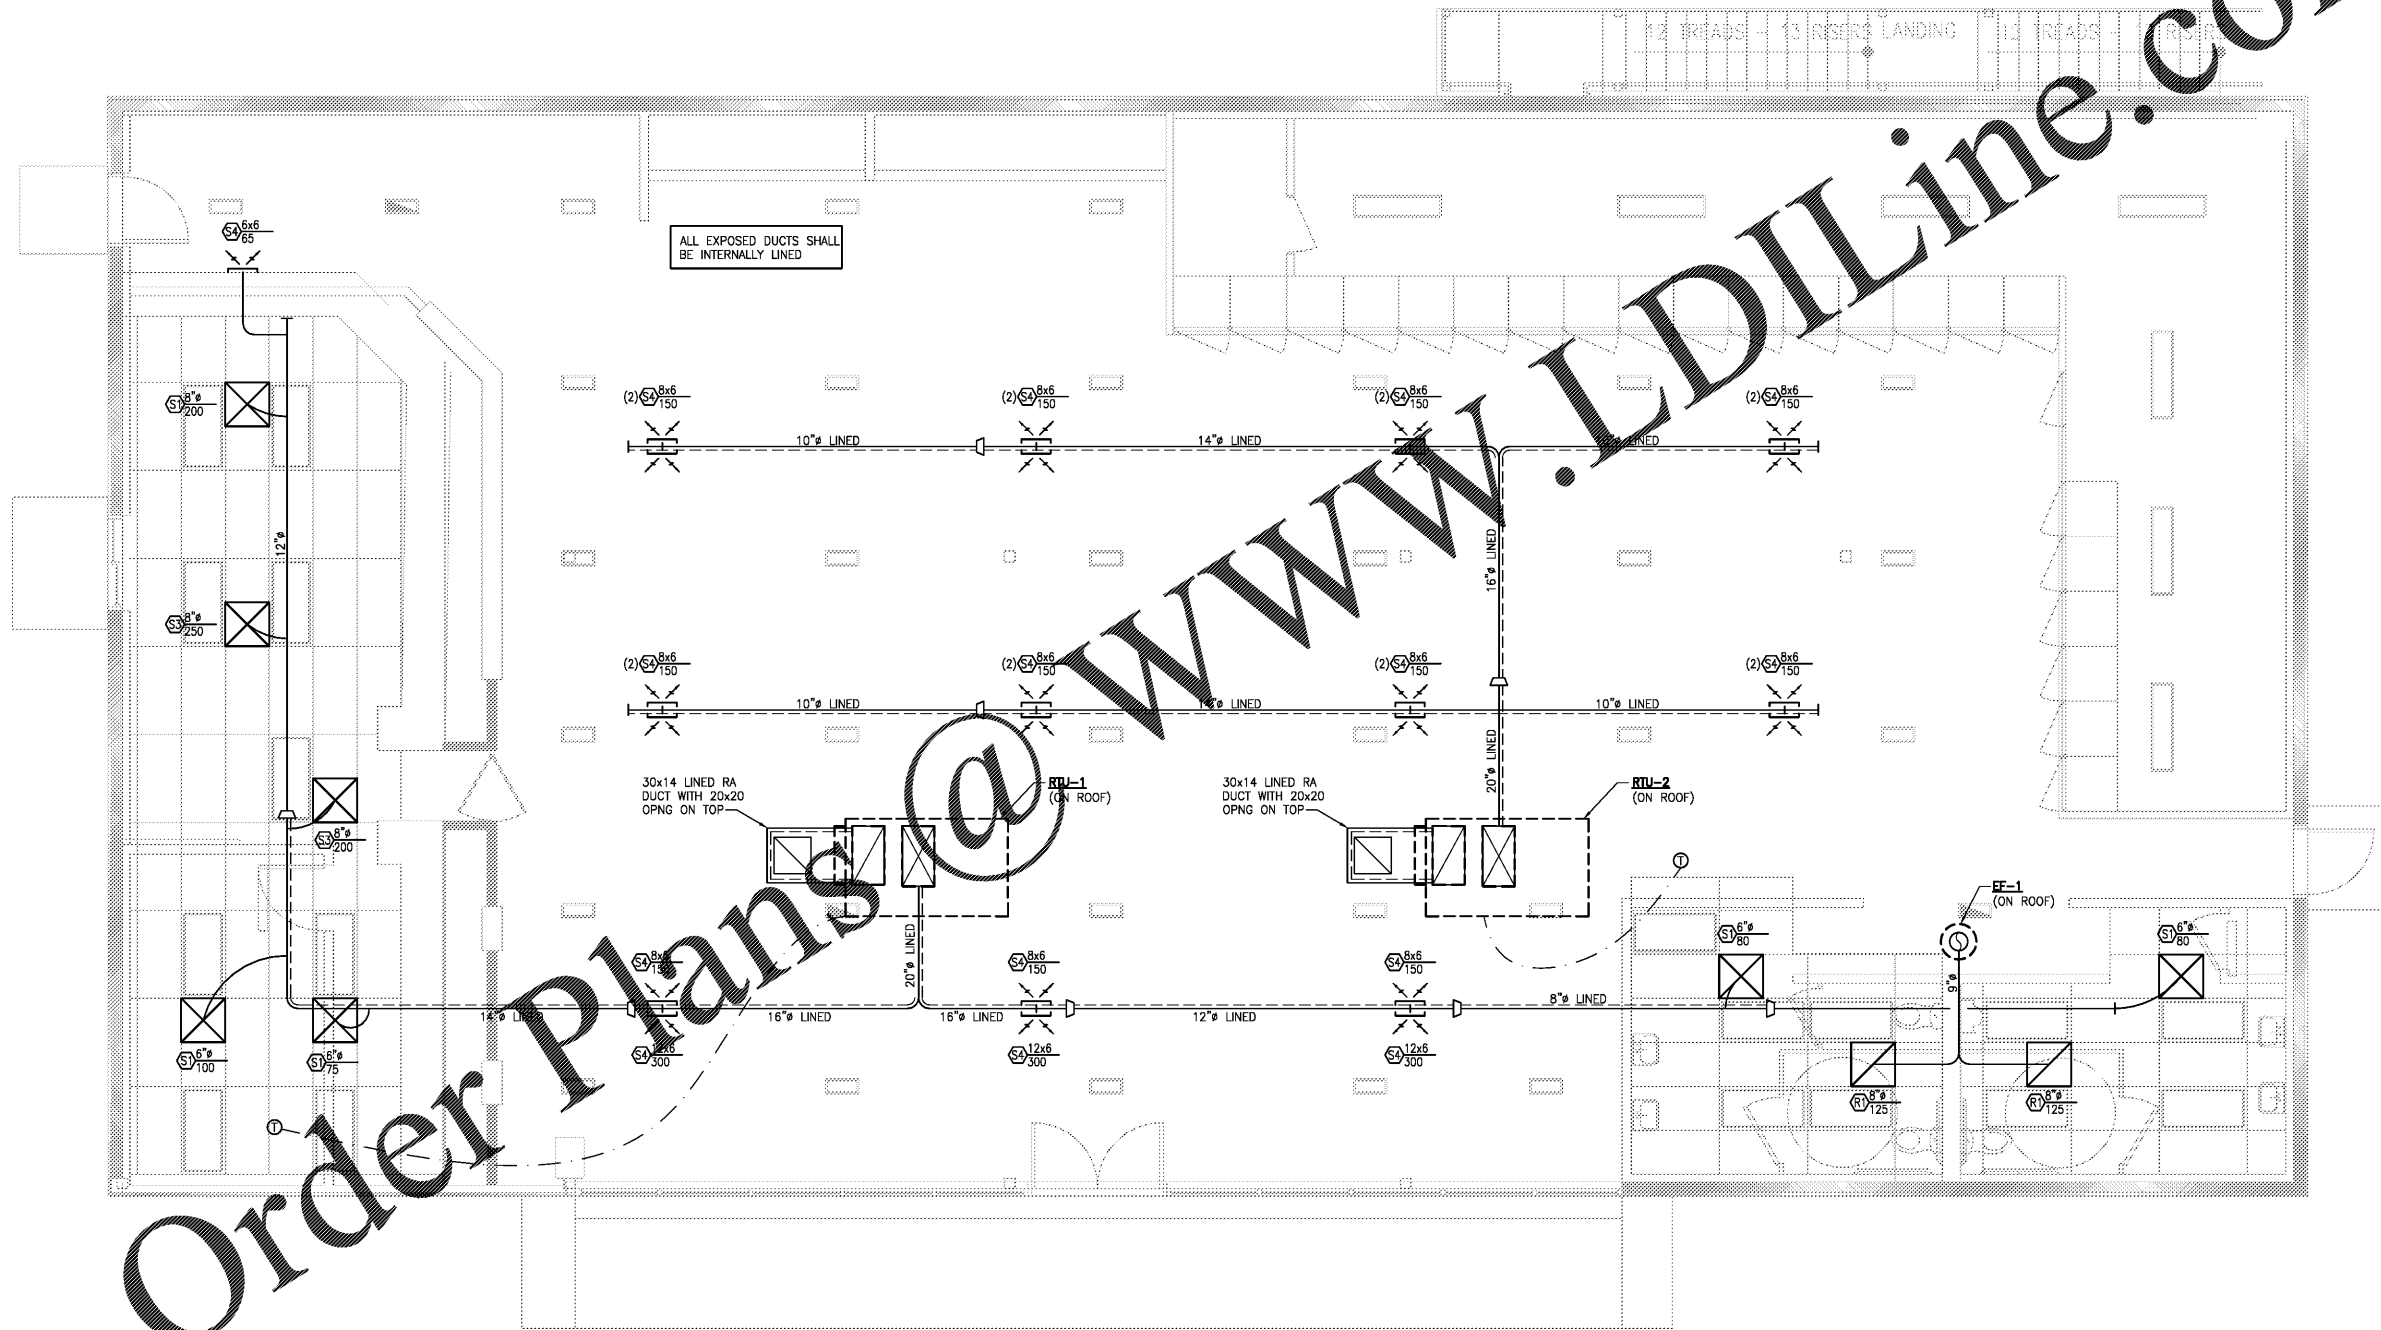

1 HVAC PLAN  
M-1.1 SCALE: 1/4" = 1'-0"



DATE: 06/18/20	REVISIONS:
DESIGNER: [Signature]	
DRAWN BY: [Signature]	
CHECKED BY: [Signature]	
DATE: 06/18/20	
PROJECT NO.:	
DRAWING NO.:	M-1.1
CLIENT:	MARKET HVAC PLAN
PROJECT:	WILD WOLF - COMMERCIAL DEVELOPMENT BOYD MORRIS ROAD & GA HWY 293 SPUR BARTOW COUNTY, GEORGIA 30120
GENERAL CONTRACTOR:	BLACKWATER CONSTRUCTION 2100 SHELLETT BLVD - SUITE 400 - DULUTH, GEORGIA 30097 PHONE: 404-848-3550 FAX: 404-848-3550 WWW.BLACKWATER.COM
ENGINEERING CONSULTANT:	GRAY 1827 POWER PERRY BLVD ATLANTA, GEORGIA 30339 PHONE: (770) 855-8623