


**GENERAL NOTES:**

1. COORDINATE ALL MECHANICAL CONSTRUCTION WITH OTHER TRADES TO AVOID CONFLICTS.
2. DUCT SIZES INDICATED ARE NET FREE AREA.
3. BALANCE SUPPLY AIR DEVICES TO QUANTITIES SHOWN ON PLAN.
4. OA INTAKE SHALL BE MIN 10'-0" FROM KITCHEN HOOD EXHAUST, RESTROOM EXHAUST, GAS VENT (FLUE), OR PLUMBING VENT TERMINATION, INCLUDING THOSE OF ADJACENT TENANTS (CONTRACTOR TO FIELD VERIFY).

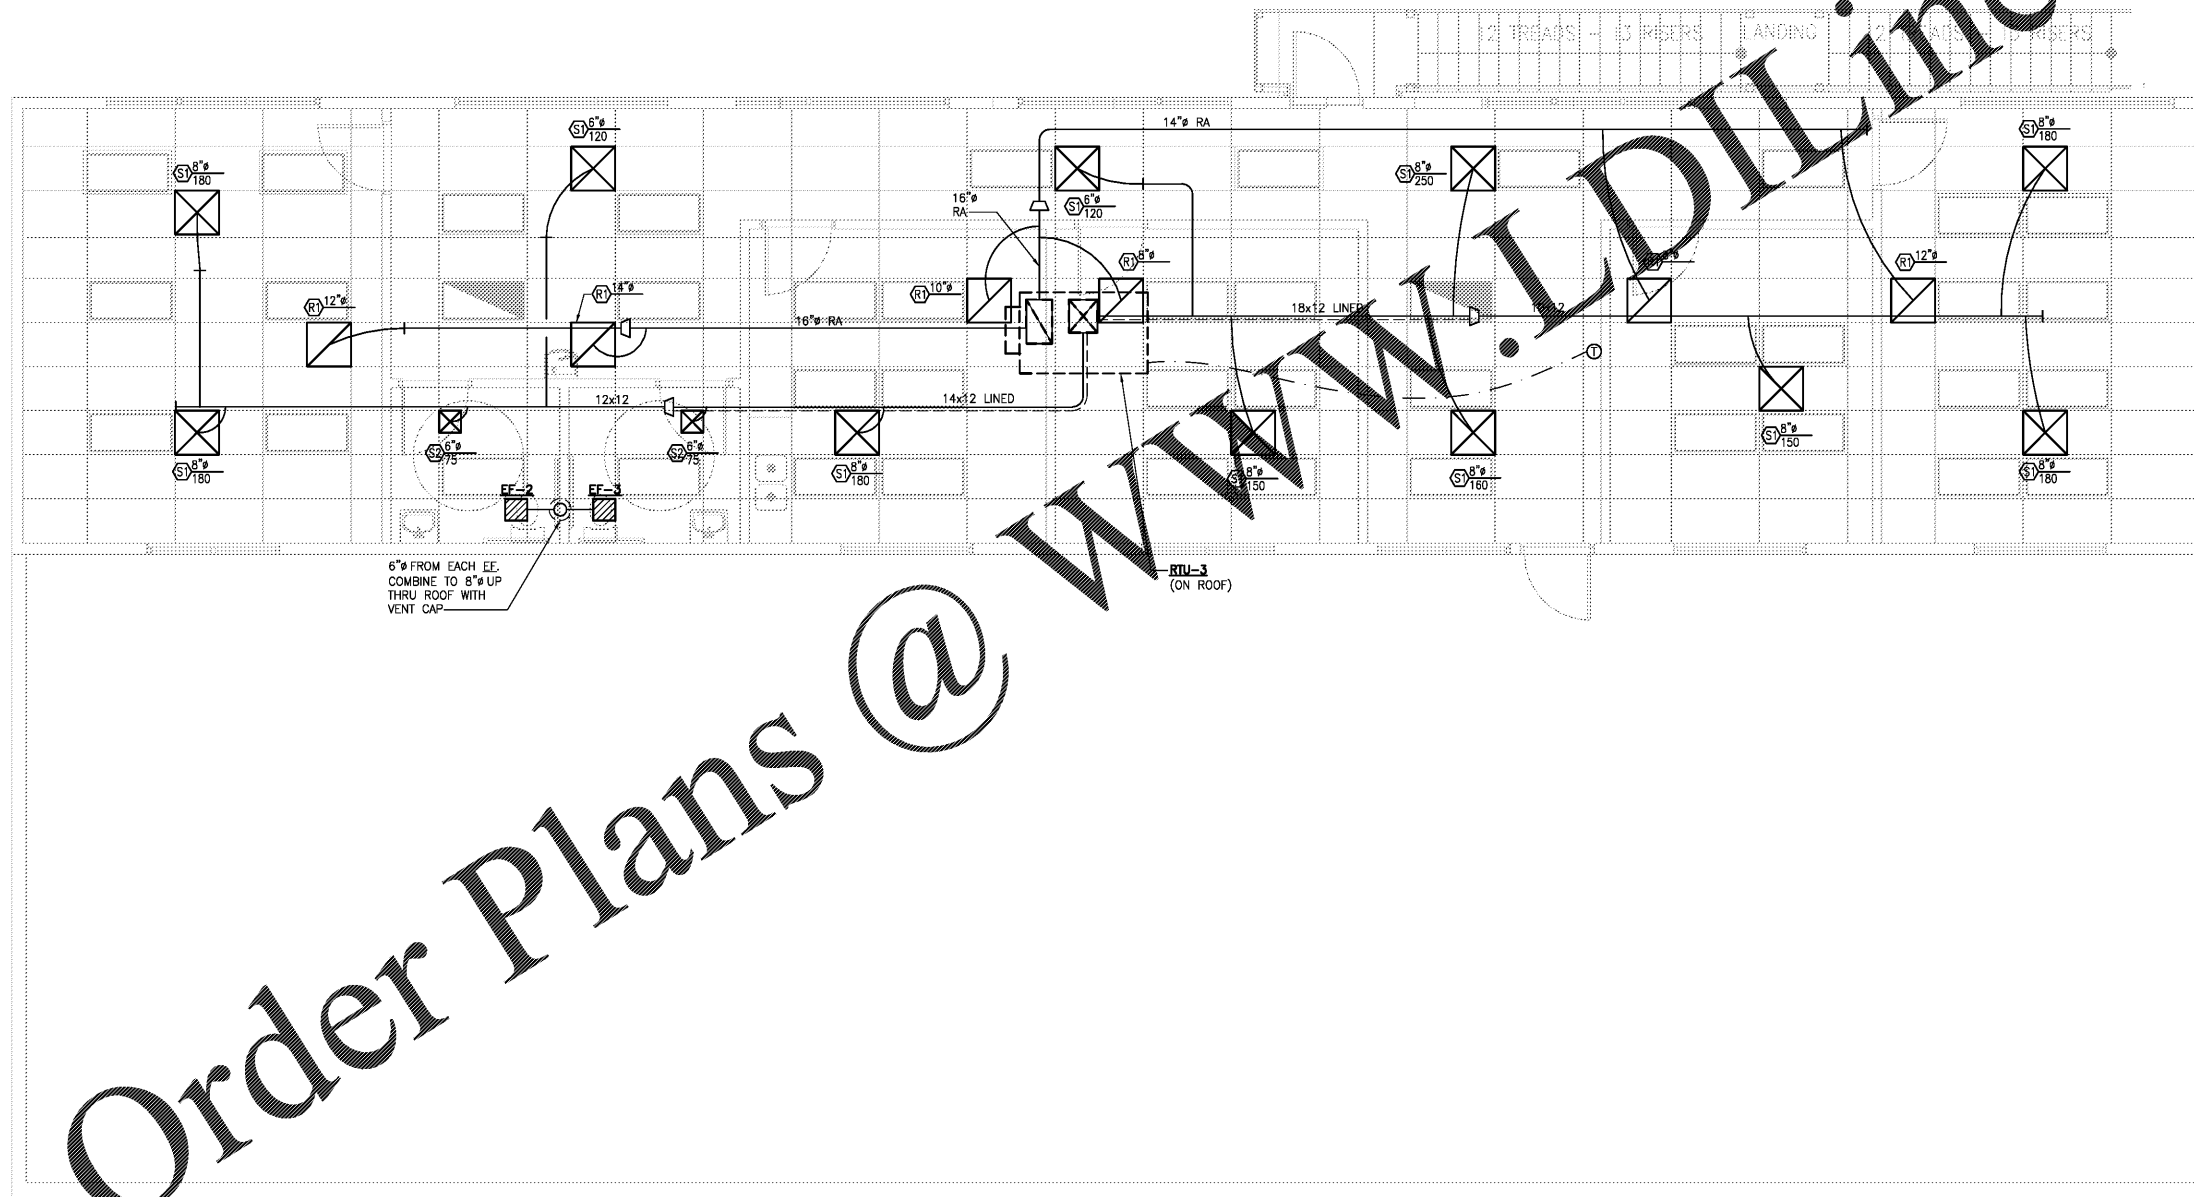

Order Plans @

1  
M-2.1 2ND FLOOR HVAC PLAN  
SCALE: 1/4" = 1'-0"



DATE	06/18/20
BY	
CHECKED	
APPROVED	

engineering consultant  
**GRAY**  
 Gray Group Consulting Engineers, Inc.  
 1827 Powers Ferry Road  
 Building 20, Suite 100  
 Atlanta, Georgia 30339  
 Phone: (770) 885-8833  
 Fax: (770) 885-8833

general contractor  
**BLACKWATER CONSTRUCTION**  
 2100 SHELLEE BLVD - SUITE 400 - DULUTH, GEORGIA 30097  
 PHONE: 404-848-3500 FAX: 404-848-3500  
 WWW.BLACKWATERCON.COM

SEAL

HVAC FIRST FLOOR PLAN  
 WILD WOLF - COMMERCIAL DEVELOPMENT  
 BOYD MORRIS ROAD & GA HWY 293 SPUR  
 BARTOW COUNTY, GEORGIA 30120

DRAWING NO.  
**M-2.1**

DATE PLOTTED: 06/18/20 10:58 AM