

KEY NOTES


- 1 CONSULT OWNER AND ARCHITECT FOR ALL LIGHT FIXTURES SPECIFICATIONS AND LOCATIONS.
- 2 INTERLOCK NEW EXHAUST FAN WITH NEW LIGHT SWITCH. NEW EXHAUST FAN SHALL BE FED BY CIRCUIT SERVING RESTROOM LIGHT FIXTURES.
- 3 CONNECT NIGHT LIGHTS, EMERGENCY LIGHTS/EXIT SIGNS AHEAD OF SWITCH.
- 4 TIME SWITCH SHALL FUNCTION A SCHEDULED BASIS USING TIME-OF-DAY WITH AN INDEPENDENT PROGRAM SCHEDULE THAT CONTROLS THE INTERIOR LIGHTING.
- 5 THE LIGHT SWITCH HEIGHT INCLUDING TOP OF COVER PLATE TO BE BELOW 4' AFF. COORDINATE SWITCHES WITH CHAIR RAILS, TRANSITION BETWEEN TILED AND UNTILED WALL SURFACE, COUNTERS/BACKSPASHES, ETC.
- 6 PROVIDE OCCUPANCY SENSORS AS SHOWN TO CIRCUIT SERVING THE LIGHTING IN THE AREA. FIELD COORDINATE EXACT LOCATION AND POWER PACK AS PER MANUFACTURER RECOMMENDATIONS. OCCUPANCY SENSORS WILL AUTOMATICALLY TURN OFF LIGHTS WITHIN 30 MINUTES OF ALL OCCUPANTS LEAVING THE SPACE.
- 7 ALL SWITCHES SHALL HAVE MOMENTARY TYPE CONTACTS TO OPERATE WITH OCCUPANCY SENSORS.
- 8 EXTERIOR LIGHTS SHALL BE CONTROLLED BY PHOTOCELL. CONTRACTOR SHALL FIELD LOCATE PHOTOCELL PER MANUFACTURER RECOMMENDATION AND FIELD LOCATE EXTERIOR LIGHT FIXTURES.
- 9 PROVIDE NEW LIGHT FIXTURES FOR BEER COOLER. CONSULT OWNER AND ARCHITECT FOR LIGHT FIXTURE SPECIFICATION AND LOCATION.

10 DAYLIGHT RESPONSIVE CONTROL SHALL NOT BE REQUIRED DUE TO PRIMARY SIDE-LIGHTED AREA IS LESS THAN 150W.

GENERAL NOTES

1. CONTRACTOR SHALL COORDINATE ALL ELECTRICAL CONSTRUCTION WITH OTHER TRADES TO AVOID CONFLICT.
2. CONTRACTOR SHALL VERIFY THERE IS NO OVERLOADING OF BRANCH CIRCUITS AND/OR PANEL BOARDS REGARDLESS OF CIRCUITING INDICATED.

LIGHTING LEGEND				LIGHTING LEGEND			
MARK	SYMBOL	DESCRIPTION	COMMENTS	MARK	SYMBOL	DESCRIPTION	COMMENTS
A		2' x 4' LED PANEL ; LITHONIA LIGHTING 2ES24; 30W LED OR EQUIVALENT	RECESSED	E		LITHONIA LIGHTING LHOM LED; EMERGENCY EXIT SIGN; 2 HEADS; 1.5W EACH; LED FACE 4.3W OR EQUIVALENT	MOUNT ON CEILING OR WALL
B		LED PENDANT; 25W MAX BY OWNER/ARCHITECT	MOUNT ON CEILING	E2		LITHONIA LIGHTING ELM2; EMERGENCY LIGHTING; 2 HEADS; 1.5W EACH OR EQUIVALENT	MOUNT ON WALL
B-NL		LED PENDANT NIGHT LIGHT; 25W MAX BY OWNER/ARCHITECT	MOUNT ON CEILING	E3		LITHONIA LIGHTING ELA LED; REMOTE HEAD; 1W LED	MOUNT ON EXTERIOR WALL AND/OR DOOR LOCATIONS
C		LITHONIA LIGHTING CPANL; 2' x 4' 60LM-35K LED FLAT PANEL OR EQUIVALENT	MOUNT ON CEILING	E4		LITHONIA LIGHTING WSR; 20W LED WALL LUMINAIRE WITH EMERGENCY BATTERY BACKUP OR EQUIVALENT	MOUNT ON WALL
D		COOLER LIGHTS BY OWNER/ARCHITECT	MOUNT IN COOLER	OS		OCCUPANCY SENSORS/DAYLIGHT RESPONSIVE CONTROL	

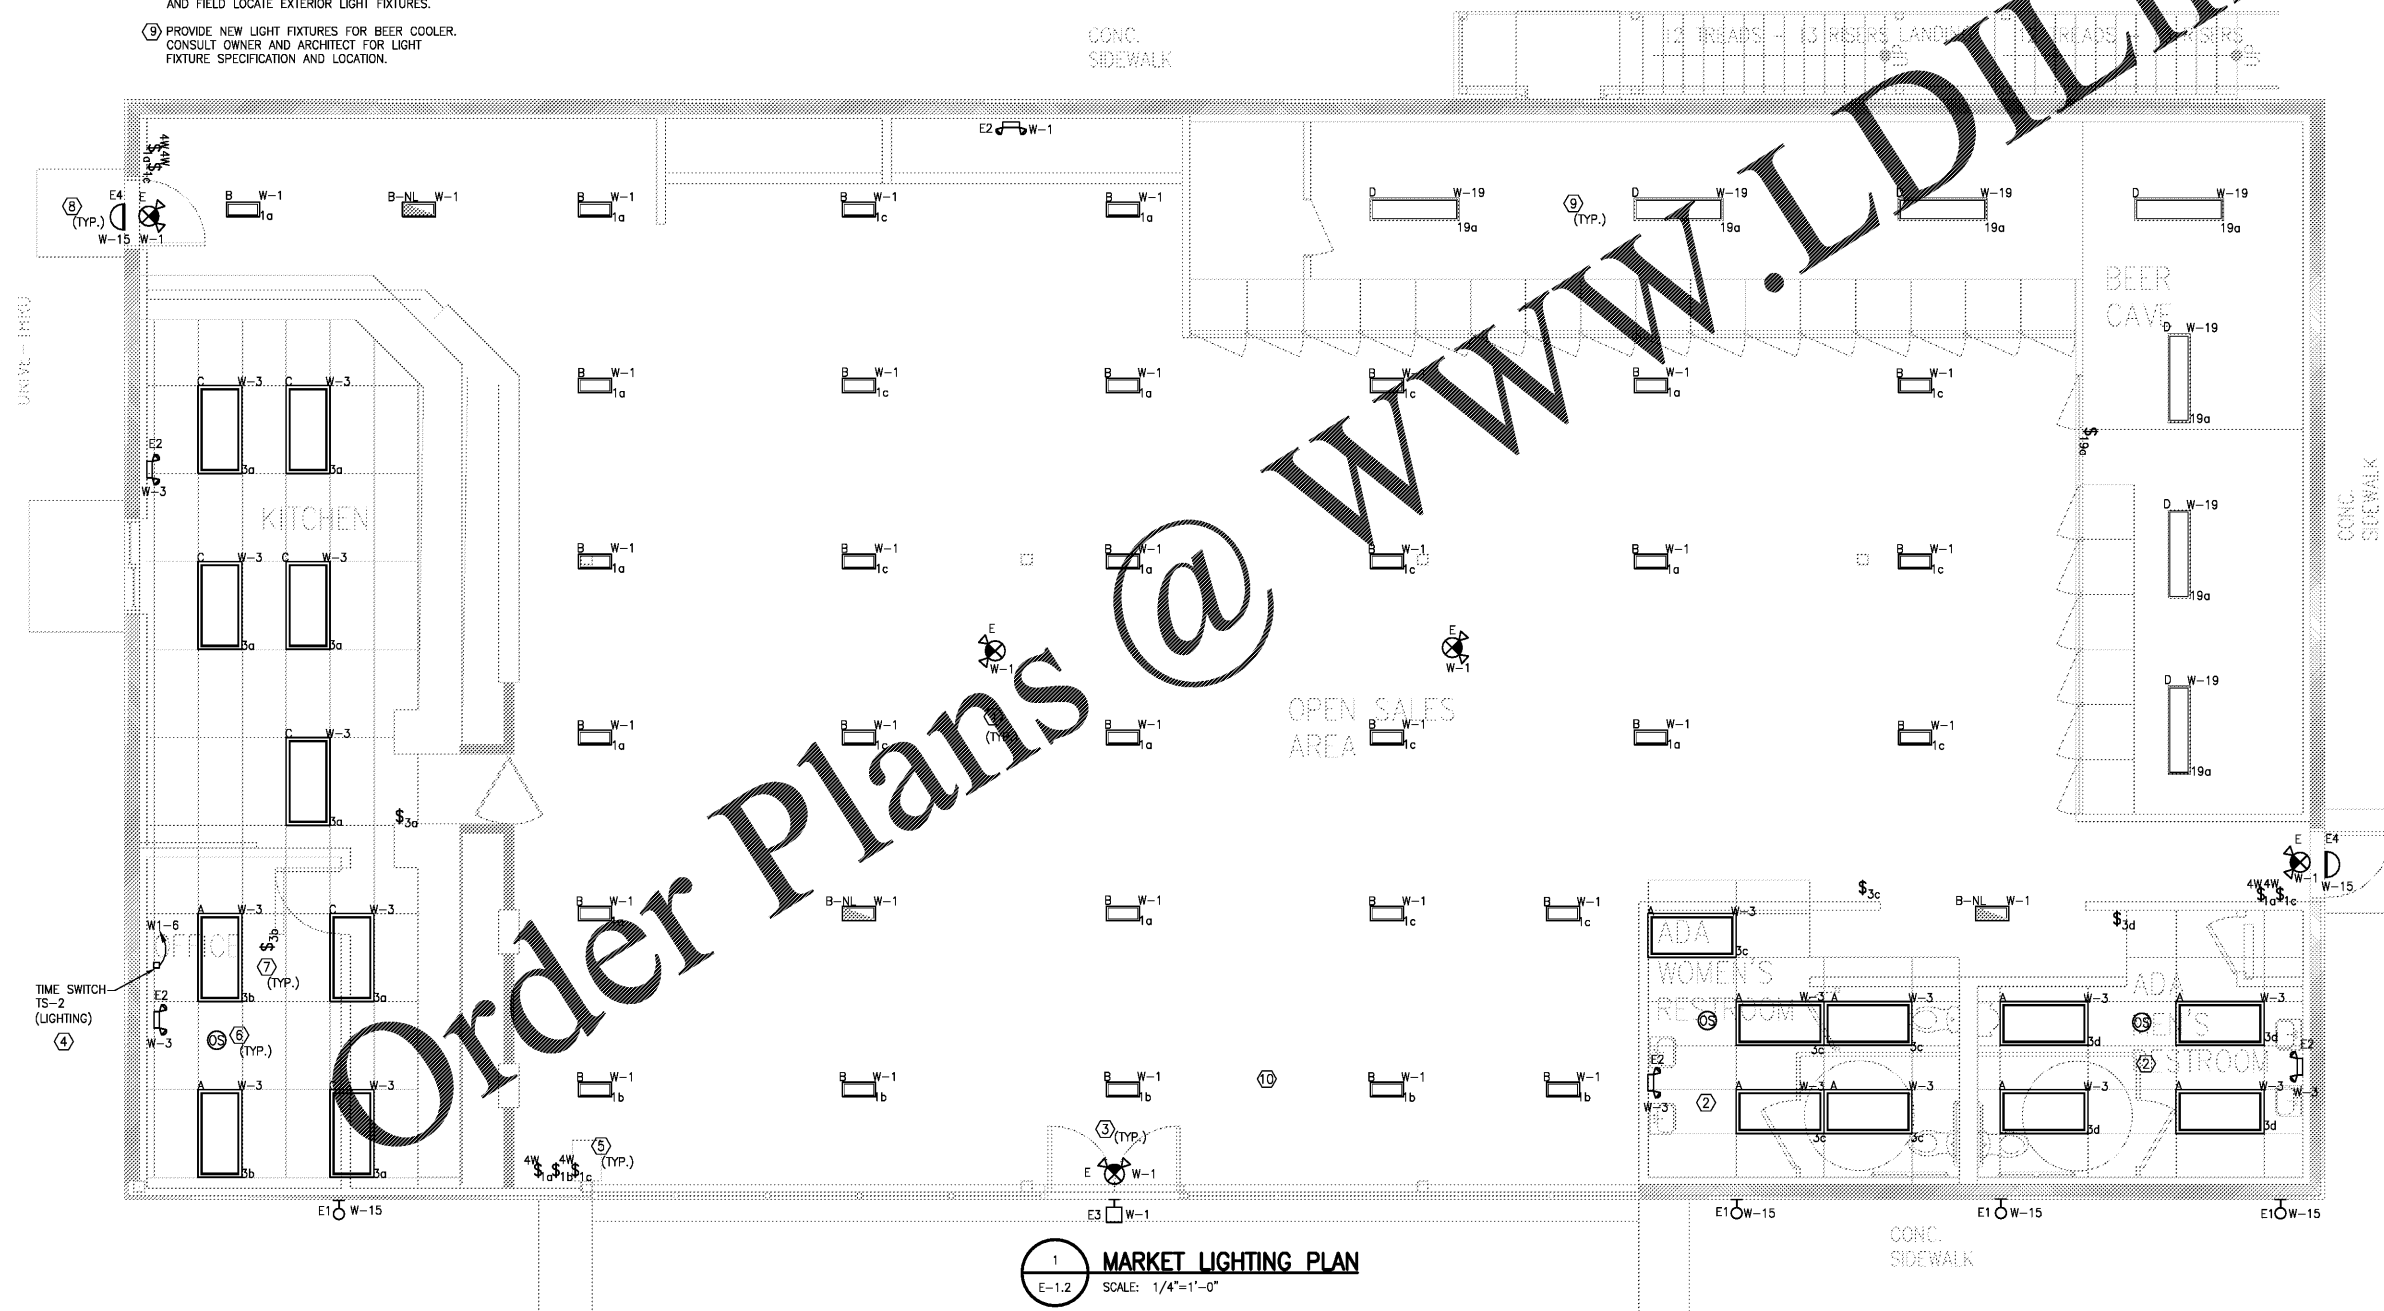

1 MARKET LIGHTING PLAN
E-1.2 SCALE: 1/4"=1'-0"



engineering consultant
CRAY
 1827 Powers Ferry Road
 Atlanta, Georgia 30329
 Fax: (770) 955-9523

general contractor
BLACKWATER CONSTRUCTION
 2100 SHELLETT BLVD - SUITE 400 - DULUTH, GEORGIA 30097
 Voice: 404-546-3505 E-Mail: info@blackwater.com www.blackwater.com

MARKET LIGHTING PLAN
 WILD WOLF - COMMERCIAL DEVELOPMENT
 BOYD MORRIS ROAD & GA HWY 293 SPUR
 BARTOW COUNTY, GEORGIA 30120

DATE: 06/18/20
 DRAWING NO: E-1.2