


GENERAL NOTES

1. CONTRACTOR SHALL COORDINATE ALL ELECTRICAL CONSTRUCTION WITH OTHER TRADES TO AVOID CONFLICTS.
2. CONTRACTOR SHALL VERIFY THERE IS NO OVERLOADING OF BRANCH CIRCUITS AND/OR PANELBOARDS REGARDLESS OF CIRCUITRY INDICATED.
3. ALL OUTLETS TO BE INSTALLED AT 18" AFF ON CENTER UNLESS OTHERWISE NOTED OR INSTRUCTED BY OWNER/ARCHITECT.
4. CONDUITS BELOW SLAB SHALL BE PVC CONDUITS WITH METAL ELBOW. ENCLOSED IN WALL/CEILING CONDUITS SHALL BE METAL CONDUITS. ANY EXPOSED CONDUITS SHALL BE METAL CONDUITS ONLY. ENCLOSED IN CONCRETE CONDUITS SHALL BE PVC.
5. G.C. TO COORDINATE ALL POWER AND OTHER OUTLETS WITH ARCHITECTURAL PLANS AND ENGINEERING DRAWINGS.
6. ALL 120V, 208V, SINGLE PHASE, THREE PHASE, 15A AND 20A RECEPTACLES INSTALLED OUTDOORS, IN BATHROOMS, KITCHENS WITHIN 6 FEET OF A SINK, AND ON ROOFTOP AREAS SHALL HAVE GROUND-FAULT CIRCUIT INTERRUPTER PROTECTION.

KEY NOTES

- ① PROVIDE JUNCTION BOX FOR SIGNAGE. PROVIDE CONDUIT. CONTRACTOR TO FIELD LOCATE.
- ② CONTRACTOR TO PROVIDE 1" C FROM BUILDING TELEPHONE CABINET TO TELEPHONE BACKBOARD. FIELD LOCATE TELEPHONE BACKBOARD.
- ③ SHOW WINDOW RECEPTACLES SHALL BE SPACED AT NOT MORE THAN 12'-0" O.C. AND INSTALLED WITHIN 18" ABOVE TOP OF WINDOWS PER NEC 210.62..
- ④ CONTRACTOR SHALL FIELD LOCATE ELECTRICAL PANEL AS PER ELECTRICAL CODE ADOPTED BY THE AUTHORITY HAVING JURISDICTION.
- ⑤ TIME SWITCH SHALL FUNCTION A SCHEDULED BASIS USING TIME-OF-DAY WITH AN INDEPENDENT PROGRAM SCHEDULE THAT CONTROLS THE SIGNAGE.
- ⑥ CONTRACTORS SHALL FIELD LOCATE ALL RECEPTACLES AND TELEPHONE/DATA OUTLETS.

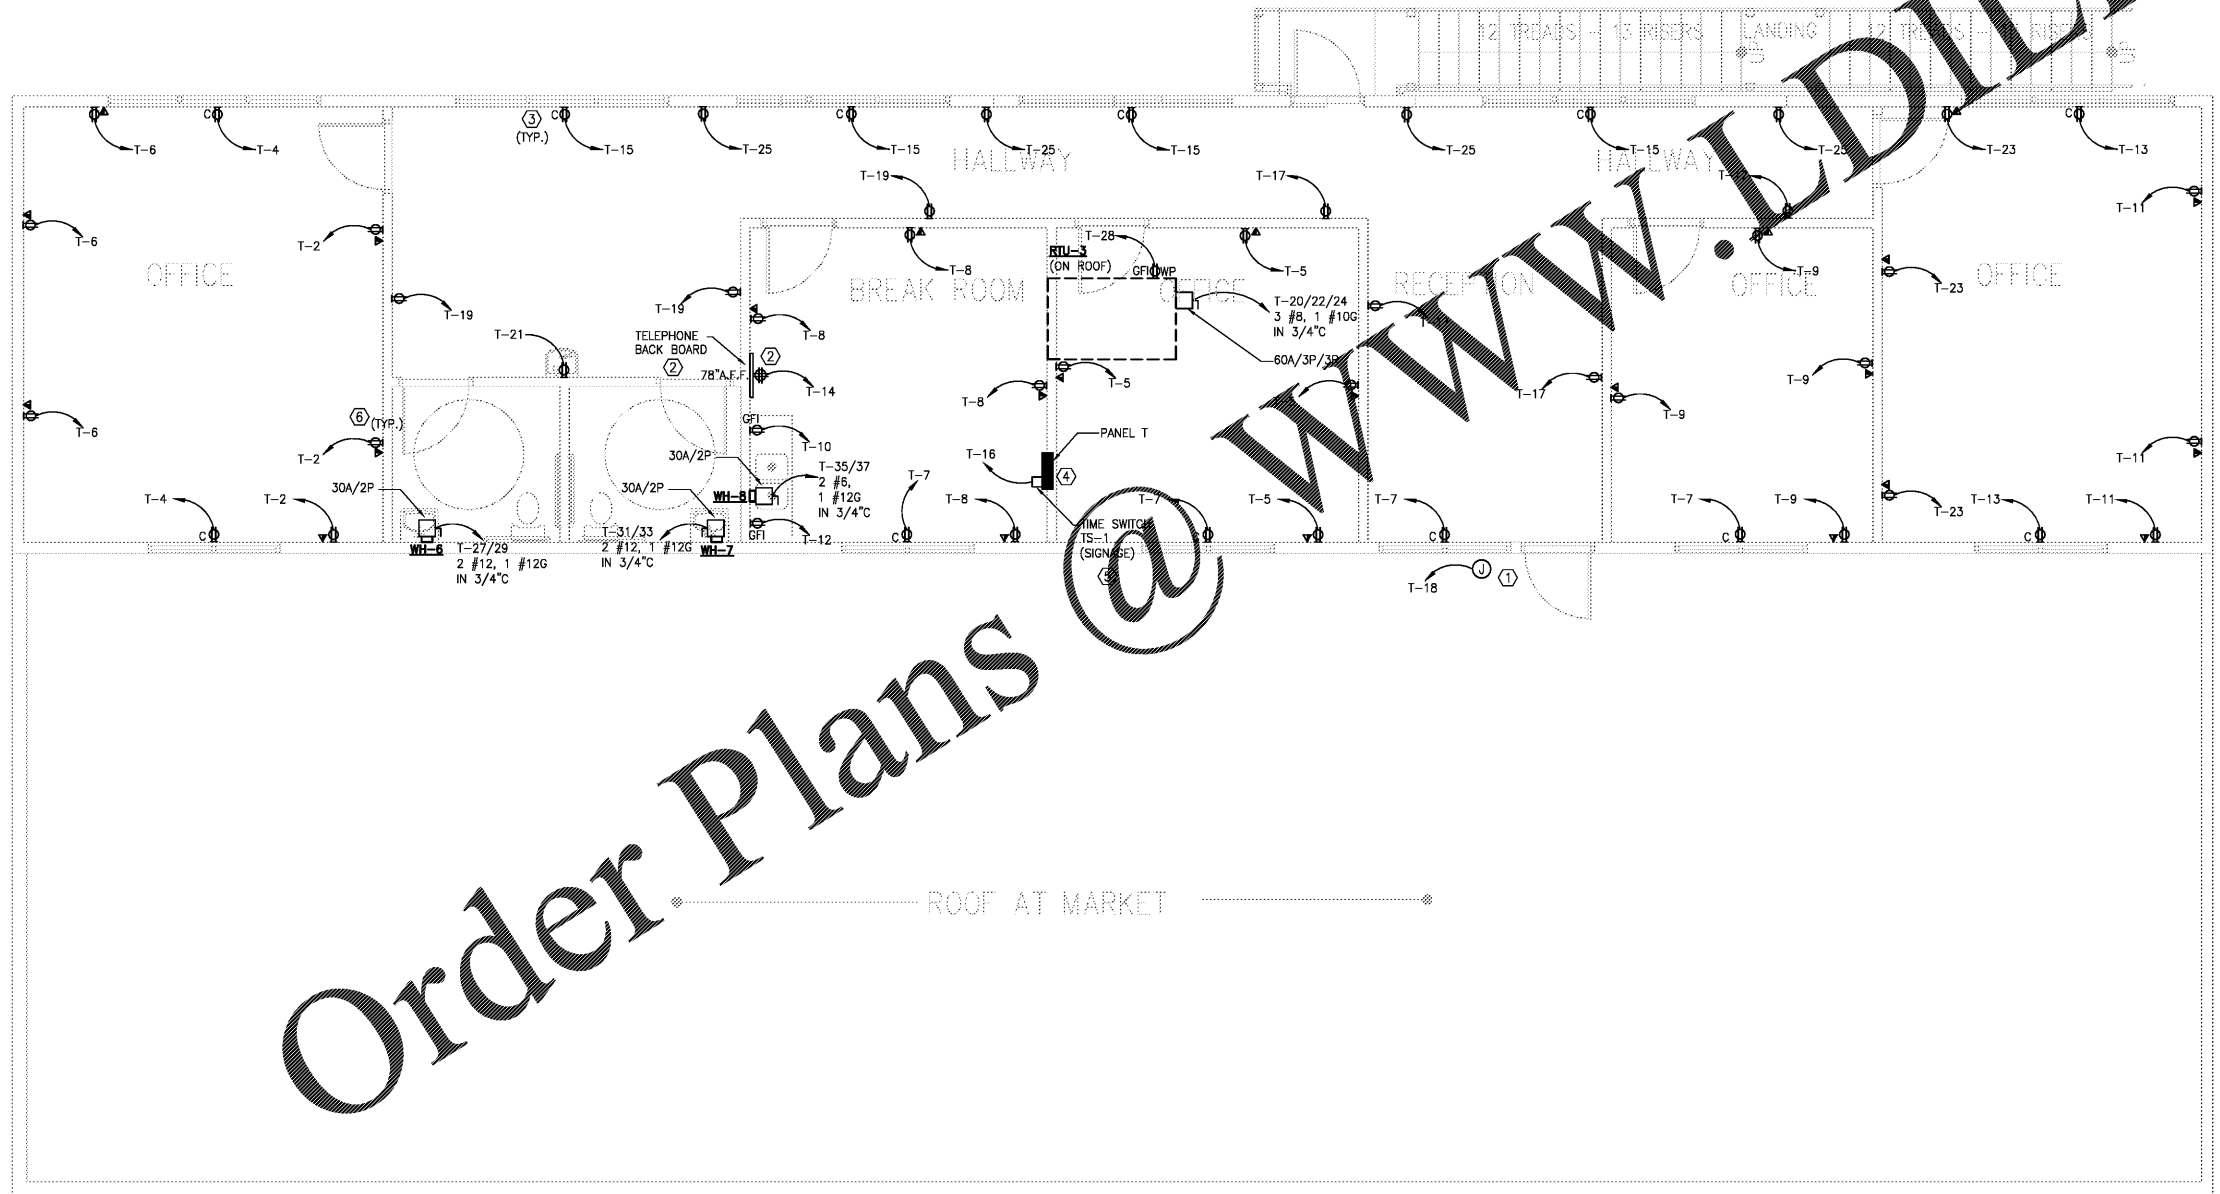

Order Plans @ WWW.LDILine.com

1 2ND FLOOR POWER PLAN
E-2.1 SCALE: 1/4"=1'-0"



DATE: 06/18/20	REVISIONS:
DESIGNER: ASHIM K. RAY	DATE: 06/18/20
CHECKED BY: ASHIM K. RAY	DATE: 06/18/20
DRAWN BY: ASHIM K. RAY	DATE: 06/18/20
SCALE: 1/4"=1'-0"	DATE: 06/18/20
PROJECT NO.:	DATE: 06/18/20
DRAWING NO.:	DATE: 06/18/20
engineering consultant LDI LD Inc. Group Consulting Engineers, Inc. 1827 Powers Ferry Road Building 20, Suite 100 Atlanta, Georgia 30339 Tel: (770) 952-8523 Fax: (770) 952-8523	
general contractor BLACKWATER CONSTRUCTION 2100 SHELLETT BLVD - SUITE 400 - DULUTH, GEORGIA 30097 VOICE: 404-546-3500 E-MAIL: info@blackwater.com WWW.BLACKWATER.COM	
SEAL 2ND FLOOR POWER PLAN WILD WOLF-COMMERCIAL DEVELOPMENT BOYD MORRIS ROAD & GA HWY 293 SPUR BARTOW COUNTY, GEORGIA 30120	
E-2.1	