


KEY NOTES

- ① CONSULT OWNER AND ARCHITECT FOR ALL LIGHT FIXTURE SPECIFICATIONS AND LOCATIONS.
- ② INTERLOCK NEW EXHAUST FAN WITH NEW LIGHT SWITCH. NEW EXHAUST FAN SHALL BE FED BY CIRCUIT SERVING RESTROOM LIGHT FIXTURES.
- ③ CONNECT NIGHT LIGHTS, EMERGENCY LIGHTS/EXIT SIGNS AHEAD OF SWITCH.
- ④ AUTOMATIC DAYLIGHT RESPONSIVE CONTROL SHALL BE MANUALLY CALIBRATED, DIM LIGHT CONTINUOUSLY FROM FULL LIGHT OUTPUT TO 15 PERCENT OF FULL LIGHT POWER AND CAPABLE OF A COMPLETE SHUT OFF OF ALL CONTROLLED LIGHTS. CONTRACTOR SHALL FIELD LOCATE.
- ⑤ THE LIGHT SWITCH HEIGHT INCLUDING TOP OF COVER PLATE TO BE BELOW 4' AFF. COORDINATE SWITCHES WITH CHAIR RAILS, TRANSITION BETWEEN TILED AND UNTILED WALL SURFACE, COUNTERS/BACKSPASHES, ETC.
- ⑥ PROVIDE OCCUPANCY SENSORS AS SHOWN TO CIRCUIT SERVING THE LIGHTING IN THE AREA. FIELD COORDINATE EXACT LOCATION AND POWER PACK AS PER MANUFACTURER RECOMMENDATIONS. OCCUPANCY SENSORS WILL AUTOMATICALLY TURN OFF LIGHTS WITHIN 30 MINUTES OF ALL OCCUPANTS LEAVING THE SPACE.
- ⑦ ALL SWITCHES SHALL HAVE MOMENTARY TYPE CONTACTS TO OPERATE WITH OCCUPANCY SENSORS.
- ⑧ EXTERIOR LIGHTS SHALL BE CONTROLLED BY PHOTOCELL. CONTRACTOR SHALL FIELD LOCATE PHOTOCELL PER MANUFACTURER RECOMMENDATION AND FIELD LOCATE EXTERIOR LIGHT FIXTURES.

GENERAL NOTES

1. CONTRACTOR SHALL COORDINATE ALL ELECTRICAL CONSTRUCTION WITH OTHER TRADES TO AVOID CONFLICT.
2. CONTRACTOR SHALL VERIFY THERE IS NO OVERLOADING OF BRANCH CIRCUITS AND/OR PANEL BOARDS REGARDLESS OF CIRCUITING INDICATED.

LIGHTING LEGEND			
MARK	SYMBOL	DESCRIPTION	COMMENTS
A		2' x 4' LED PANEL ; LITHONIA LIGHTING 2ES24; 30W LED OR EQUIVALENT	RECESSED
A-NL		2' x 4' LED PANEL ; LITHONIA LIGHTING 2ES24; 30W LED OR EQUIVALENT; NIGHT LIGHT	RECESSED
E		LITHONIA LIGHTING LHPM LED; EMERGENCY EXIT SIGN; 2 HEADS; 1.5W EACH; LED FACE 4.3W OR EQUIVALENT	MOUNT ON CEILING OR WALL
E2		LITHONIA LIGHTING ELM2; EMERGENCY LIGHTING; 2 HEADS; 1.5W EACH OR EQUIVALENT	MOUNT ON WALL
E3		LITHONIA LIGHTING ELA LED; REMOTE HEAD; 1W LED	MOUNT ON EXTERIOR WALL AT DOOR LOCATIONS
E4		LITHONIA LIGHTING WSR; 20W LED; WALL SCONCE WITH EMERGENCY BATTERY BACKUP OR EQUIVALENT	MOUNT ON WALL
		OCCUPANCY SENSORS/DAYLIGHT RESPONSIVE CONTROL	

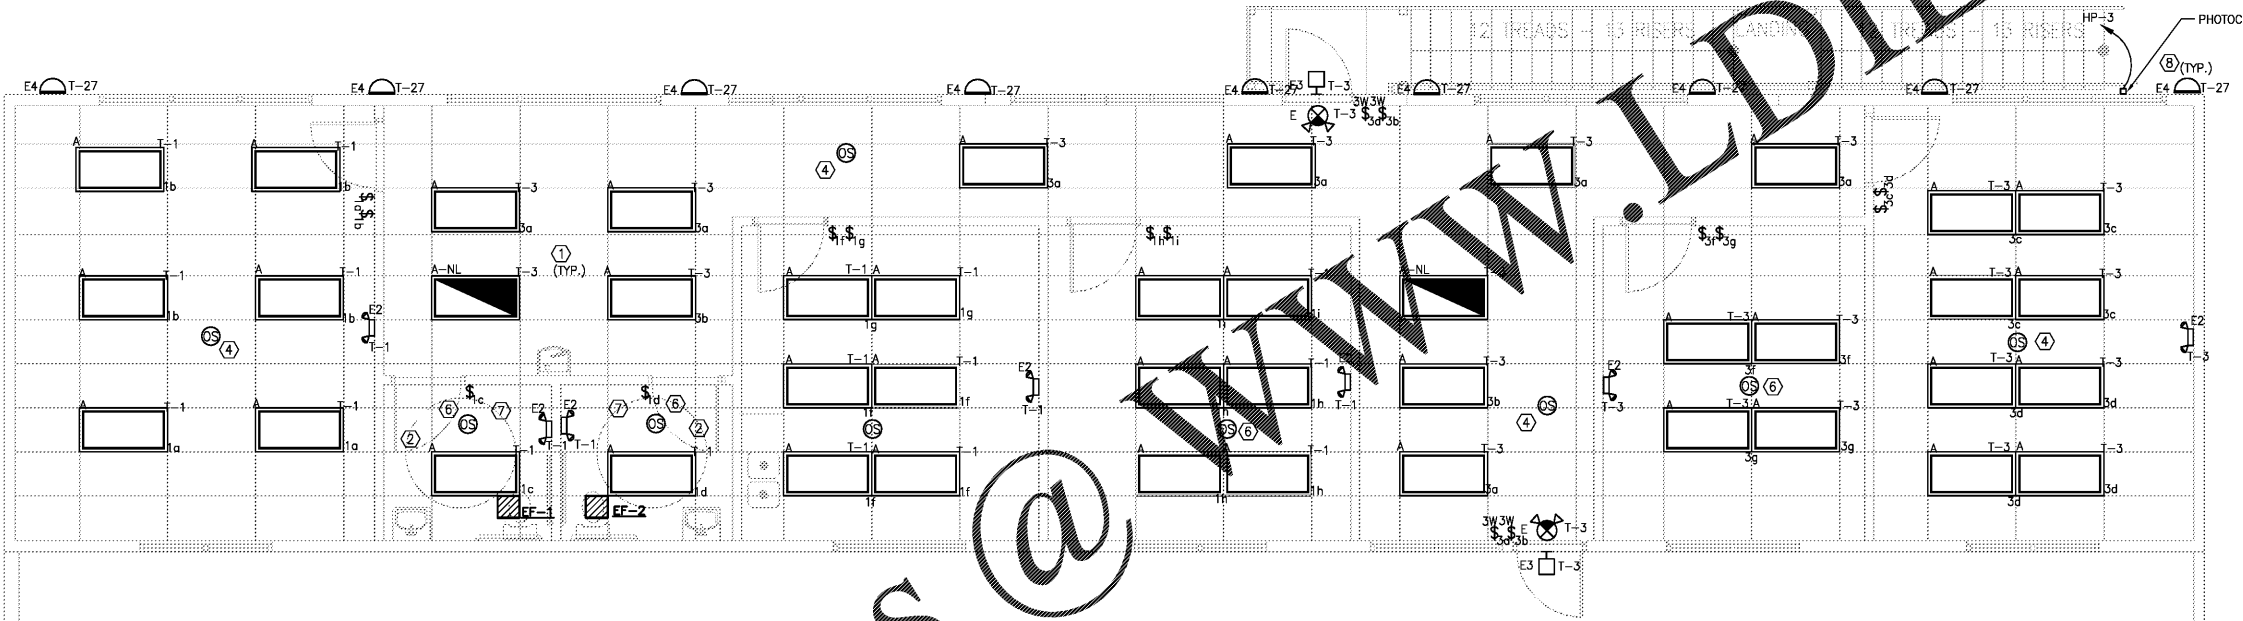

Order Plans @ www.lidilne.com

1 2ND FLOOR LIGHTING PLAN
E-2.2 SCALE: 1/4"=1'-0"



engineering consultant

CRAP

1845 Georgia Consulting Engineers, Inc.
1827 Powers Ferry Road
Building 20, Suite 100
Atlanta, Georgia 30329
Tel: (770) 952-8523
Fax: (770) 952-8523

general contractor

BLACKWATER CONSTRUCTION
2100 SHELLETT BLVD - SUITE 400 - DULUTH, GEORGIA 30097
VOICE: 404-542-3505 E-MAIL: info@blackwater.com www.blackwater.com

2ND FLOOR LIGHTING PLAN
WILD WOLF-COMMERCIAL DEVELOPMENT
BOYD MORRIS ROAD & GA HWY 293 SPUR
BARTOW COUNTY, GEORGIA 30120

DATE: 06/18/20

E-2.2