


GENERAL NOTES:

1. COORDINATE ALL MECHANICAL CONSTRUCTION WITH OTHER TRADES TO AVOID CONFLICTS.
2. DUCT SIZES INDICATED ARE NET FREE AREA.
3. BALANCE SUPPLY AIR DEVICES TO QUANTITIES SHOWN ON PLAN.
4. OA INTAKE SHALL BE MIN 10'-0" FROM KITCHEN HOOD EXHAUST, RESTROOM EXHAUST, GAS VENT (FLUE), OR PLUMBING VENT TERMINATION, INCLUDING THOSE OF ADJACENT TENANTS (CONTRACTOR TO FIELD VERIFY).

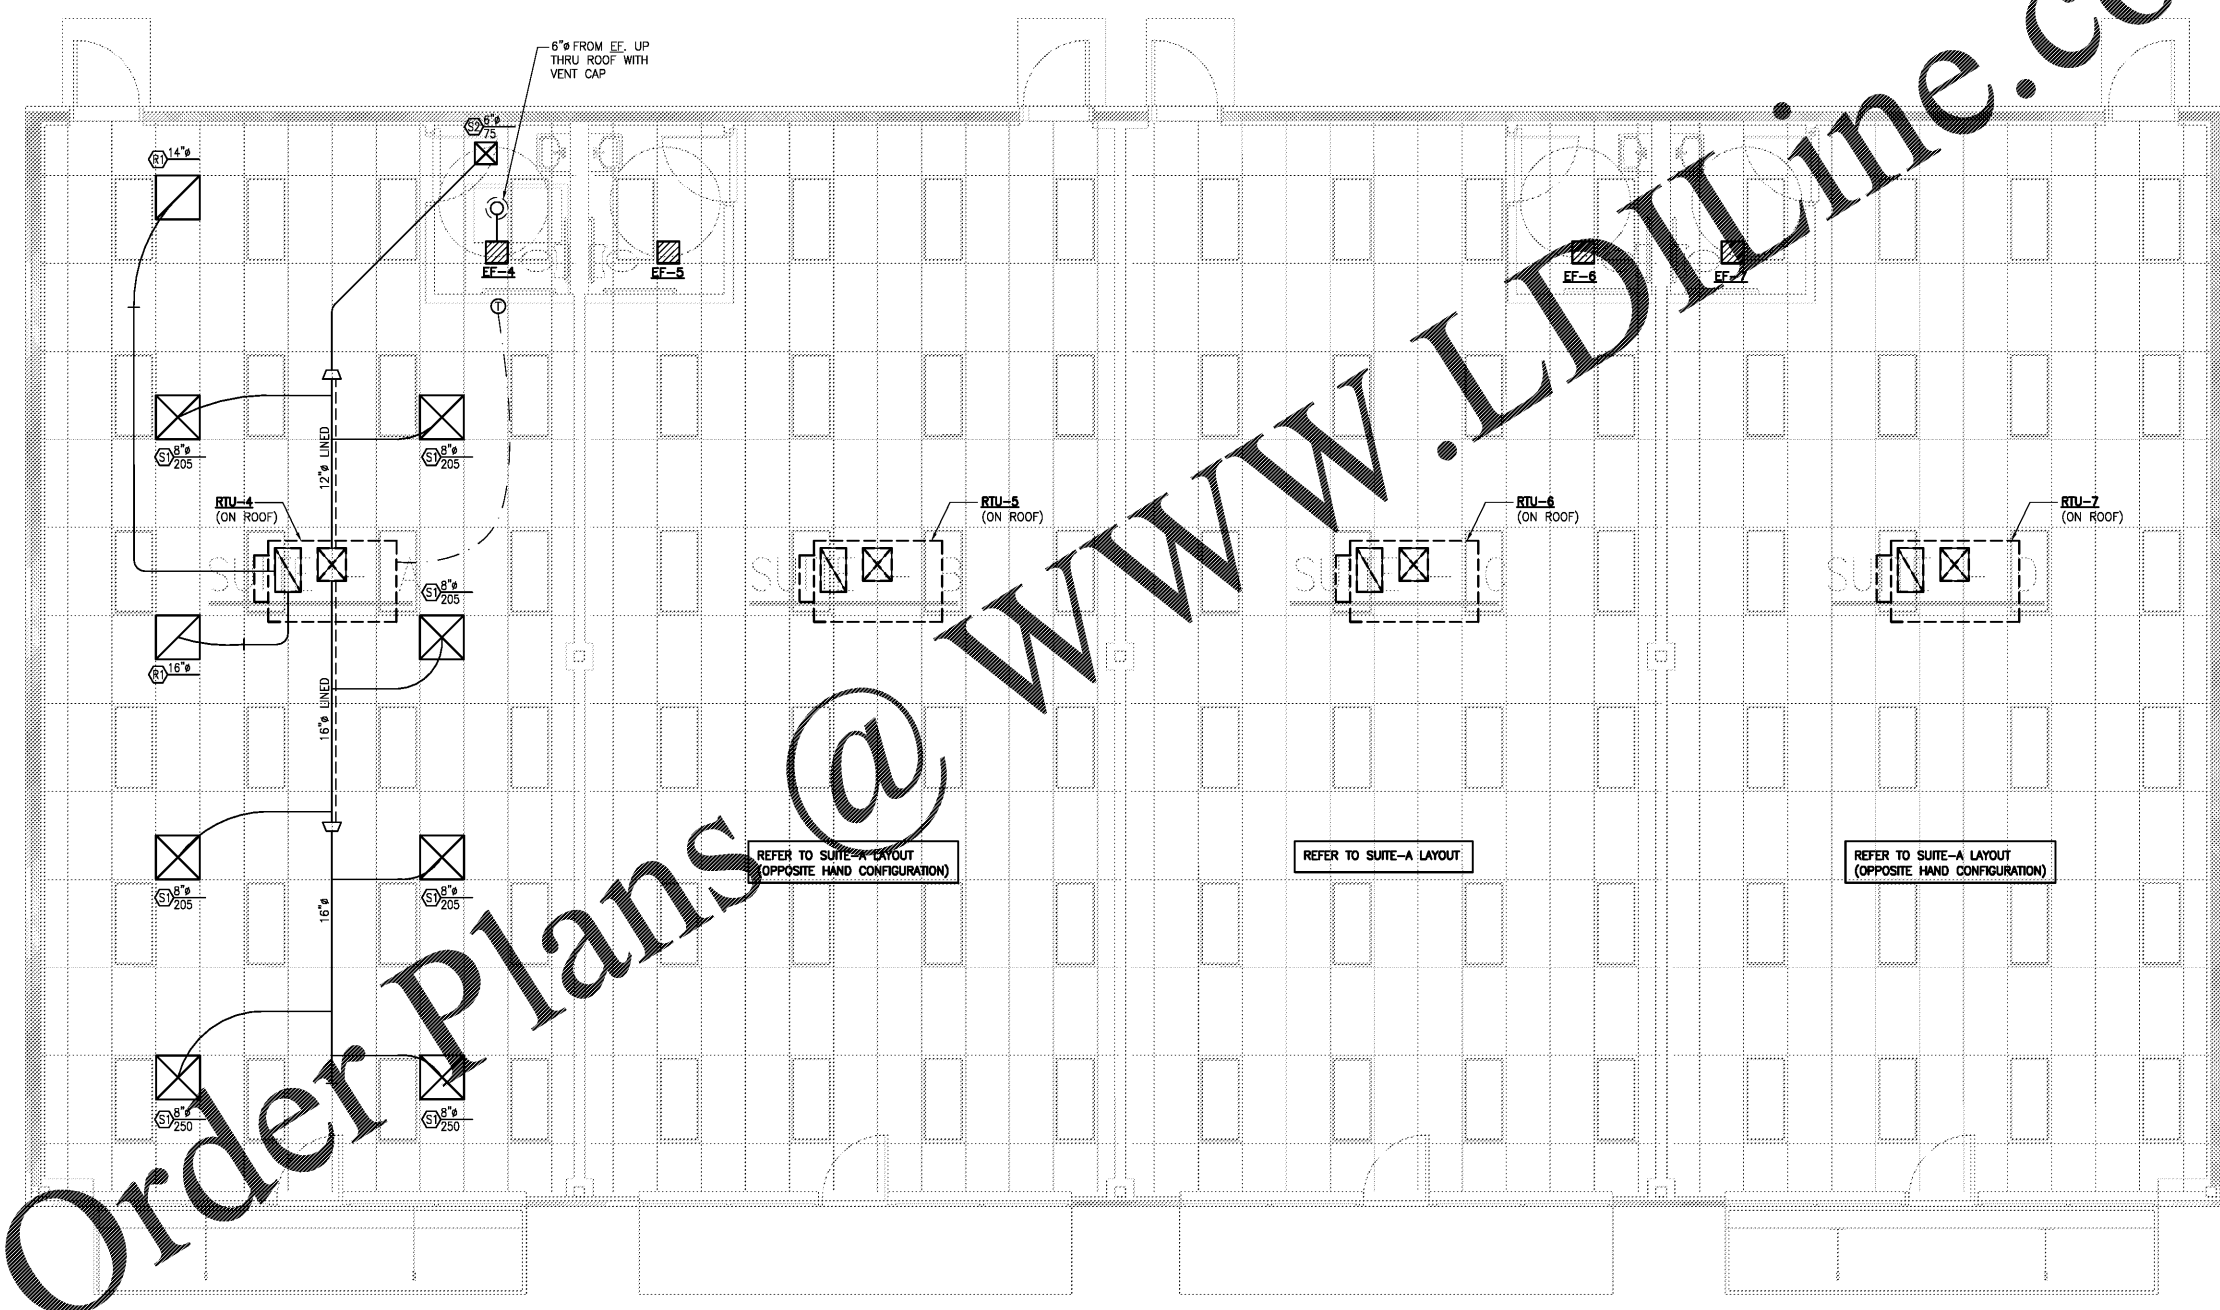

1 RETAIL HVAC PLAN
M-3.1 SCALE: 1/4" = 1'-0"

Order Plans @ WWW.LDILine.com



DATE 06/18/20	DRAWING NO. M-3.1	PROJECT WILD WOLF - COMMERCIAL DEVELOPMENT BOYD MORRIS ROAD & GA HWY 293 SPUR BARTOW COUNTY, GEORGIA 30120	DRAWN BY W.S.M.	CHECKED BY W.S.M.	DATE 06/18/20
general contractor BLACKWATER CONSTRUCTION 2100 SHELLE BLVD - SUITE 400 - DULUTH, GEORGIA 30097 VOICE 404-544-3505 FAX 404-544-3505			engineering consultant CRAY 187 Green Consulting Engineers, Inc. 1827 Powers Ferry Road Building 20, Suite 100 Atlanta, Georgia 30339 Tel: (770) 952-9028		