
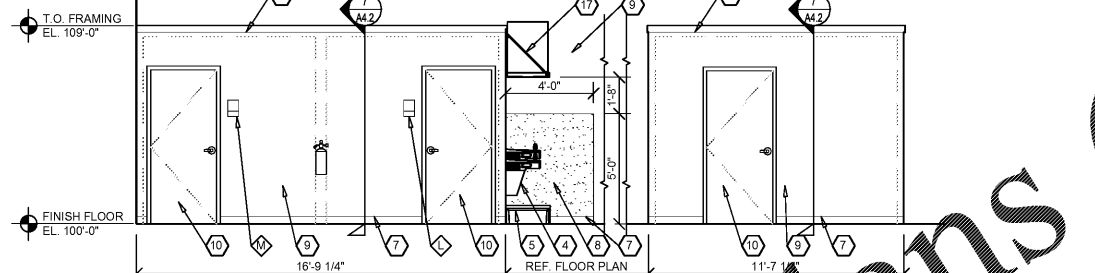
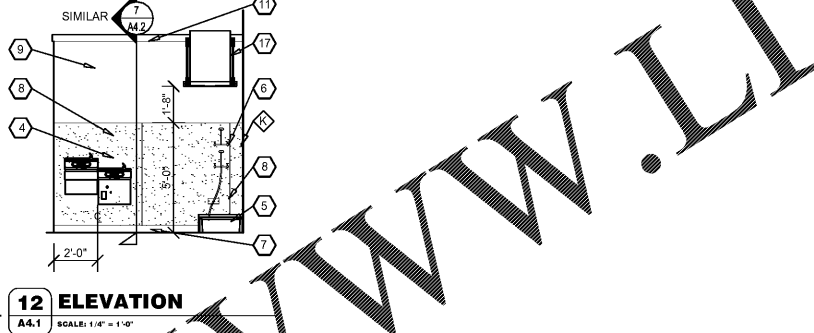
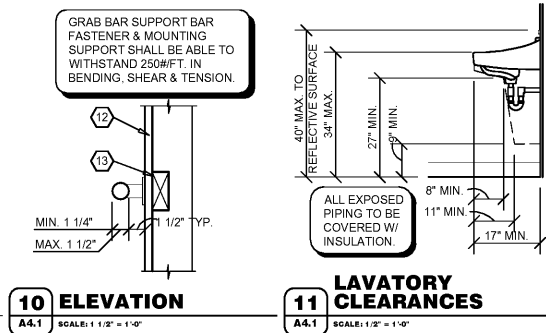
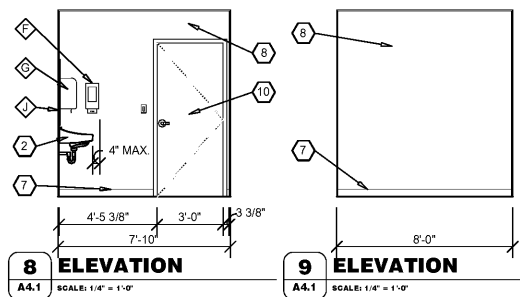


NOTE: REFER TO OVERALL FLOOR PLAN FOR RESTROOM ORIENTATION AND LAYOUT OF ADJACENT WALLS.

1A ENLARGED PLAN
A4.1 SCALE: 1/4" = 1'-0"



1B ENLARGED PLAN (ACCESSIBILITY CLEARANCE DIAGRAMS)
A4.1 SCALE: 1/4" = 1'-0"

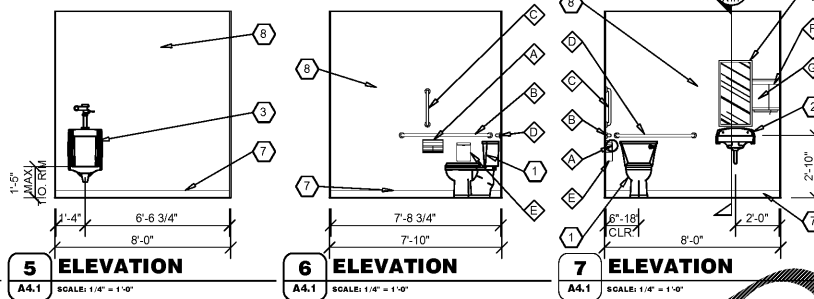

13 ELEVATION
A4.1 SCALE: 1/4" = 1'-0"

14 ELEVATION
A4.1 SCALE: 1/4" = 1'-0"

15 DRINKING FOUNTAIN CLEARANCES
A4.1 SCALE: 1/2" = 1'-0"

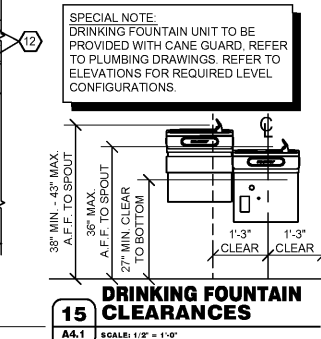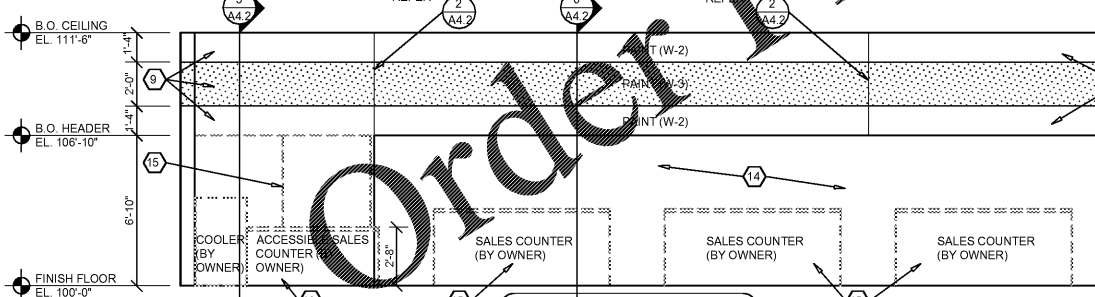

14 ELEVATION
A4.1 SCALE: 1/4" = 1'-0"

NOTE: WALL PAINT SCHEME OCCURS AROUND INTERIOR PERIMETER OF PARTS AREA "A", UNLESS OTHERWISE INDICATED.

15 DRINKING FOUNTAIN CLEARANCES
A4.1 SCALE: 1/2" = 1'-0"

GENERAL NOTES

- A REFER TO PROJECT MANUAL FOR ADDITIONAL REQUIREMENTS.
- B LAYOUT DIMENSIONS OF PLUMBING FIXTURES AND ACCESSORIES TO FACE OF GYPSUM BOARD OR CENTER LINE OF FIXTURE. LAYOUT DIMENSIONS OF WALLS AND CEILINGS TO ROUGH FACE OF FRAMING, MASONRY, OR CENTER LINE OF STRUCTURE. ALL GYPSUM BOARD 5/8" THICK UNLESS OTHERWISE INDICATED AND DIMENSIONS NOT SHOWN FOR CLARITY.
- C REFER TO PLUMBING DRAWINGS FOR FIXTURE TYPES AND ADDITIONAL REQUIREMENTS. PROVIDE ADDITIONAL COLD FORM METAL FRAMING OR FIRE TREATED BLOCKING AS REQUIRED FOR PROPER SUPPORT.
- D REFER TO INTERIOR FINISH SCHEDULES FOR MATERIAL FINISH TYPES AND LOCATIONS.
- E ALL EXPOSED PIPING BELOW SINKS TO BE COVERED WITH INSULATION.

KEY NOTES

- 6 EYE WASH STATION. INSTALL WITH TOP AT 48" ABOVE FINISH FLOOR.
- 7 BASE. REFER TO FINISH SCHEDULE.
- 8 SANITARY WALL PANEL SYSTEM. REFER TO FINISH SCHEDULE. PROVIDE TRIM AND EDGE MOLDING AROUND PERIMETER. ATTACH TO SUBSTRATE AS REQUIRED.
- 9 PAINT. REFER TO FINISH SCHEDULE.
- 10 DOOR. REFER TO DOOR AND FINISH SCHEDULES.
- 11 WOOD TRIM, PAINT.
- 12 WALL CONSTRUCTION. REFER TO FLOOR PLAN FOR TYPES.
- 13 FIRE TREATED X WOOD BLOCKING.
- 14 ALL OPENING TO BEYOND. REFER TO FLOOR PLAN.
- 15 OWNER FURNISHED AND INSTALLED FURNISHING, SEVELING, OR FIXTURE. FOR REFERENCE ONLY (N.I.C.)
- 16 OWNER FURNISHED AND INSTALLED ACCESSIBLE CUSTOMER SERVICE COUNTER TO COMPLY WITH ACCESSIBILITY REQUIREMENTS. FOR REFERENCE ONLY (N.I.C.)
- 17 WALL MOUNTED WATER HEATER AND SUPPORT PLATFORM. REFER TO PLUMBING DRAWINGS. PROVIDE FIRE TREATED BLOCKING OR ADDITIONAL COLD FORM FRAMING AS REQUIRED FOR INSTALLATION.

KEY NOTES


- 1 WATER CLOSET. ACCESSIBLE FIXTURE HEIGHT TO TOP OF SEAT TO BE 17" MINIMUM AND 19" MAXIMUM A.F.F.. ACCESSIBLE FIXTURES AND FLUSH CONTROLS TO BE ON WIDE SIDE OF TOILET.
- 2 WALL MOUNTED JANITOR.
- 3 WALL MOUNTED URINAL. MOUNT RIM 1'-5" MAXIMUM ABOVE FINISH FLOOR.
- 4 HIGH / LOW DRINKING FOUNTAIN. REFER TO DETAIL 10/A4.1.
- 5 FLOOR MOUNTED JANITOR SINK.

ACCESSORY SCHEDULE

MK	DESCRIPTION	MANUFACTURER	SERIES / MODEL	MOUNTING LOCATION	ACCESSORY NOTES
4	TISSUE PAPER DISPENSER	GEORGIA PACIFIC	56783A	REFER PLANS, ELEVATIONS, LEGEND	NOTE 2
6	GRAB BAR	BOBRICK	B6806 x 48"	REFER PLANS, ELEVATIONS, LEGEND	
6	GRAB BAR	BOBRICK	B6806 x 18"	REFER PLANS, ELEVATIONS, LEGEND	
6	GRAB BAR	BOBRICK	B6806 x 42"	REFER PLANS, ELEVATIONS, LEGEND	
6	SANITARY NAPKIN RECEPTACLE	BOBRICK	B-270	REFER PLANS, ELEVATIONS, LEGEND	WOMEN'S RESTROOM ONLY
6	SOAP DISPENSER	GOJO	PRO 2000	REFER PLANS, ELEVATIONS, LEGEND	NOTE 2
6	PAPER TOWEL DISPENSER	GEORGIA PACIFIC	59460A	REFER PLANS, ELEVATIONS, LEGEND	NOTE 2
6	(NOT USED)				
6	MIRROR	BOBRICK	B-165-1836 18" W X 36" H	REFER PLANS, ELEVATIONS, LEGEND	
6	MOP HANGER	REFER TO PLUMBING DRAWINGS	REFER TO PLUMBING DRAWINGS	48" A.F.F. TO CENTER	
6	DOOR SIGN (MEN)	ROCKWOOD	BFM687	REFER PLANS, ELEVATIONS, LEGEND	NOTE 3
6	DOOR SIGN (WOMEN)	ROCKWOOD	BFM688	REFER PLANS, ELEVATIONS, LEGEND	NOTE 3

ACCESSORY GENERAL NOTES:
 1. CONTRACTOR TO PROVIDE FIRE TREATED WOOD BLOCKING FOR INSTALLATION OF TOILET ACCESSORIES, INCLUDING OWNER FURNISHED AND CONTRACTOR INSTALLED ACCESSORIES. COORDINATE REQUIREMENTS WITH OWNER.
 2. ACCESSORY OWNER FURNISHED AND CONTRACTOR INSTALLED. REFER TO SCOPE OF WORK SCHEDULE FOR ADDITIONAL REQUIREMENTS.
 3. TACTILE (BRAILLE GRADE 2 CONTRACTED) SIGN WITH PICTOGRAMS IN COMPLIANCE WITH ANSI A117.1 AND ADA STANDARDS. COLORS WHITE TEXT AND SYMBOLS ON BLUE (NO. 15090 IN FEDERAL STANDARD 595B) BACKGROUND.

ACCESSORY MOUNTING LEGEND

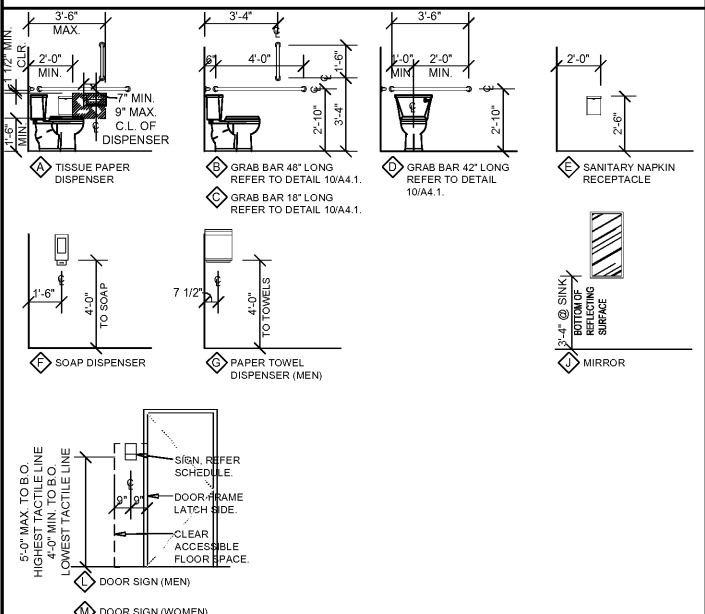

INDIVIDUAL ARCHITECTURAL REGISTRATION NO.: A00017636
 Date: 2020.04.20
 20:24:54 -05'00"
 Adobe Acrobat
 version:
 2019.012.20040
 SHEETS BEARING THIS SEAL ARE AUTHENTICATED. RESPONSIBILITY FOR ALL OTHER PLANS, SPECIFICATIONS OR INSTRUMENTS ARE DISCLAIMED.

O'Reilly AUTO PARTS
 CORPORATE OFFICES
 293 SOUTH PATTERSON
 SPRINGFIELD, MISSOURI 65802
 (417) 866-2674 TELEPHONE

PROJECT:
NEW O'REILLY AUTO PARTS STORE
2425 COUNTY HIGHWAY 484
OCALA, FLORIDA
INTERIOR ELEVATIONS

Buddy Webb, NCARB, AIA
Architect - Consultant
 3057 EAST CAIRO
 SPRINGFIELD, MISSOURI 65802
 (417) 877-1385 TELEPHONE
 (417) 877-9736 FAX

DRAWN BY: CHECKED BY:
RJD SB
 DATE:
04/01/20
 REVISION:
 PROJECT NUMBER:
OF7
 SHEET NUMBER

A4.1

© COPYRIGHT 2020 - DESIGNS, DRAWINGS AND SPECIFICATIONS ARE INSTRUMENTS OF SERVICE AND ARE THE PROPERTY OF THE DESIGN PROFESSIONAL. REPRODUCTION PROHIBITED WITHOUT THE EXPRESSED WRITTEN CONSENT OF THE DESIGN PROFESSIONAL.