


Order Plans @

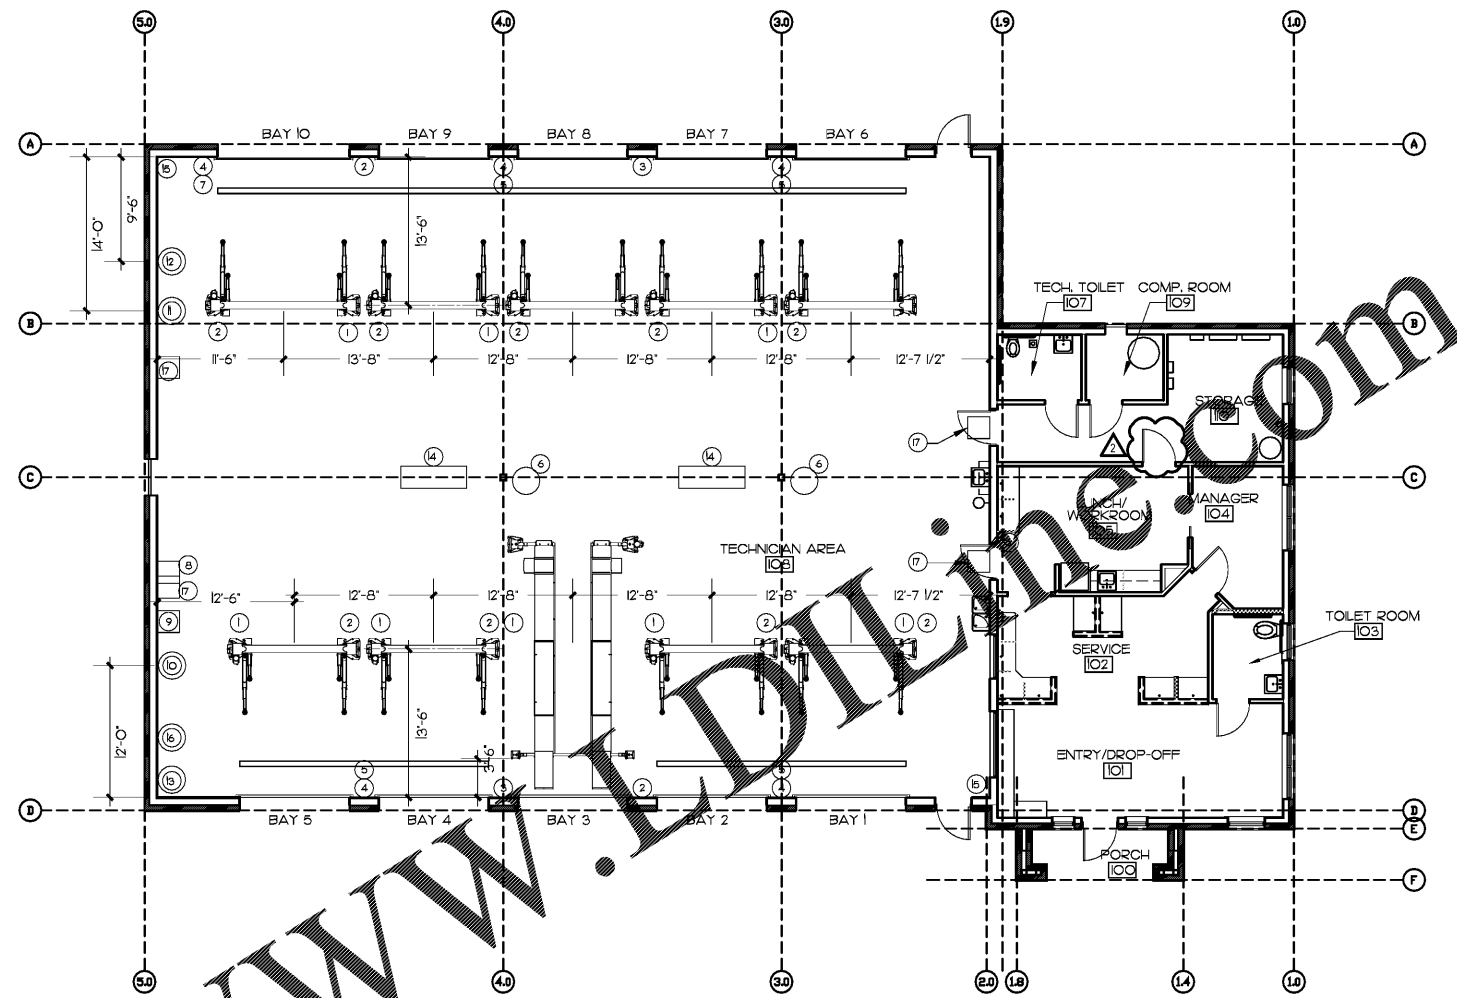

2 EQUIPMENT PLAN
Scale: 1/8" = 1'-0"

EQUIPMENT SCHEDULE		
NO.	EQUIPMENT	NOTES
1	LIGHT REEL	MOUNT TO PASSENGERS SIDE OF LIFT; BAYS 1, 3, 4, 6, 8, 9
2	AR REEL	MOUNT TO PASSENGER SIDE OF ALL LIFTS MOUNT TO CENTERLINE OF PLASTERS • 96' A.F.F.
3	WATER REEL	MOUNT TO CENTERLINE OF PLASTERS; BETWEEN BAYS 263, 788 B.O. REEL • 60' A.F.F.
4	LIFT ADAPTERS	MOUNT TO CENTERLINE OF PLASTERS; BETWEEN BAYS 162, 364, 667, 869
5	EXHAUST HOSE REEL	MOUNT TO CENTERLINE OF PLASTERS; BETWEEN BAYS 162, 364, 667 • 72' A.F.F.
6	OIL DISPENSERS	MOUNT ON BACK WALL IN LINE WITH CENTERLINE OF PLASTERS; BETWEEN BAYS 364, 667 • 72' A.F.F. TO BOTTOM OF BASE
7	STRUT COMPRESSOR	MOUNT TO CENTERLINE OF PLASTERS; BETWEEN BAY 869 • 26.5' A.F.F.
8	BENCH/GRINDER STAND	16' FROM BACK WALL, 30' FROM BRAKE LATHE
9	BRAKE LATHE	
10	PARTS WASHER	POSITION ON SHOP END WALL, 10' FROM BACK WALL
11	TIRE MACHINE	POSITION ON SHOP END WALL, 10' FROM FRONT BAY DOOR WALL
12	TIRE BALANCER	POSITION ON SHOP END WALL, 5'-6" FROM FRONT BAY DOOR WALL
13	NEW OIL CONTAINER	POSITION IN CORNER, SHOP END WALL AND BACK WALL
14	WORK BENCH	POSITION ON CENTERLINE OF BAYS: 2, 4, 7, 8
15	FIRE EXTINGUISHER	SEE SHEET A-2
16	TRIPLE RHINO TANK	POSITION ON SHOP REAR WALL, NEXT TO NEW OIL CONTAINER
17	STORAGE SHELF	
18	55 GALLON DRUM	POSITION ON SHOP REAR WALL, NEXT TO TRIPLE RHINO TANK
19	55 GALLON DRUM	POSITION ON SHOP REAR WALL, NEXT TO OTHER 55 GALLON DRUM

*NOTE: POWER FOR LIFTS IS LOCATED ON PASSENGER SIDE BAYS 1-4 AND BAYS 6-9
POWER FOR ALIGNMENT RACK, BAY 5, IS LOCATED AT THE FRONT DRIVERS SIDE. REF: E-3.01


1 EQUIPMENT SCHEDULE
NO SCALE



STEWART • REINDERBMA
ARCHITECTURE, PLLC
5450 E. High Street, Suite 200
Phoenix, Arizona 85054
P: 480.515.5123
www.sra360.com

Christian Brothers
Automotive
Wickham Road
Melbourne, Florida

Christian Brothers
Automotive
17725 Katy Freeway, St. 200
Houston, TX 77094

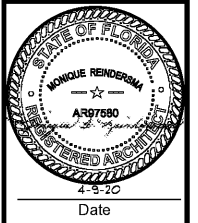

Revisions	
1/23/20	Prototype Update
4/1/20	City Comments
4/9/20	T2 Client Rev.

Project No. 19-097
Drawn By:
Date: 03/06/20
Sheet Title:

EQUIPMENT
FLOOR PLAN

Drawing No.
A-2.2
10RHS-11-2019