


STEWART + REINDERMAN  
ARCHITECTURE, PLLC  
5450 E. High Street, Suite 200  
Phoenix, Arizona 85054  
P: 480.515.5123  
www.sra360.com

Christian Brothers  
Automotive  
Wickham Road  
Melbourne, Florida

CHRISTIAN BROTHERS  
AUTOMOTIVE  
1725 Katy Freeway, St. 200  
Houston, TX 77054

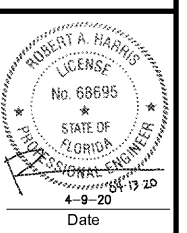

Revisions	
1/23/20	Prototype Update
4/1/20	City Comments
4/9/20	T2 Client Rev.

Project No. 19-097  
Drawn By: MDB  
Date: 03/06/20  
Sheet Title:

PLUMBING  
SITE PLAN


Drawing No.  
**P-2.01**  
10RHS-11-2019

**GENERAL NOTES:**

- COORDINATE NEW GAS SERVICE AND PROPOSED METER LOCATION WITH LOCAL GAS COMPANY.
- SEE CIVIL FOR UTILITY SIZE AND CONNECTION.

**PLUMBING NOTES BY SYMBOL:**

- NATURAL GAS SERVICE LINE FROM SITE NATURAL GAS MAIN TO METER. PLUMBING CONTRACTOR SHALL BE RESPONSIBLE FOR NEW GAS LINE FROM METER TO BUILDING. COORDINATE WITH UTILITY FOR MAIN EXTENSIONS, METER LOCATION AND SERVICE LINE INSTALLATION. TOTAL BUILDING LOAD = 450 CFH AT 7" W.C. DISCHARGE.
- PROPOSED NATURAL GAS METER LOCATION.
- 1" DOW FROM SITE WATER MAIN TO BUILDING. LINE ENDS UNDERGROUND THRU SLAB. FIELD VERIFY EXACT POINT AND DATE OF CONNECTION. REFER TO CIVIL DRAWINGS FOR CONNECTION.
- CONNECT 4" BUILDING SANITARY SEWER TO SITE SANITARY SEWER. REFER TO CIVIL DRAWINGS FOR EXACT LOCATION AND INVERT ELEVATION.
- NOT USED.
- REFER TO P-2.01 FOR CONTINUATION.
- REFER TO P-3.02 FOR CONTINUATION.
- REFER TO CIVIL DRAWINGS FOR CONTINUATION TO HOLDING TANK AND ALL ASSOCIATED DETAILS AND INFORMATION.

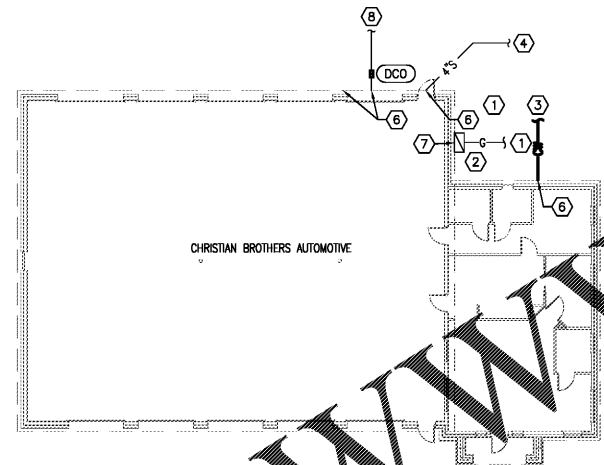

1 PLUMBING SITE PLAN  
SCALE: 1/16"=1'-0"

Order Plans @ [WWW.LDILine.com](http://WWW.LDILine.com)

THIS SHEET IS PART OF THE CONSTRUCTION DOCUMENTS. OTHER SHEETS INCLUDING SPECIFICATIONS APPLY. THAT SHOWN HEREON IS SCHEMATIC IN NATURE AND NOT TO BE USED AS A SHOP DRAWING. THEREFORE, INCLUDE ALL MODIFICATIONS REQUIRED TO CONFORM TO SITE CONDITIONS AND THE EQUIPMENT AND MATERIAL USED. VERIFY LOCATIONS AND DIMENSIONS OF ALL ARCHITECTURAL AND STRUCTURAL ELEMENTS AS SHOWN ON THEIR RESPECTIVE DOCUMENTS. THESE ELEMENTS ARE SHOWN FOR REFERENCE AND SHALL BE VERIFIED PRIOR TO CONSTRUCTION AND THE ENGINEER ASSUMES NO LIABILITY FOR THE ACCURACY OF THESE ELEMENTS. NO DESIGN RESPONSIBILITY IS ASSUMED FOR ANY PORTION OF THE WORK THAT THE PROFESSIONAL ENGINEER HAS NOT SIGNED AND SEALED PER STATE/PROVINCE REQUIREMENTS.

**Dialectic**

Dialectic Inc.  
310 W 20th Street, Suite 200  
Kansas City, MO 64108  
Florida Certificate of  
Authorization Number 8039  
T 816-997-9601  
F 816-997-9602  
DialecticEng.com  
Copyright 2020