


R-2002	
DATE	RELEASE
04.30.20	FOR
	CONSTRUCTION

CHECKED BY: RZ
 DRAWN BY: W.A.A.C.
 © 2020 AKA STUDIO, P.C. THESE DRAWINGS AND DESIGN ARE PROTECTED BY THE COPYRIGHT LAWS OF THE UNITED STATES. THESE DRAWINGS OR ANY PART THEREOF MAY NOT BE REPRODUCED OR TRANSMITTED IN ANY FORM OR BY ANY MEANS WITHOUT THE WRITTEN CONSENT OF AKA STUDIO, P.C.

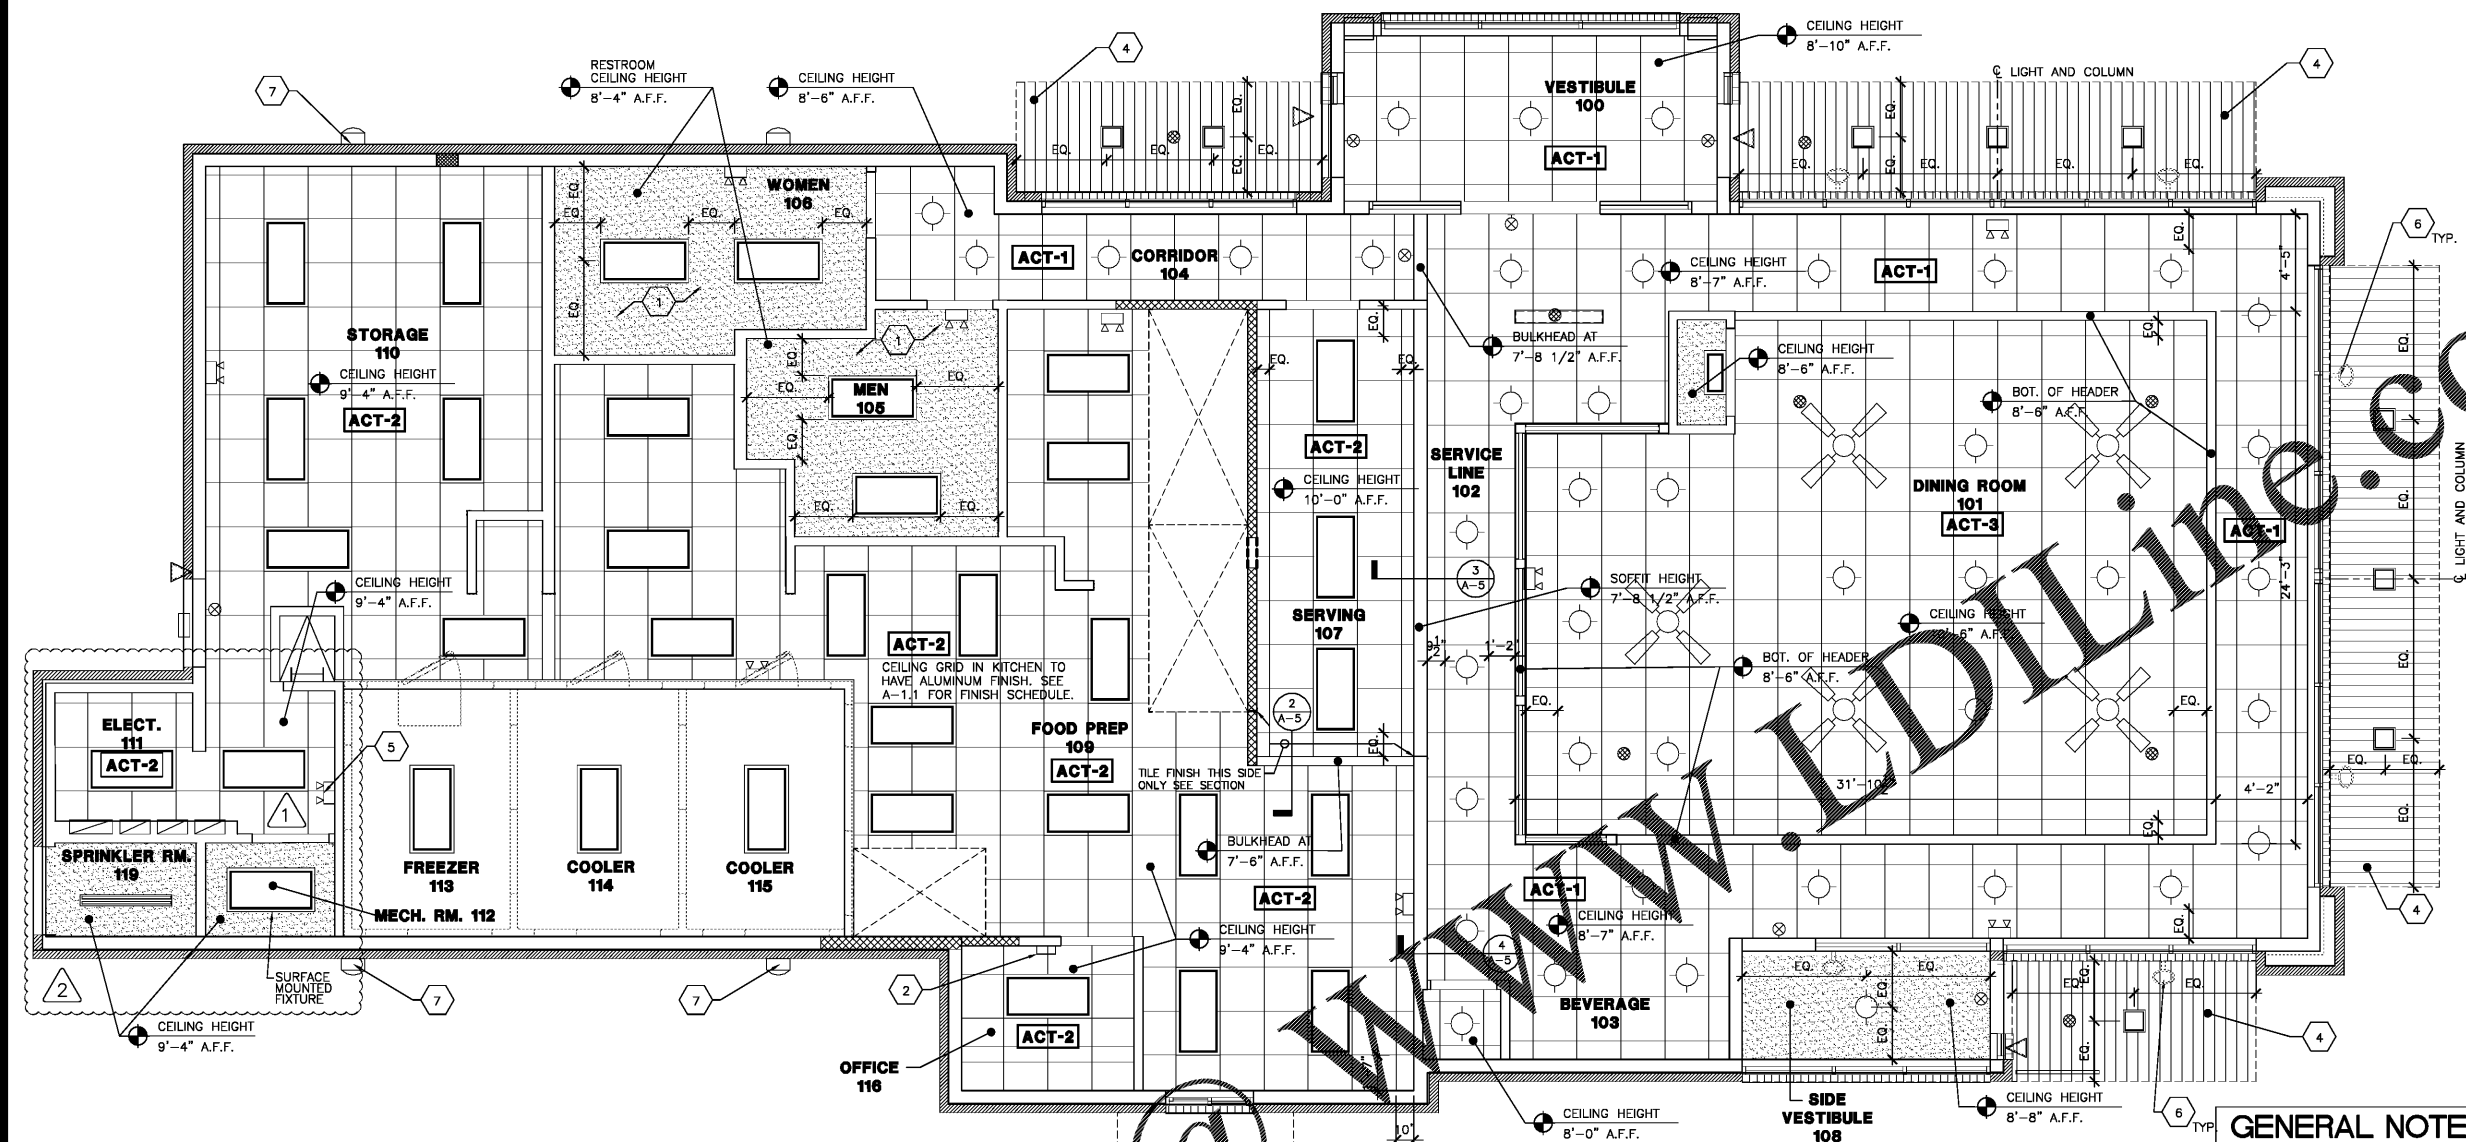

LEGEND	
	EMERGENCY LIGHT
	EXIT SIGN
	EXTERIOR LIGHT FIXTURE
	CAN DOWNLIGHT FIXTURE
	2x4 FLUORESCENT LIGHT FIXTURE
	HVAC SUPPLY DIFFUSER (SEE MECHANICAL SHEETS)
	HVAC RETURN/EXHAUST (SEE MECHANICAL SHEETS)
	RECESSED CEILING SPEAKER
	EXTERIOR EMERGENCY LIGHT
	2' FLUORESCENT LIGHT FIXTURE WITH COVER
	EXTERIOR GOOSE NECK LIGHT FIXTURE
	GYPSUM WALLBOARD CEILING

GENERAL NOTES

- GENERAL CONTRACTOR SHALL NOTIFY ARCHITECT OF ANY PROBLEMS WITH CEILING HEIGHTS OR LIGHT FIXTURES BEFORE FINISH CEILINGS ARE INSTALLED. IF THE CONTRACTOR FAILS TO DO SO, HE SHALL BE RESPONSIBLE FOR TAKING DOWN THE CEILING AND LIGHT FIXTURES AND REINSTALLING THEM IN A CONFIGURATION ACCEPTABLE TO THE ARCHITECT, AT NO ADDITIONAL COST.
- COORDINATE WORK WITH OTHER TRADES HAVING WORK IN THE CEILING INCLUDING, BUT NOT LIMITED TO, TELEPHONE, SECURITY, CABLE COMPANIES, ETC., WHEREVER THEIR RESPECTIVE WORK IS CONTIGUOUS.
- PROVIDE CUTOUTS AND OTHER SPECIAL PROVISIONS IN ACOUSTICAL WORK AS REQUIRED FOR LIGHTING FIXTURES, REGISTERS, DIFFUSERS, AND OTHER INSERTED ITEMS.
- ALL MATERIALS SHALL HAVE CLASS I FLAME SPREAD RATING AND BE INSTALLED IN ACCORDANCE WITH MANUFACTURER'S WRITTEN SPECIFICATIONS AND CODES.
- ALL JOINTS IN THE TILE SHALL BE SQUARE, LEVEL, AND ALIGNED WITH EACH OTHER.
- ALL CEILING FIXTURES, EXIT SIGNS, SPEAKERS, ETC. SHALL BE CENTERED IN CEILING TILE, UNLESS NOTED OTHERWISE.
- SEE ENGINEERS DRAWINGS FOR LIGHTING AND MECHANICAL LAYOUTS. CONTRACTOR SHALL NOTIFY ARCHITECT IMMEDIATELY OF ANY DISCREPANCIES NOTED BETWEEN ARCHITECTURAL AND ENGINEERING DRAWINGS, OR BETWEEN ENGINEERING DISCIPLINES.

KEYED NOTES:


- SUSPENDED GYPSUM BOARD CEILING IN RESTROOMS, PAINT 'CEILING WHITE' (P-2) TYP.
- LOCATION OF SECURITY PANEL AT 96" A.F.F., BY OWNER'S SECURITY VENDOR. G.C. TO COORDINATE.
- DRIVE THRU CANOPIES FURNISHED AND INSTALLED BY THE "SIGN CLINIC" IN MOORESVILLE, N.C. TELEPHONE (704) 664 4389.
- METAL SOFFIT PANELS ON UNDERSIDE OF SEAM METAL CANOPIES. COLOR TO MATCH CANOPY (TYPICAL) BY CANOPY MANUFACTURER.
- ADD EMERGENCY LIGHT IN THE AREA OF THE ELECTRICAL PANELS PER 2015 IFC SECTION 1008.3.3.
- EXTERIOR GOOSE NECK LIGHT FIXTURES. SEE EXTERIOR ELEVATIONS FOR EXACT LOCATIONS.
- WALL MOUNTED LIGHT FIXTURES. SEE EXTERIOR ELEVATIONS FOR EXACT LOCATIONS.

NOTES:

- NO STORAGE OF COMBUSTIBLES WITHIN 24" OF CEILING NON SPRINKLERED OR 18" SPRINKLERED.
- HVAC DIFFUSERS "SUPPLY & RETURN" MUST BE FASTENED TO THE GRID OF STRUCTURE
- WILL VERIFY EXIT AND EMERGENCY LIGHT PLACEMENT WITH SITE INSPECTIONS.

1 REFLECTED CLING PLAN

SCALE: 1/4" = 1'-0"

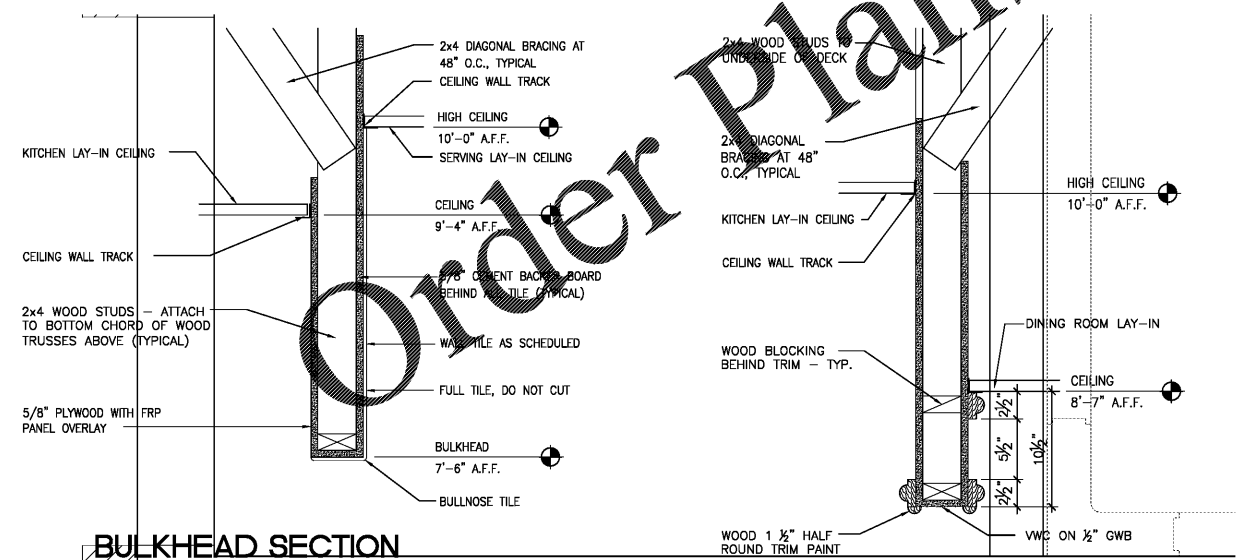

2 BULKHEAD SECTION AT KITCHEN AND SERVICE AREA

SCALE: 1 1/2" = 1'-0"

3 BULKHEAD AT SERVICE AREA

SCALE: 1 1/2" = 1'-0"

RESTAURANT FOR:
NEW GENERATION FOODS, LLC
 P.O. BOX 736
 ATHENS, AL 35612
 TEL. (256) 729-9136



J.E. BRISCOE WAY & MADISON BLVD. PROJECT: R-2002
 MADISON, MADISON COUNTY ALABAMA DATE: 04/30/20
Bojangles RESTAURANT
 REFLECTED CEILING PLAN

A-5