
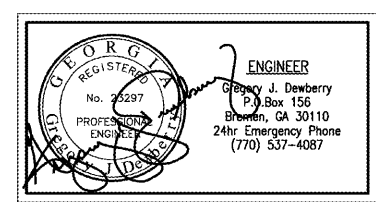
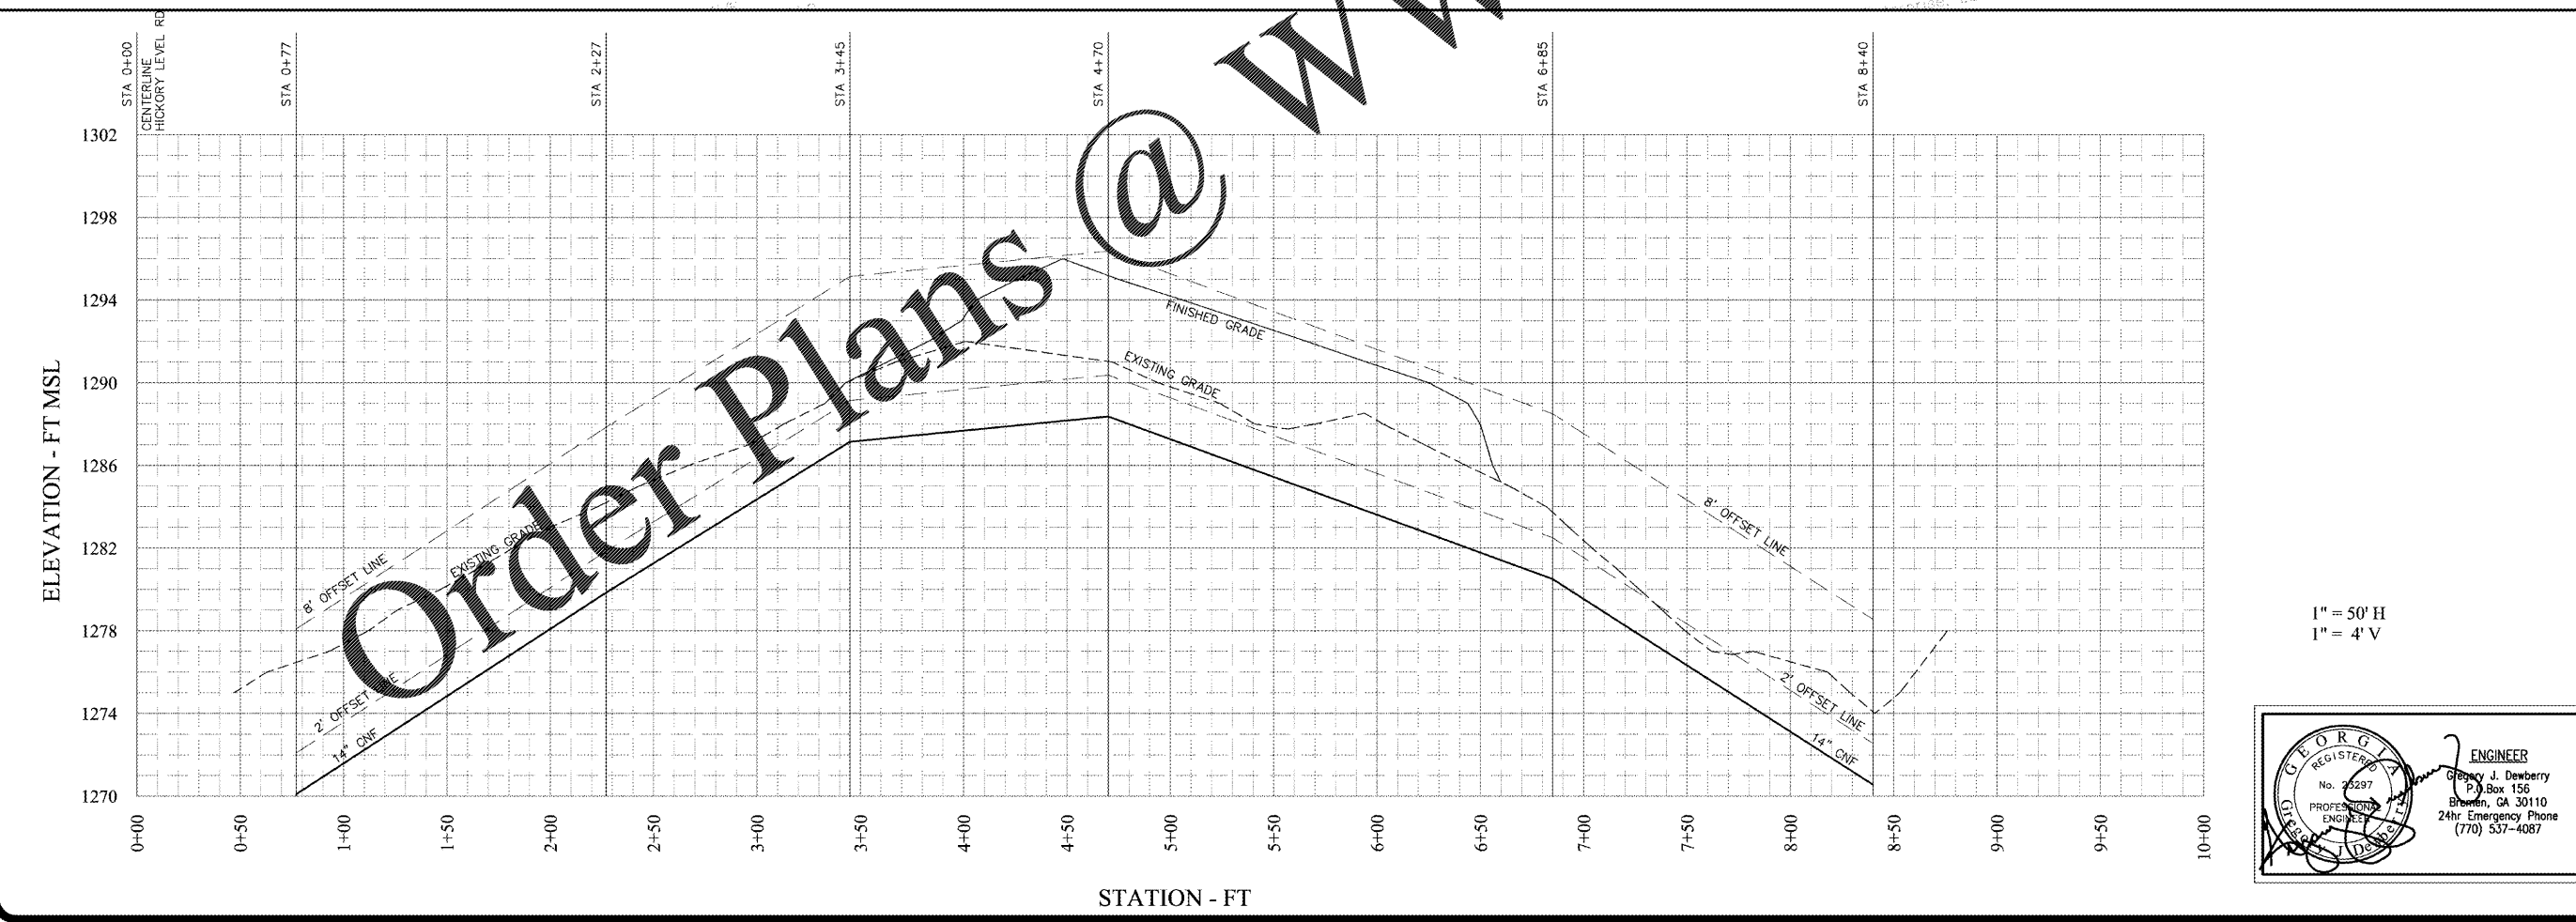


| NO. | DATE | DESCRIPTION | REVISED PER COMMENTS |
|-----|------------|-------------|----------------------|
| 1 | 01-07-2020 | | |

INTERNATIONAL HOUSE OF PANCAKES
 PLANTATION PIPELINE - PLAN AND PROFILE - 14" CNF
 HICKORY LEVEL ROAD AND GEORGIA HIGHWAY 61
 VILLA RICA, CARROLL COUNTY, GEORGIA

CIVIL SOLUTIONS
 ENGINEERING & LAND SURVEYING
 Gregory J. Dewberry, PE, LS
 P.O. Box 156
 Bremen, Georgia 30110
 (770) 537-4087

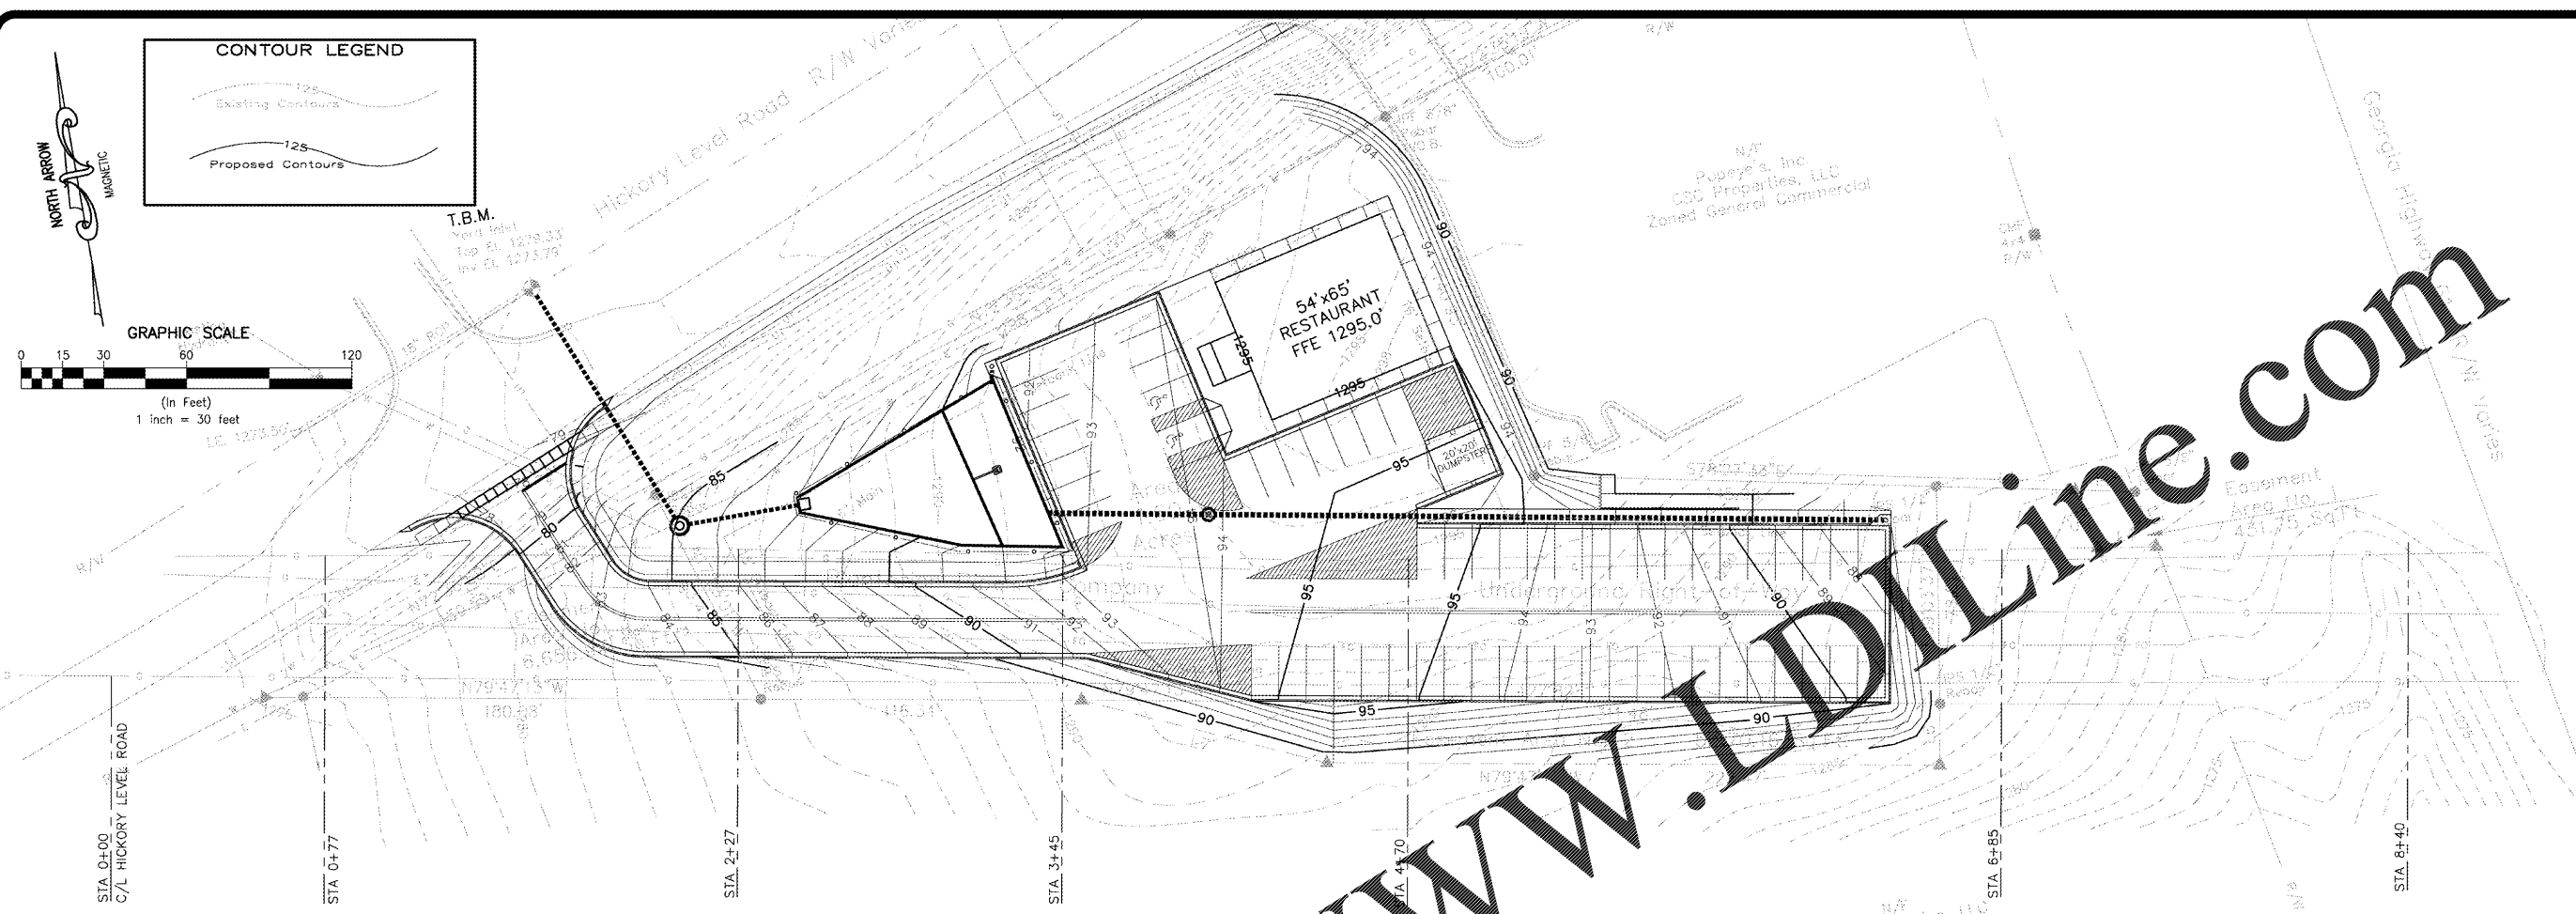

WWW.LDILine.com

Order Plans @

DATE: DECEMBER 2, 2019 PROJECT NO.: 2019154 SCALE: AS SHOWN