


Order Plans

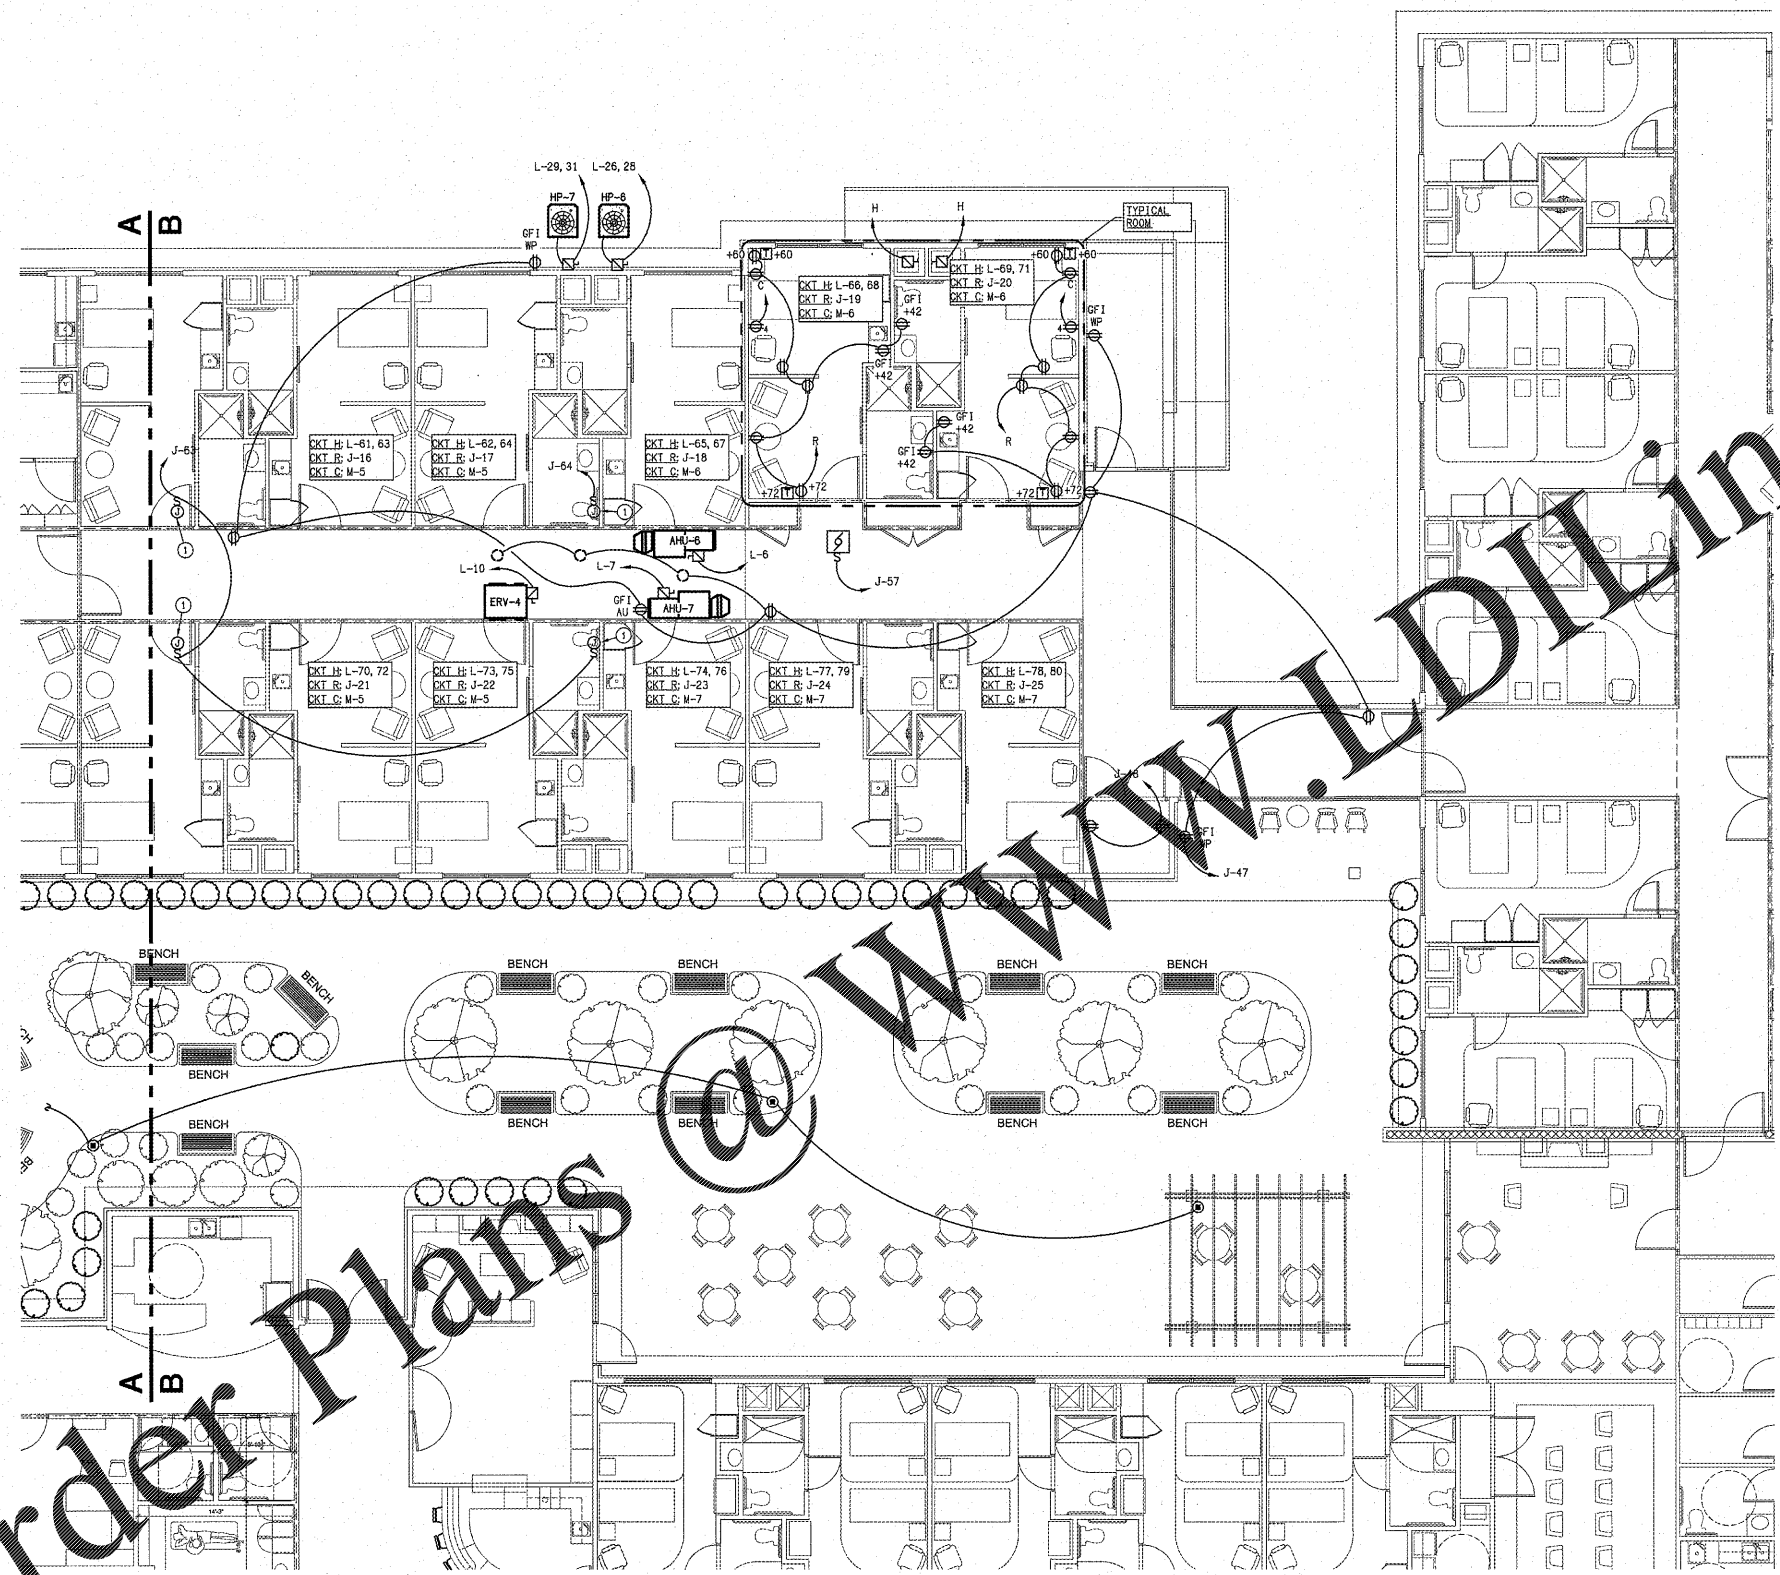

KEY NOTES

① ATTIC VENTILATOR CONNECTION LOCATED ABOVE CEILING IN ATTIC. PROVIDE CIRCUITING AS INDICATED AND TOGGLE DISCONNECT SWITCH AT UNIT.

A POWER PLAN - AREA B
E2.1 SCALE: 1/8" = 1'-0"

ARCHITECT
TIMOTHY
KURMASKIE
AIA, NCARB

1030 Washington St
Raleigh, NC 27605
Phone: 919-846-1600
Fax: 919-846-9404
ARCHITECTSKT.COM

THE DRAWINGS AND DESIGN SHOWN ARE THE PROPERTY OF ARCHITECT TIMOTHY KURMASKIE, AIA, NCARB. THE REPRODUCTION OR USE OF THIS PROPERTY WITHOUT THE WRITTEN CONSENT FROM THE ARCHITECT IS PROHIBITED AND ANY INFRACTION OF THESE RIGHTS IS SUBJECT TO LEGAL ACTION.



DAVID SIMS & ASSOCIATES, P.C.
Consulting Engineers
Arboretum Centre
108 Giles Avenue - Suite 100
Wilmington, N.C. 28403
(910) 791-8016 (OFFICE)
(910) 395-5734 (FAX)

ALTERATION & ADDITION TO:
PruittHealth Savannah
12825 WHITE BLUFF ROAD
SAVANNAH, GA 31419

Project Reference Numbers
Architect's Project No. 180017

Drawn By :

REVISIONS

DATES

PHASE	ISSUED
PERMIT SET	05/22/19

POWER PLAN
AREA B
SHEET NUMBER

E2.1