

Z:\Users\Ryan\AppData\local\temp\publish\_4948\Electrical.dwg, Plotted By: Ryan, Plotted: Jun 09, 2020 - 8:36am


SUPPLIERS, OR VENDORS, ANY SHEET NUMBERING SYSTEM USED WHICH IDENTIFIES DISCIPLINES IS SOLELY TO SEPARATE ARCHITECT'S AND ENGINEER'S SCOPE. IT DOES NOT DEFINE A SUBCONTRACTOR'S SCOPE OF WORK. ANY DISCREPANCIES BETWEEN DRAWINGS, SPECIFICATIONS, CODES OR CONSTRUCTION SEQUENCING SHALL BE BROUGHT TO THE ATTENTION OF THE ARCHITECT PRIOR TO PROCEEDING. NO CONSIDERATION WILL BE GIVEN TO REQUESTS FOR CHANGE ORDERS FOR FAILURE TO OBTAIN AND REVIEW THE COMPLETE SET OF CONSTRUCTION DOCUMENTS, OR FOR FAILURE TO SEEK INTERPRETATION FROM ARCHITECT FOR DISCREPANCIES.

GENERAL NOTES:

- A. FOR BATHROOMS, USE 3/4" WAX WAXES AND UNIVERSAL SERIES MANUATED LED SWITCH.
- B. ALL EXTERIOR LIGHTS SHALL BE CONNECTED TO NEAREST CREDIT AREA OF SWITCHING.
- C. ALL EXTERIOR LIGHTING SHALL BE CONTROLLED BY PHOTOCELL.

KEY NOTES:

- ① LUMINAIRE SHALL BE CONNECTED UNSWITCHED FOR NIGHT LIGHT OPERATION.

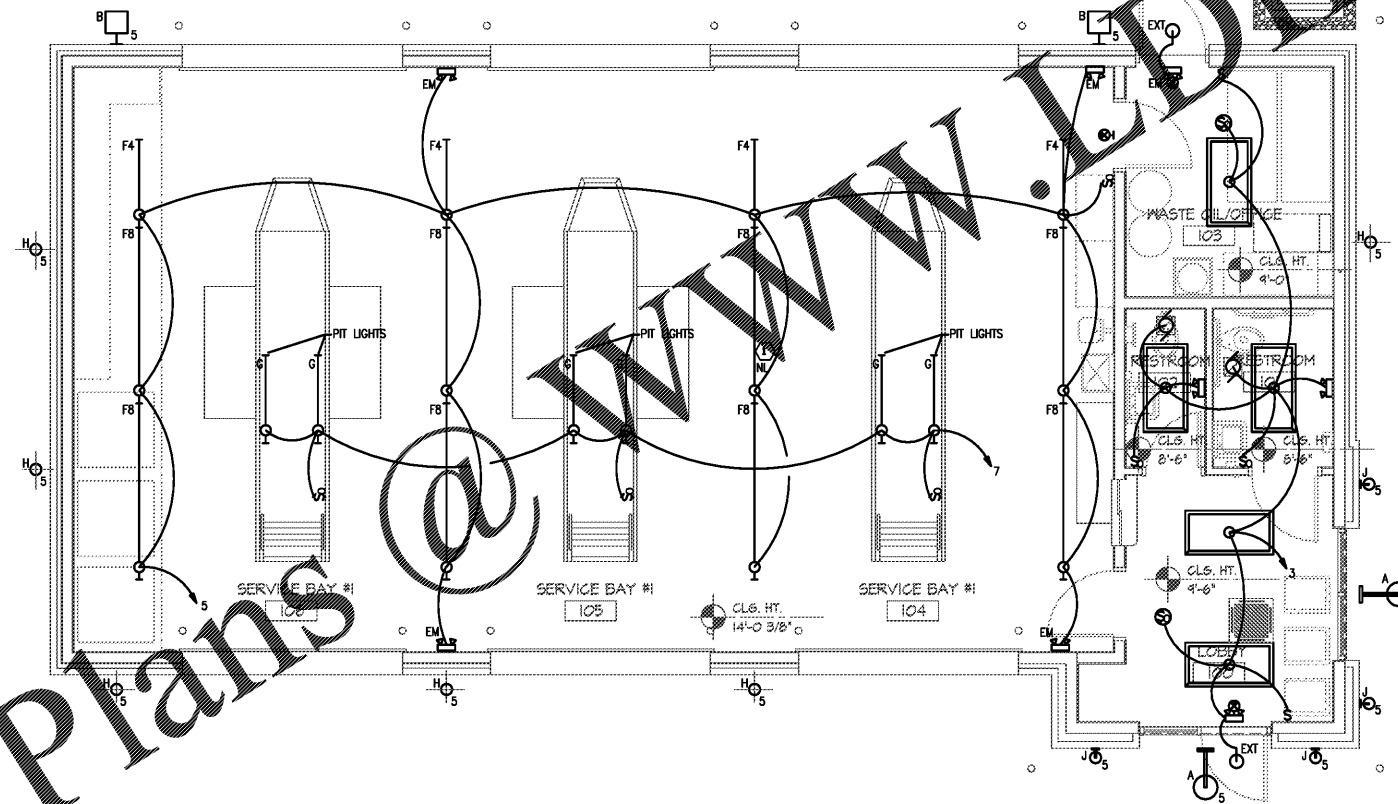

1 ELECTRICAL PLAN  
E1.0 1/4"=1'-0"

Order Plans

www.esdarch.com



421 Penman Street, Suite 200, Charlotte, NC 28203  
Email: esd@esdarch.com • Phone: 704-373-1900



6/5/2020

STRICKLAND BROTHERS  
10 MINUTE OIL CHANGE  
810 SOUTH MAIN STREET  
GRAHAM, NC



ELECTRICAL  
LIGHTING PLAN

ISSUE DATE: 6/5/20

REVISION 1: \_\_\_\_\_  
REVISION 2: \_\_\_\_\_  
REVISION 3: \_\_\_\_\_  
REVISION 4: \_\_\_\_\_

PROJECT #: 20-127  
CONTENT: \_\_\_\_\_

PROJECT ARCHITECT: ECE

DRAWN BY: VW

CADD FILE NAME:  
20-127

THIS DRAWING AND THE DESIGN SHOWN ARE THE PROPERTY OF S&B'S IMPRESS CAR WASH, LLC. THE REPRODUCTION OR USE OF THIS DRAWING WITHOUT THEIR WRITTEN CONSENT IS PROHIBITED. ANY INFRAVIOLATION IS SUBJECT TO LEGAL ACTION.

Sheet

E1.0



1401 CENTRAL AVE., SUITE  
200-J CHARLOTTE, NC 28205  
704.266.0942  
CERTIFICATE NO. P1340