


NEW LIBRARY  
 FOR THE CITY OF OPELIKA  
 GLENN STREET  
 OPELIKA, ALABAMA 36901

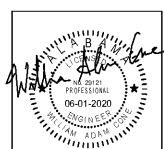


SHEET TITLE:  
 PLUMBING - ROOF PLAN

PROJ.MGR.: WAC  
 DRAWN: ALV  
 DATE: 06-01-2020

REVISIONS	

JOB NO. 19-32  
 SHEET NO.  
**P1.2**  
 5 OF 6  
 SEQUENCE NO:  
 82 / 90

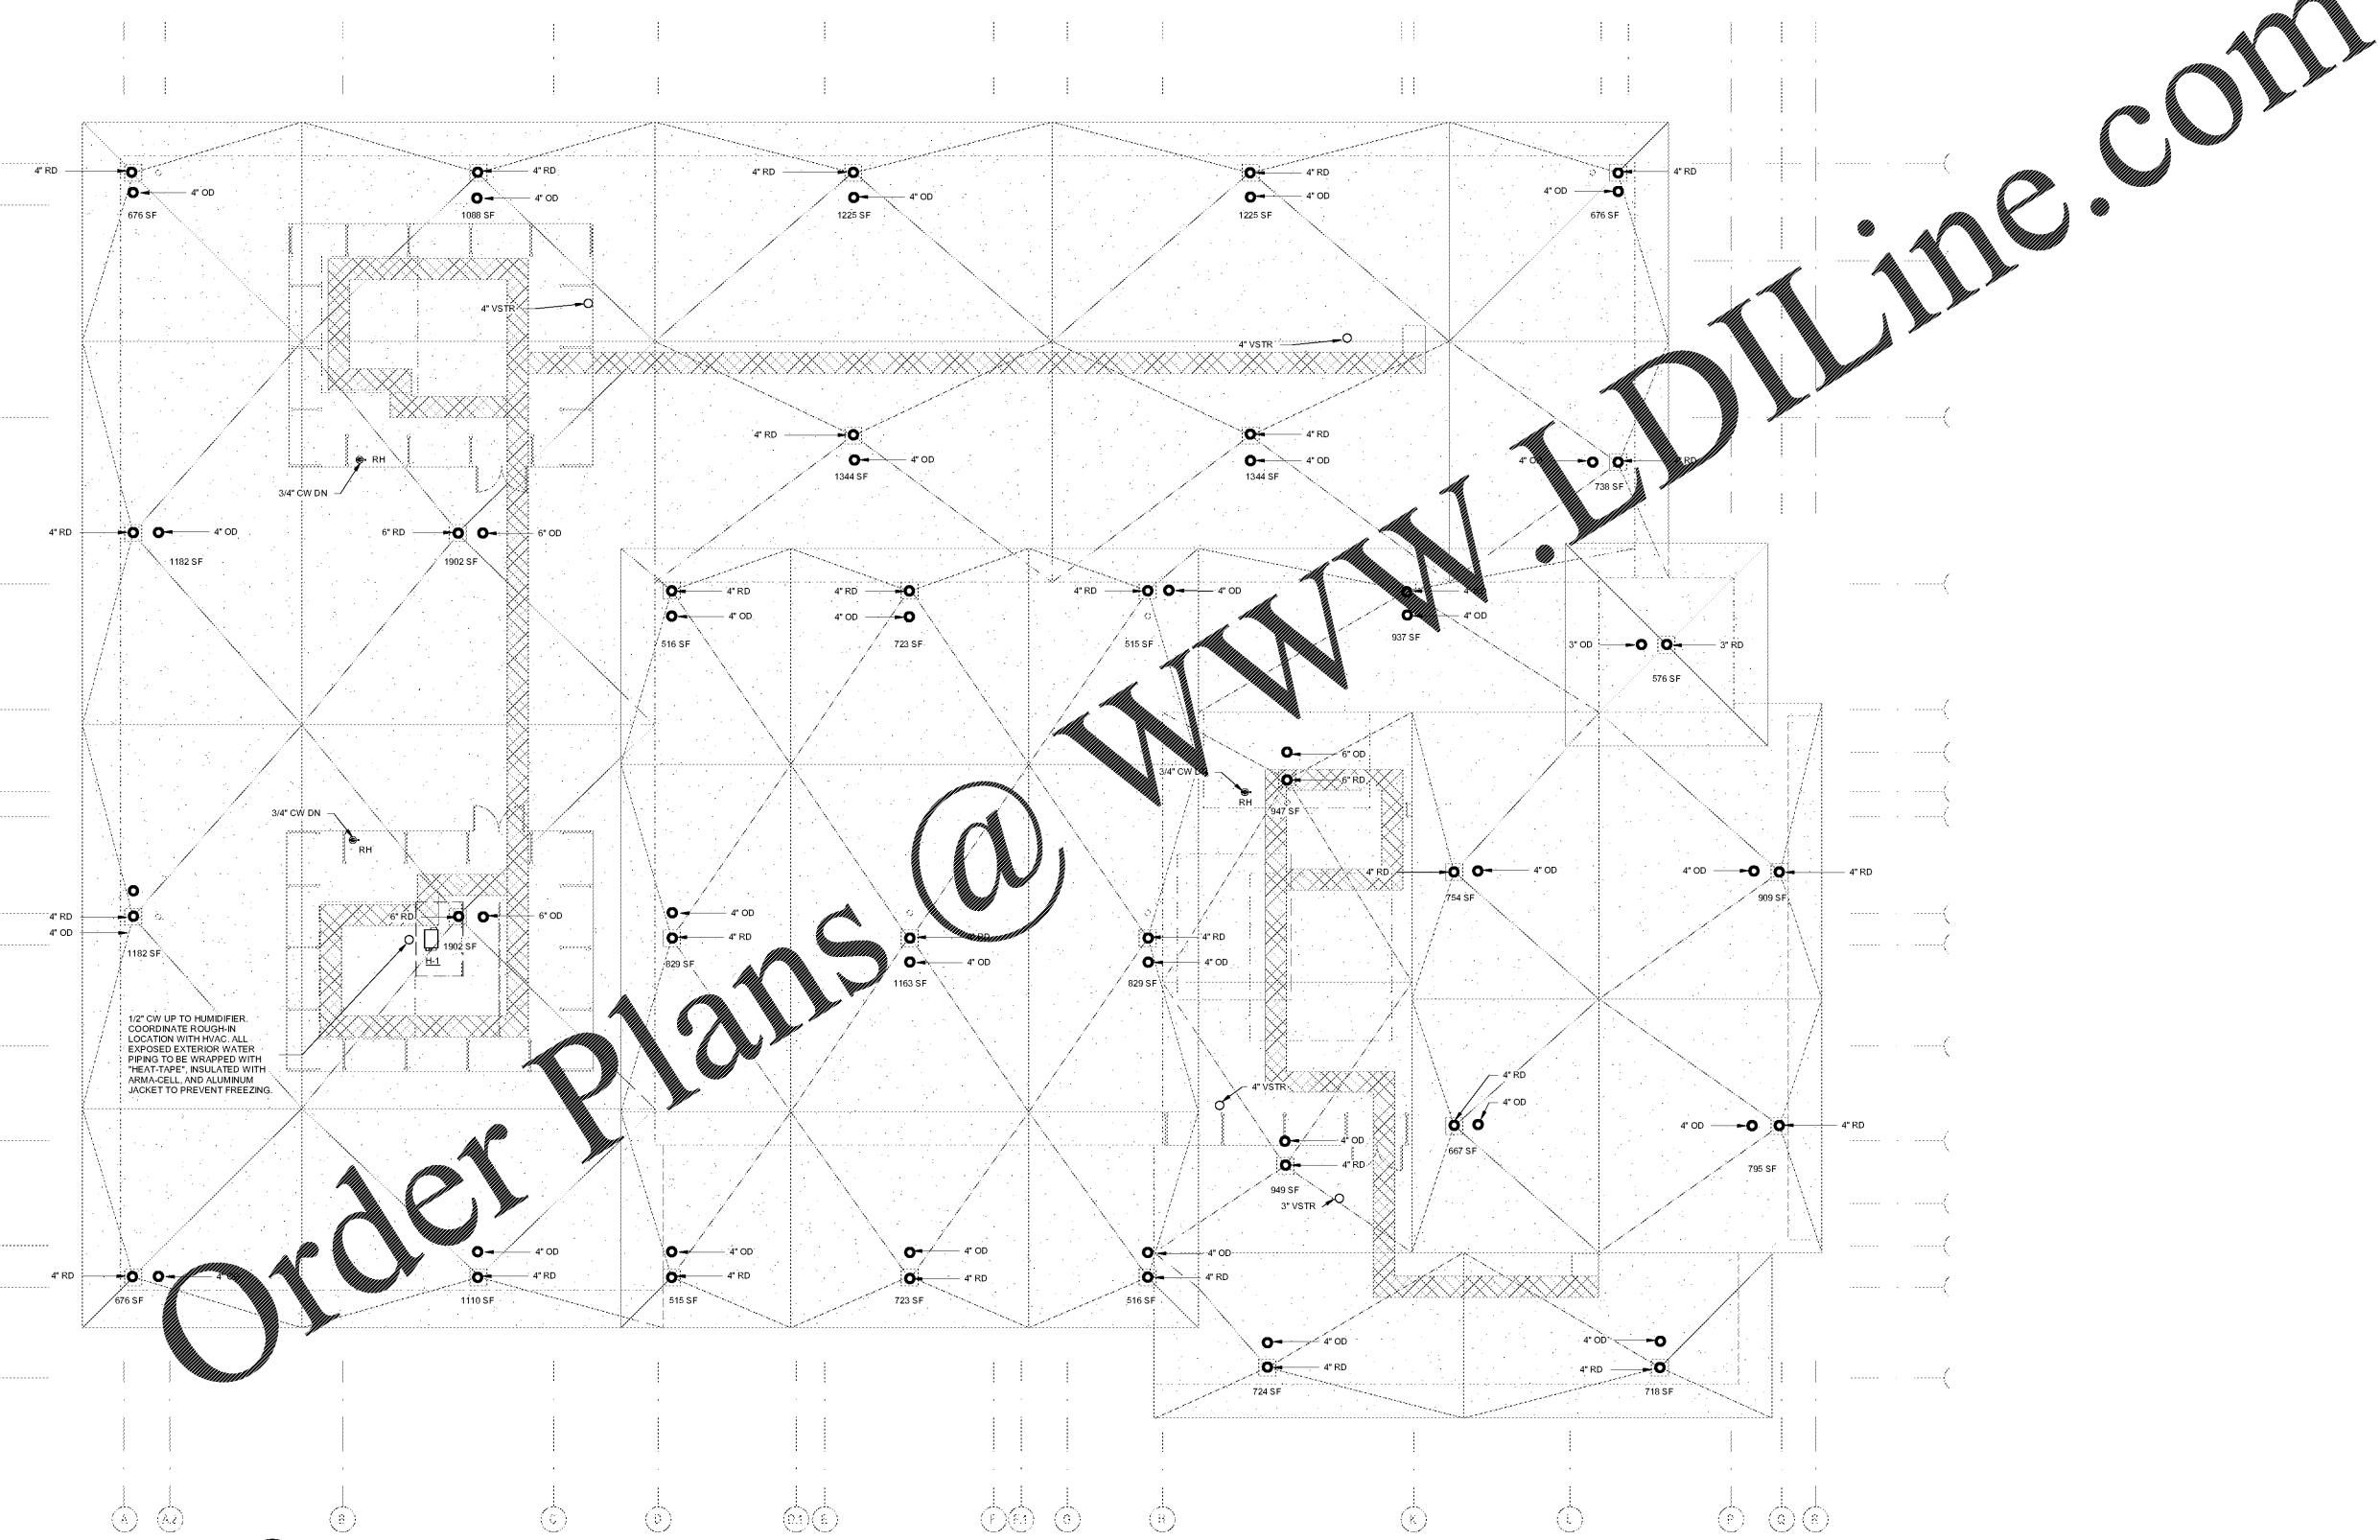

1/2" CW UP TO HUMIDIFIER.  
 COORDINATE ROUGH-IN  
 LOCATION WITH HVAC. ALL  
 EXPOSED EXTERIOR WATER  
 PIPING TO BE WRAPPED WITH  
 "HEAT TAPE", INSULATED WITH  
 ARMA-CELL, AND ALUMINUM  
 JACKET TO PREVENT FREEZING.

Order Plans @ [WWW.LDILine.com](http://WWW.LDILine.com)

**1 PLUMBING - ROOF PLAN**  
 1/8" = 1'-0"