



LATHAN ASSOCIATES ARCHITECTS, P.C.
 300 SHAW PARK SOUTH, SUITE 200
 HOUSTON, ALABAMA 35244
 PH: 205-988-9112 FAX: 205-988-9188

NEW LIBRARY FOR THE CITY OF OPELIKA
 GLENN STREET
 OPELIKA, ALABAMA 36801



 


SHEET TITLE:
 FLOOR PLAN - POWER

PROJ. MGR.: LANCE JUNKIN
 DRAWN: SEC
 DATE: JUNE 1, 2020
 REVISIONS

JOB NO. 19-32
 SHEET NO:

E4.1
 4 OF 7
 SEQUENCE NO:
 87/90

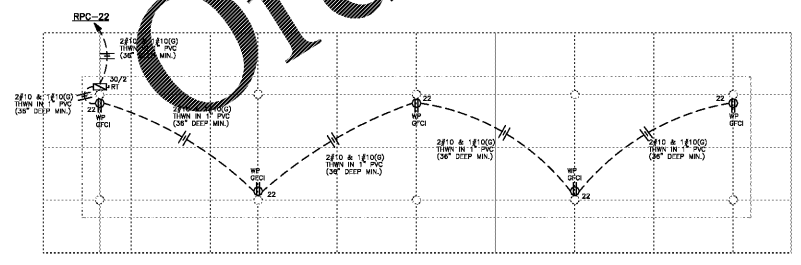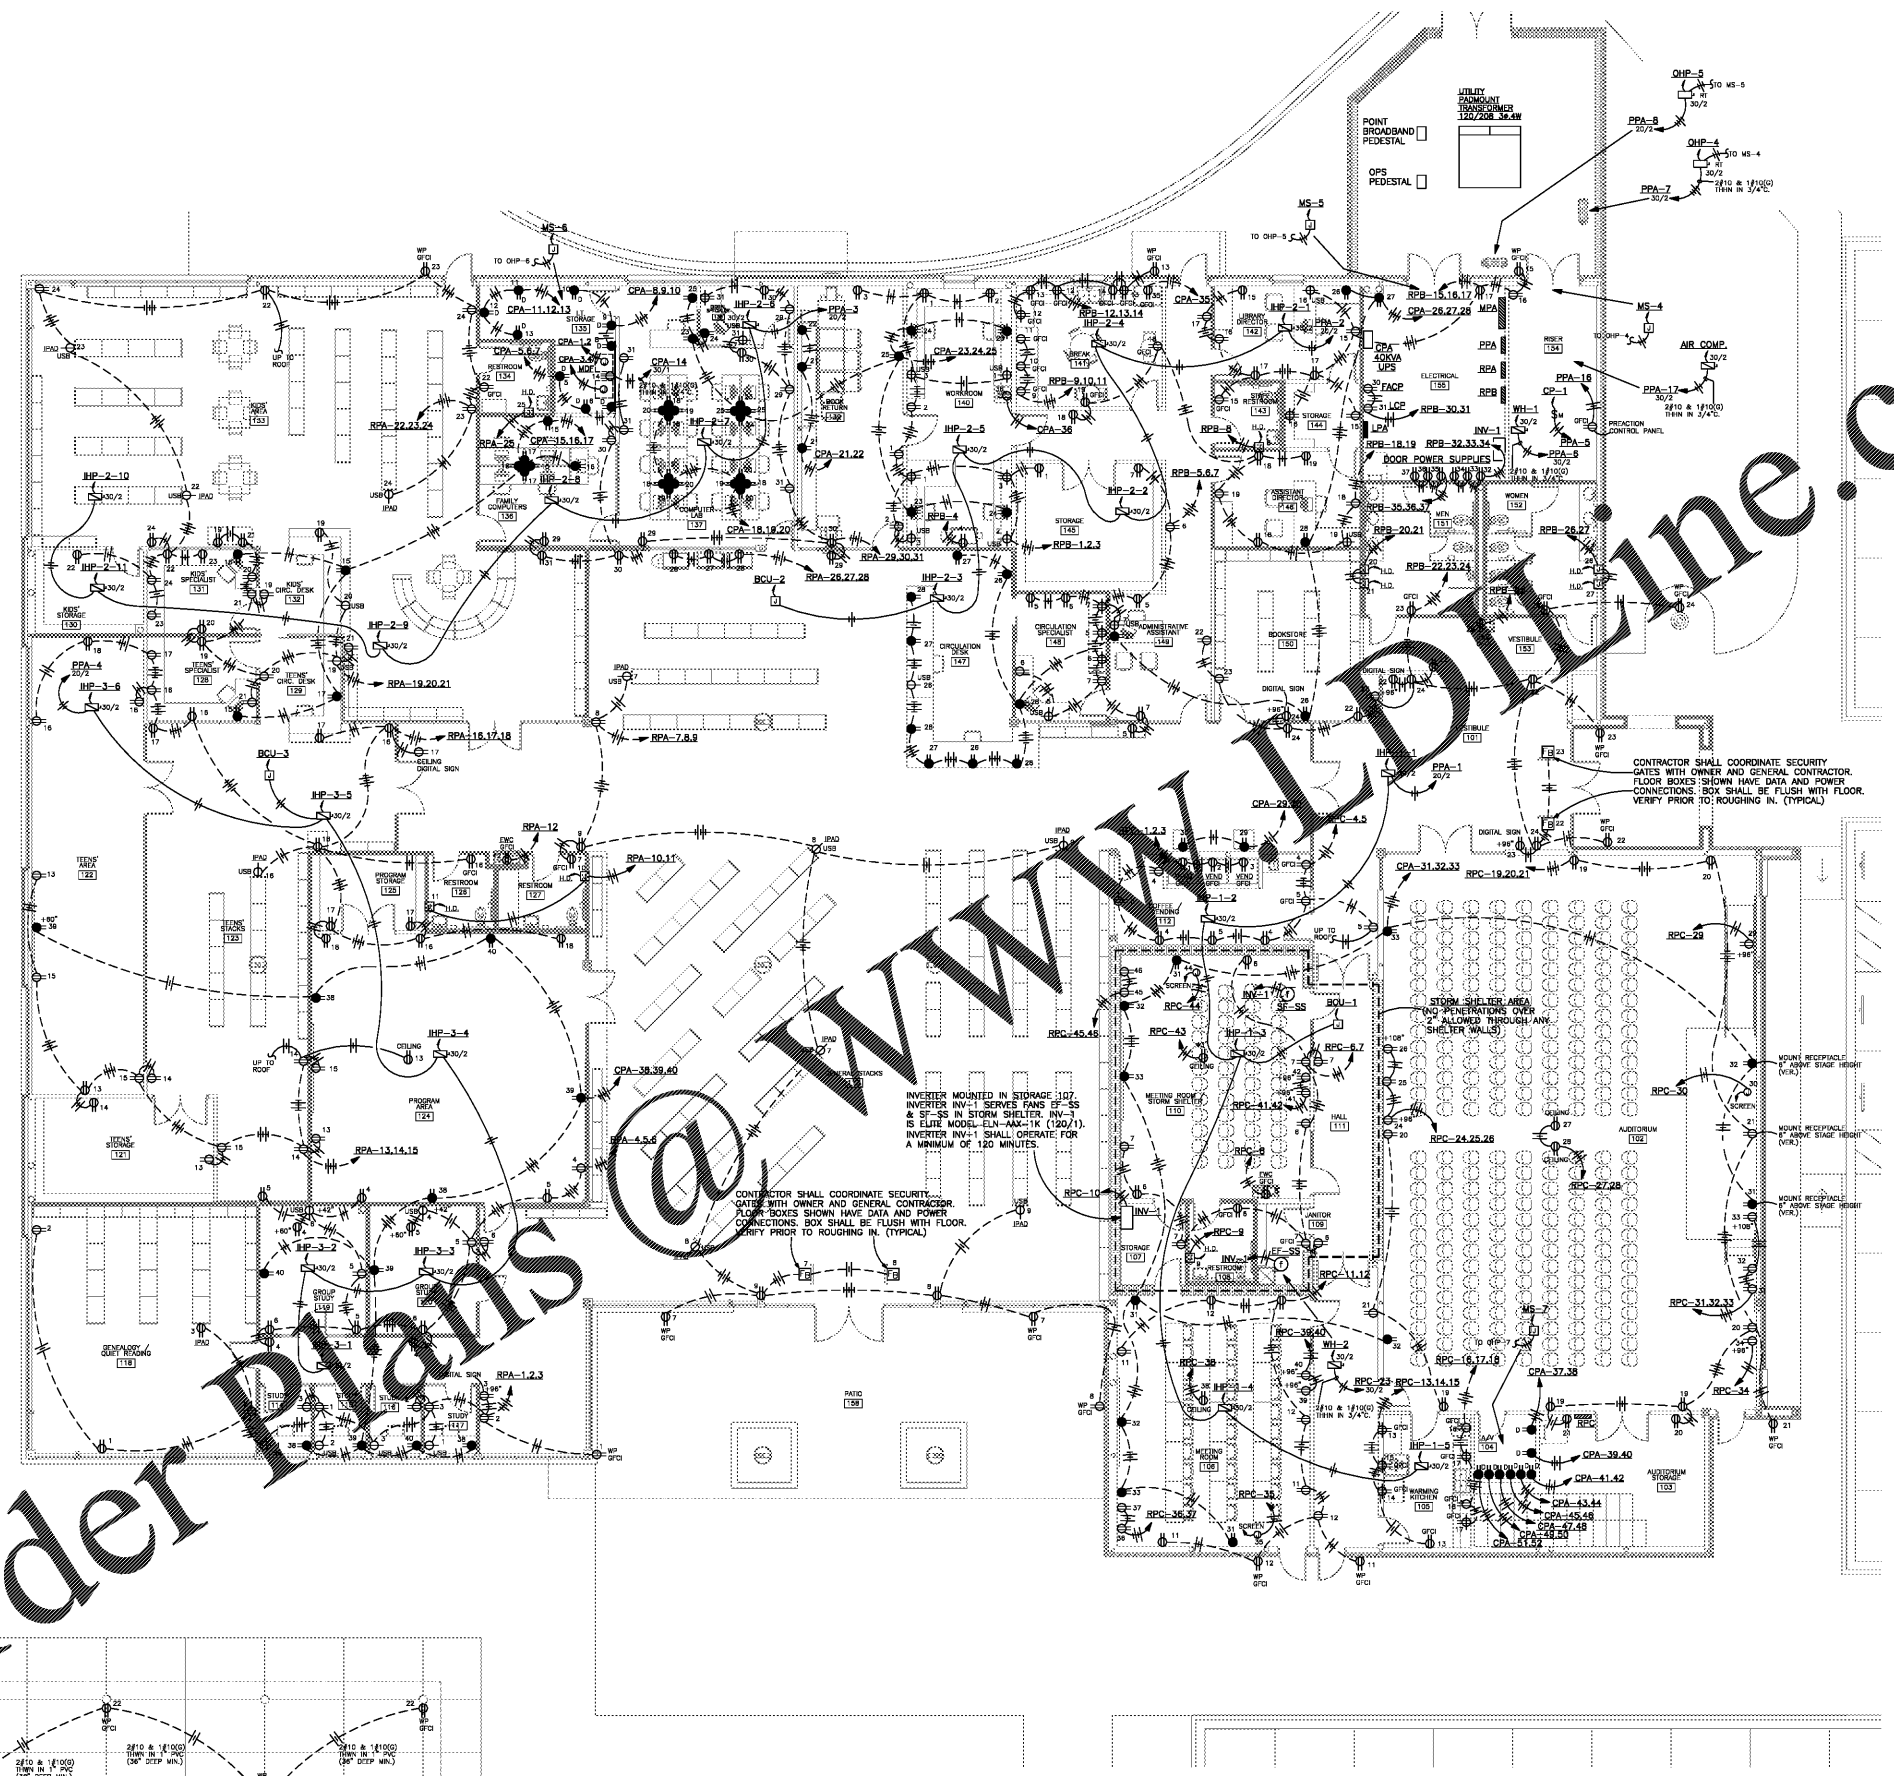

PAVILION PLAN - POWER
 SCALE: 1/8" = 1'-0"

FLOOR PLAN - POWER

SCALE: 1/8" = 1'-0"

- NOTES:
- COORDINATE ALL OUTLETS AT COUNTER AREAS CLOSELY WITH ARCHITECTURAL CASEWORK DRAWINGS. PLACE OUTLETS BELOW COUNTERS, AT STANDARD MOUNTING HEIGHT, WHEN KNEE SPACE PERMITS ACCESS (COORDINATE INSTALLATION OF HOLES WITH RUBBER GROMMETS IN THOSE CASES).
 - COORDINATE INSTALLATION OF OUTLETS CLOSELY WITH FURNITURE SUPPLIER.
 - ALL BRANCH CIRCUIT HOME RUNS THAT EXCEED 100' IN LENGTH SHALL BE #10 THHN.

STEWART ENGINEERING ELECTRICAL CONSULTANTS

P.O. Box 2233 (36202)
 300 East 7th Street (36207)
 Anniston, Alabama
 Phone: 256/237-0891
 Fax No.: 256/237-1077
 Email: services@stewartengineering.org

Engineer:
 J. Lance Junkin, P.E.
 Alabama Reg. 14617

Project Number:
 19122

Order Prints @ www.pdfline.com

www.pdfline.com