



LATHAN ASSOCIATES
ARCHITECTS, P.C.
300 GUNF PARK SOUTH, SUITE 200
HOOPER, ALABAMA 35244
PH. 205-988-9112 FAX 205-988-9188

NEW LIBRARY
FOR THE CITY OF OPELIKA
GLENN STREET
OPELIKA, ALABAMA 36801




SHEET TITLE:
ROOF PLAN -
POWER

PROJ. MGR.: LANCE JUNKIN
DRAWN: SEC
DATE: JUNE 1, 2020
REVISIONS

JOB NO. 19-32

SHEET NO:
E4.2
5 OF 7
SEQUENCE NO:
88/90

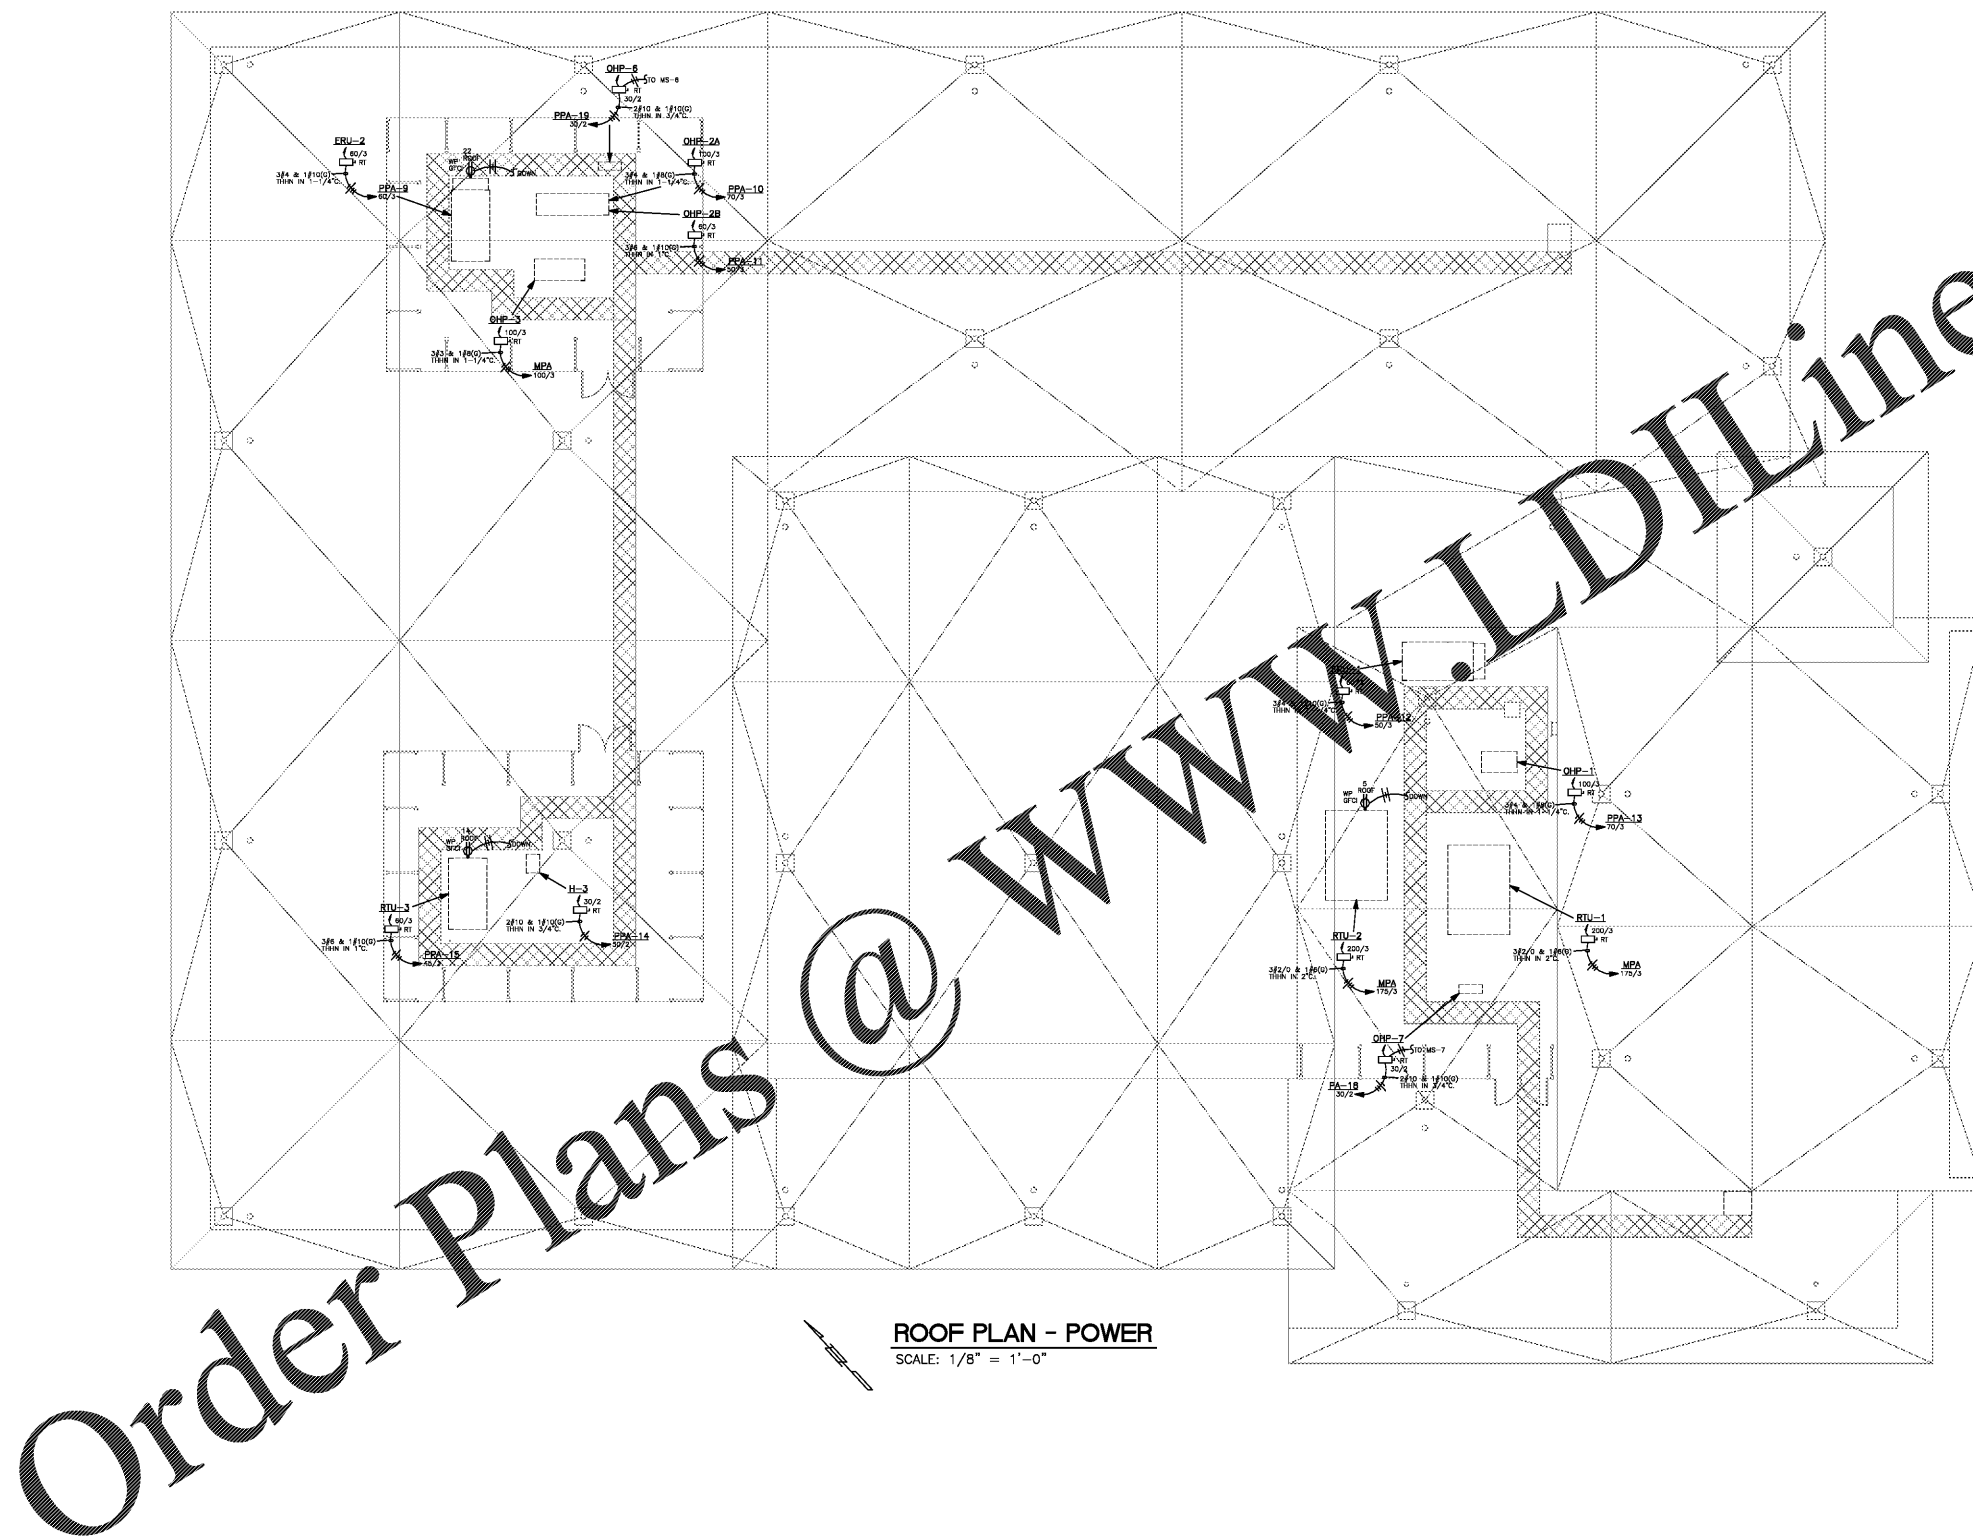

ROOF PLAN - POWER
SCALE: 1/8" = 1'-0"

STEWART ENGINEERING ELECTRICAL CONSULTANTS	
P.O. Box 2233 (36202) 300 East 7th Street (36207) Anniston, Alabama Phone: 256/237-0891 Fax No.: 256/237-1077 Email: services@stewartengineering.org	
Engineer: J. Lance Junkin, P.E. Alabama Reg. 14817	Project Number: 19122

Order Plans @ www.LDILine.com