



LATHAN ASSOCIATES ARCHITECTS, P.C.
300 SHUF PARK SOUTH, SUITE 200
HOOPER, ALABAMA 35244
PH: 205-988-9112 F: 205-988-9188

NEW LIBRARY FOR THE CITY OF OPELIKA
GLENN STREET
OPELIKA, ALABAMA 36801



 


SHEET TITLE:
FLOOR PLAN - AUXILIARIES


PROJ. MGR.: LANCE JUNKIN
DRAWN: SEC
DATE: JUNE 1, 2020
REVISIONS

JOB NO. **19-32**
SHEET NO:

E5.1
6 OF 7
SEQUENCE NO:
89/90

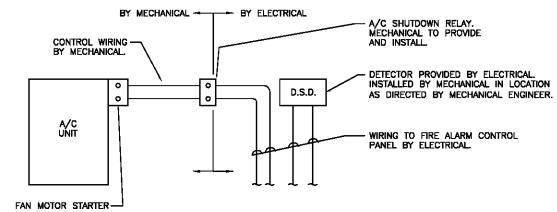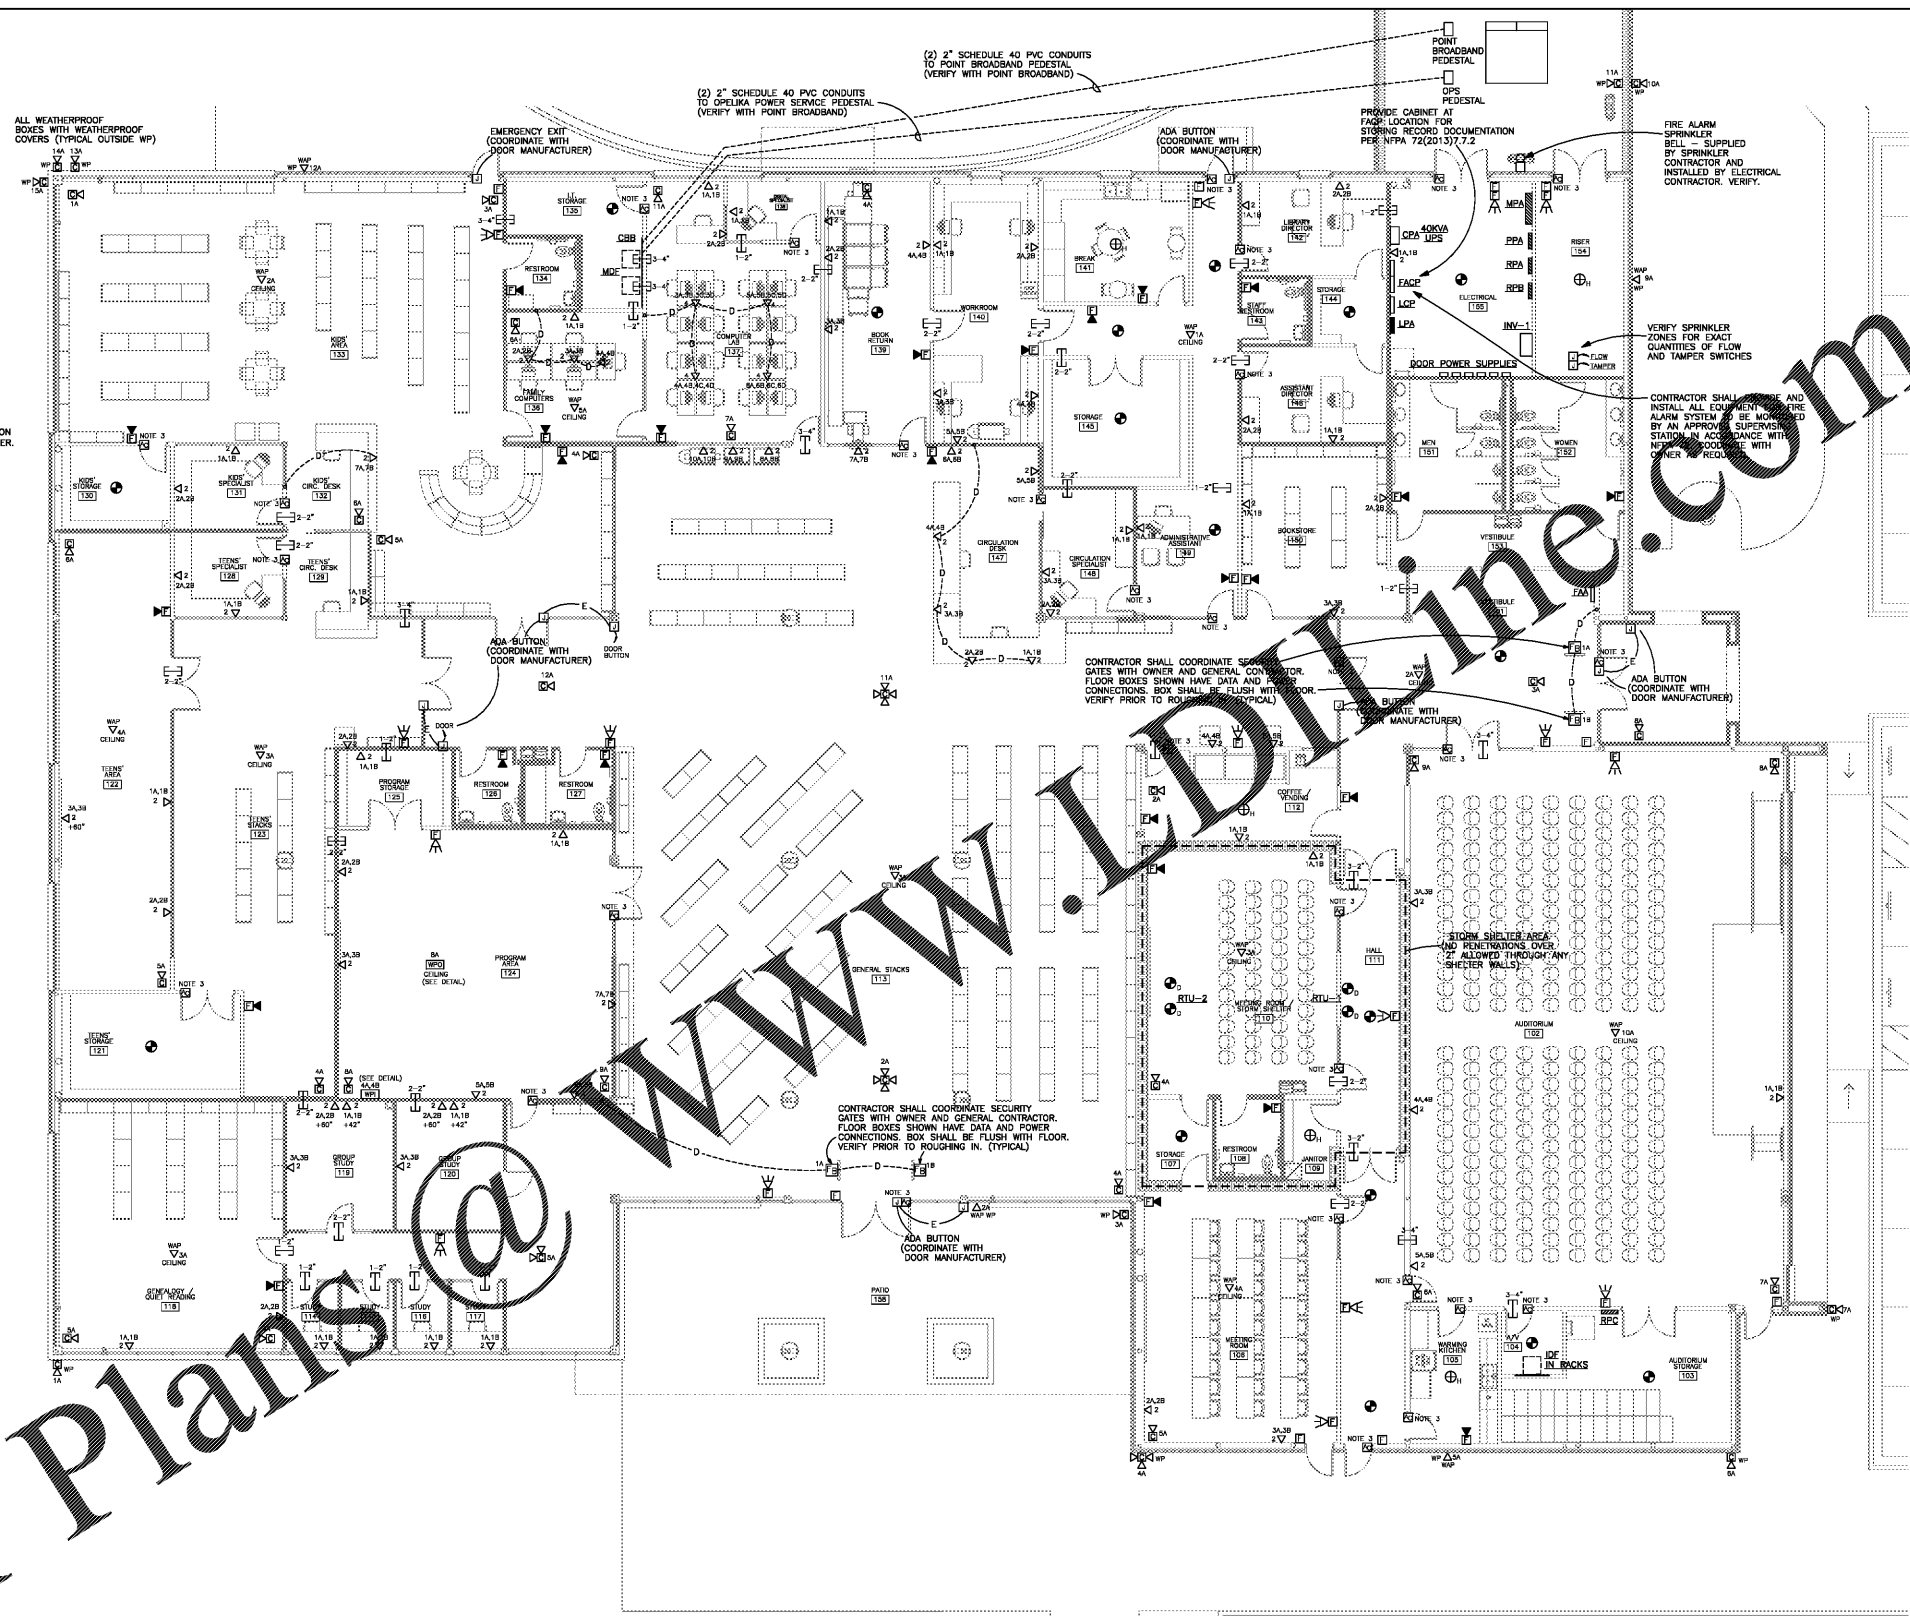

DETAIL - DUCT SMOKE DETECTOR CONNECTION
N.T.S.

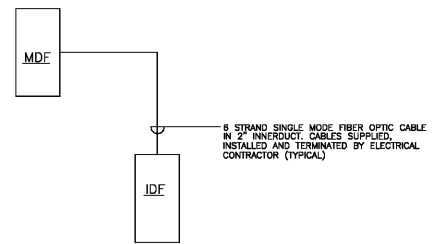


MDF FIBER OPTIC CABLE RISER DIAGRAM
N.T.S.

OUTLET NUMBER:	ROOM NUMBER:
1A	109
IDF NUMBER:	PATCH PANEL/PORT #:
MDF	1/1

DETAIL - DATA CABLE LABEL
N.T.S.

- NOTES:
- LABEL ALL CABLES EVERY 50' AND AT EACH END.
 - EXACT LABEL METHOD SHALL BE COORDINATED WITH, AND APPROVED BY, ENGINEER PRIOR TO PURCHASE AND INSTALLATION.
 - IF ONLY ONE (1) OUTLET IN A ROOM, LABEL OUTLET AS 1A.
 - ROOM NUMBERS ON LABELS SHALL CORRESPOND TO FINAL ROOM NUMBERS IN FIELD (NOT NECESSARILY SAME AS ON CONSTRUCTION DRAWINGS).

Order Plans @ WWW.LDLINE.COM

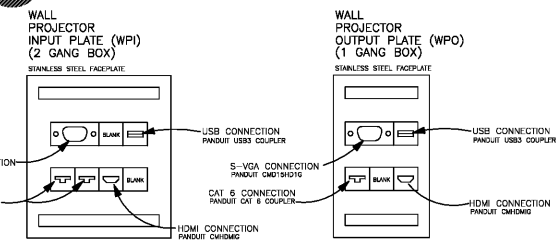

DETAIL - PROJECTOR PLATES
N.T.S. (PROGRAM AREA 124)

FLOOR PLAN - AUXILIARIES
SCALE: 1/8" = 1'-0"

- NOTES:
- ALL COMPUTER OUTLETS SHOWN IN ROOMS 102, 106, AND 110 ARE SERVED FROM IDF. ALL OTHER COMPUTER OUTLETS SHOWN ARE FED FROM MDF.
 - COORDINATE FINAL LOCATIONS OF ALL CEILING SPEAKERS, SMOKE DETECTORS, ETC. TO AVOID CONFLICT WITH LIGHT FIXTURES AND MECHANICAL DIFFUSERS. PLACE THESE DEVICES AS CLOSE AS POSSIBLE TO LOCATION SHOWN ON THESE DRAWINGS. COORDINATE WITH FIRE ALARM SYSTEM MANUFACTURER WITH REGARD TO APPROPRIATE "MINIMUM" DISTANCE FROM DIFFUSERS.
 - ALL ACCESS CONTROL HARDWARE IS BEING SPECIFIED AND PROVIDED UNDER DOOR HARDWARE SPECS. ELECTRICAL CONTRACTOR SHALL COORDINATE ALL WORK AT DOORS WITH DOOR HARDWARE MANUFACTURER. ELECTRICAL CONTRACTOR SHALL WIRE ALL POWER SUPPLIES, DOOR DEVICES, ETC. AS REQUIRED FOR A COMPLETE WORKING ELECTRIC DOOR RELEASE SYSTEM. COORDINATE CLOSELY WITH ARCHITECT.
 - ALL FIRE ALARM DEVICES SHALL BE WHITE IN COLOR.

STEWART ENGINEERING ELECTRICAL CONSULTANTS

P.O. Box 2233 (36202)
300 East 7th Street (36207)
Ardmore, Alabama
Phone: 256/237-0891
Fax No.: 256/237-1077
Email: services@stewartengineering.org

Engineer: J. Lance Junkin, P.E. Alabama Reg. 14617
Project Number: 19122