




LATHAN ASSOCIATES
ARCHITECTS, P.C.
300 SHAW PARK SOUTH, SUITE 200
HOOVER, ALABAMA 35244
PH: 205-988-9112 FAX: 205-988-9188

NEW LIBRARY
FOR THE CITY OF OPELIKA
GLENN STREET
OPELIKA, ALABAMA 36801

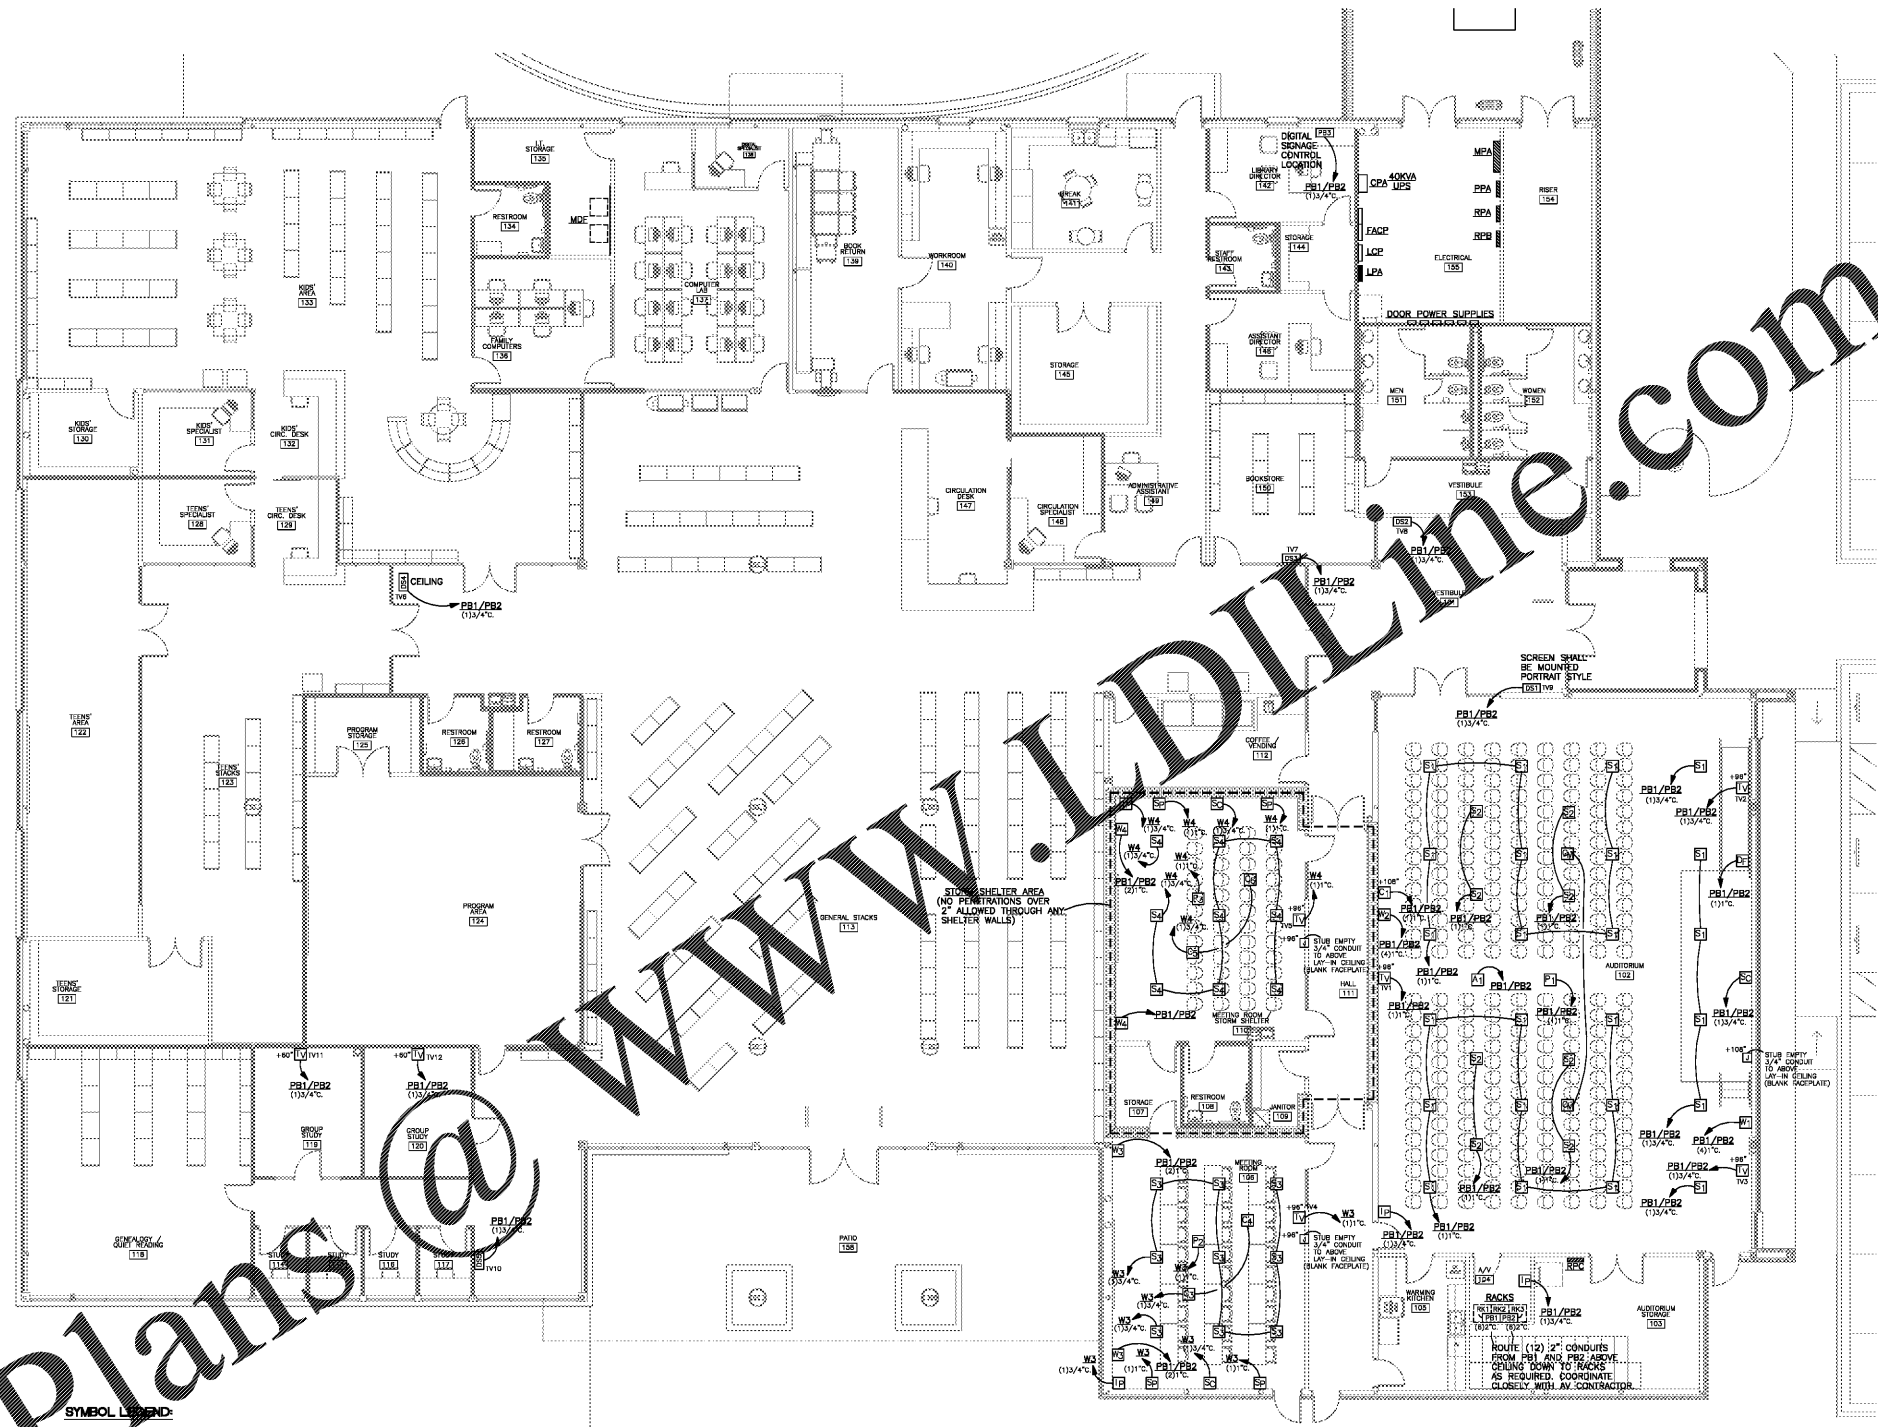

Order Plans @ WWW.DIline.com

- SYMBOL LEGEND:**
- (R1) SOUND SYSTEM - MAIN AV RACK - SEE SPEC.
 - (R2) SOUND SYSTEM - MAIN PULL BOX - SEE SPEC.
 - (B) SOUND SYSTEM - WALL BOX - SEE SPEC.
 - (S) SOUND SYSTEM - CEILING SPEAKER - SEE SPEC.
 - (A) SOUND SYSTEM - WIRELESS MIC ANTENNA - SEE SPEC.
 - (IP) SOUND SYSTEM - IPAD STATION - SEE SPEC.
 - (TV) SOUND SYSTEM - TV OUTLET - SEE SPEC.
 - (C) SOUND SYSTEM - CAMERA OUTLET - SEE SPEC.
 - (PO) SOUND SYSTEM - PROJECTOR OUTLET - SEE SPEC.
 - (PS) SOUND SYSTEM - PROJECTOR SCREEN OUTLET - SEE SPEC.
 - (WS) SOUND SYSTEM - WALL MOUNTED SPEAKER - SEE SPEC.
 - (EB) SOUND SYSTEM - EMPTY BOX FOR CEILING MOUNT DEVICE - SEE SPEC.
 - (DT) SOUND SYSTEM - DIGITAL SIGN TV - SEE SPEC.

FLOOR PLAN - AV SYSTEMS
SCALE: 1/8" = 1'-0"

- NOTES:**
- ELECTRICAL CONTRACTOR SHALL COORDINATE CLOSELY WITH AV SYSTEMS CONTRACTOR AND INSTALL COMPLETE AV SYSTEM AS REQUIRED.
 - AV SYSTEMS CONTRACTOR SHALL SUBMIT SHOP DRAWINGS THAT SHOW IN DETAIL ALL WORK TO BE INSTALLED. THIS SHALL INCLUDE ALL BOXES, CONDUITS, WIRING, ETC. ELECTRICAL CONTRACTOR IS RESPONSIBLE FOR ENTIRE AV SYSTEM.

**STEWART ENGINEERING
ELECTRICAL CONSULTANTS**

P.O. Box 2233 (36202)
300 East 7th Street (36207)
Ardmore, Alabama
Phone: 256/237-0891
Fax No.: 256/237-1077
Email: services@stewartengineering.org

Engineer:
J. Lance Junkin, P.E.
Alabama Reg. 14817

Project Number:
19122



SHEET TITLE:
FLOOR PLAN -
AV SYSTEMS

PROJ. MGR.: LANCE JUNKIN
DRAWN: SEC
DATE: JUNE 1, 2020
REVISIONS

JOB NO. **19-32**
SHEET NO:
E5.2
7 OF 7
SEQUENCE NO:
90/90

