



PHOTOMETRIC STUDY					
DESCRIPTION	AVG	MAX	MIN	MAX/MIN	AVG/MIN
PARKING LOT	3.34	6.47	1.05	6.13	3.17
PROPERTY LINE	0.10	0.43	0.01	46.89	11.25
ATM - 5FT RADIUS	37.00	53.36	25.59	2.09	1.45
ATM - 60 FT RADIUS	15.08	53.36	2.68	19.88	5.62

LUMINAIRE SCHEDULE									
SYMBOL	LABEL	MTG HT	CATALOG #	DESCRIPTION	LAMP	FILE	LUMENS	LFE	WATTS
□	PL2H	25'-0"	GLEON-AF-04-LED-E1-SL4-HSS	L.E.D. AREA LIGHT	L.E.D.	GLEON-AF-04-LED-E1-SL4-HSS.ies	24062	0.90	225
□	PL3	25'-0"	GLEON-AF-02-LED-E1-SL3-HSS	L.E.D. AREA LIGHT	L.E.D.	GLEON-AF-02-LED-E1-SL3-HSS.ies	12460	0.90	113
□	PL4	25'-0"	GLEON-AF-06-LED-E1-SL4-HSS	L.E.D. AREA LIGHT	L.E.D.	GLEON-AF-04-LED-E1-SL4-HSS.ies	34605	0.90	333
□	PL4H	25'-0"	GLEON-AF-06-LED-E1-SL4-HSS	L.E.D. AREA LIGHT	L.E.D.	GLEON-AF-04-LED-E1-SL4-HSS.ies	34605	0.90	333

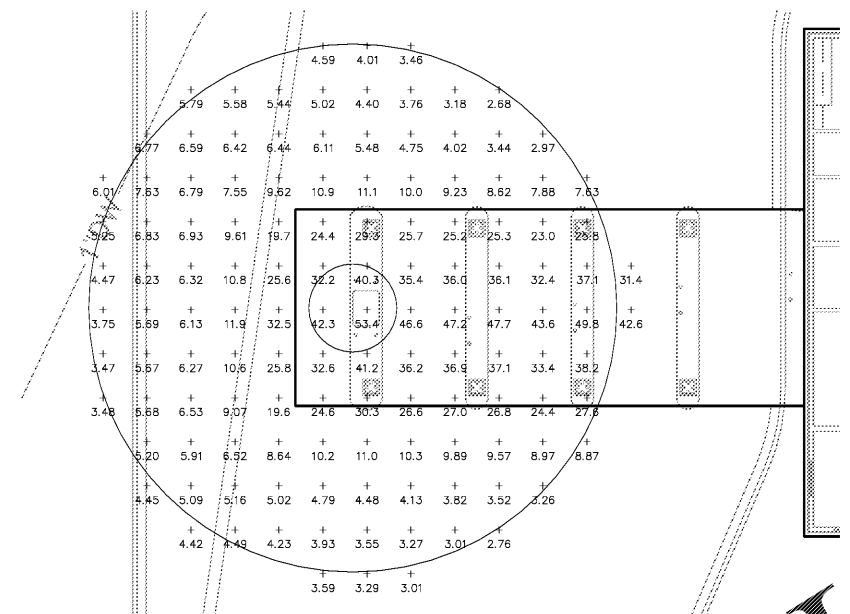

ATM - PHOTOMETRICS  
 SCALE: 1" = 10'-0"

Order Plans @

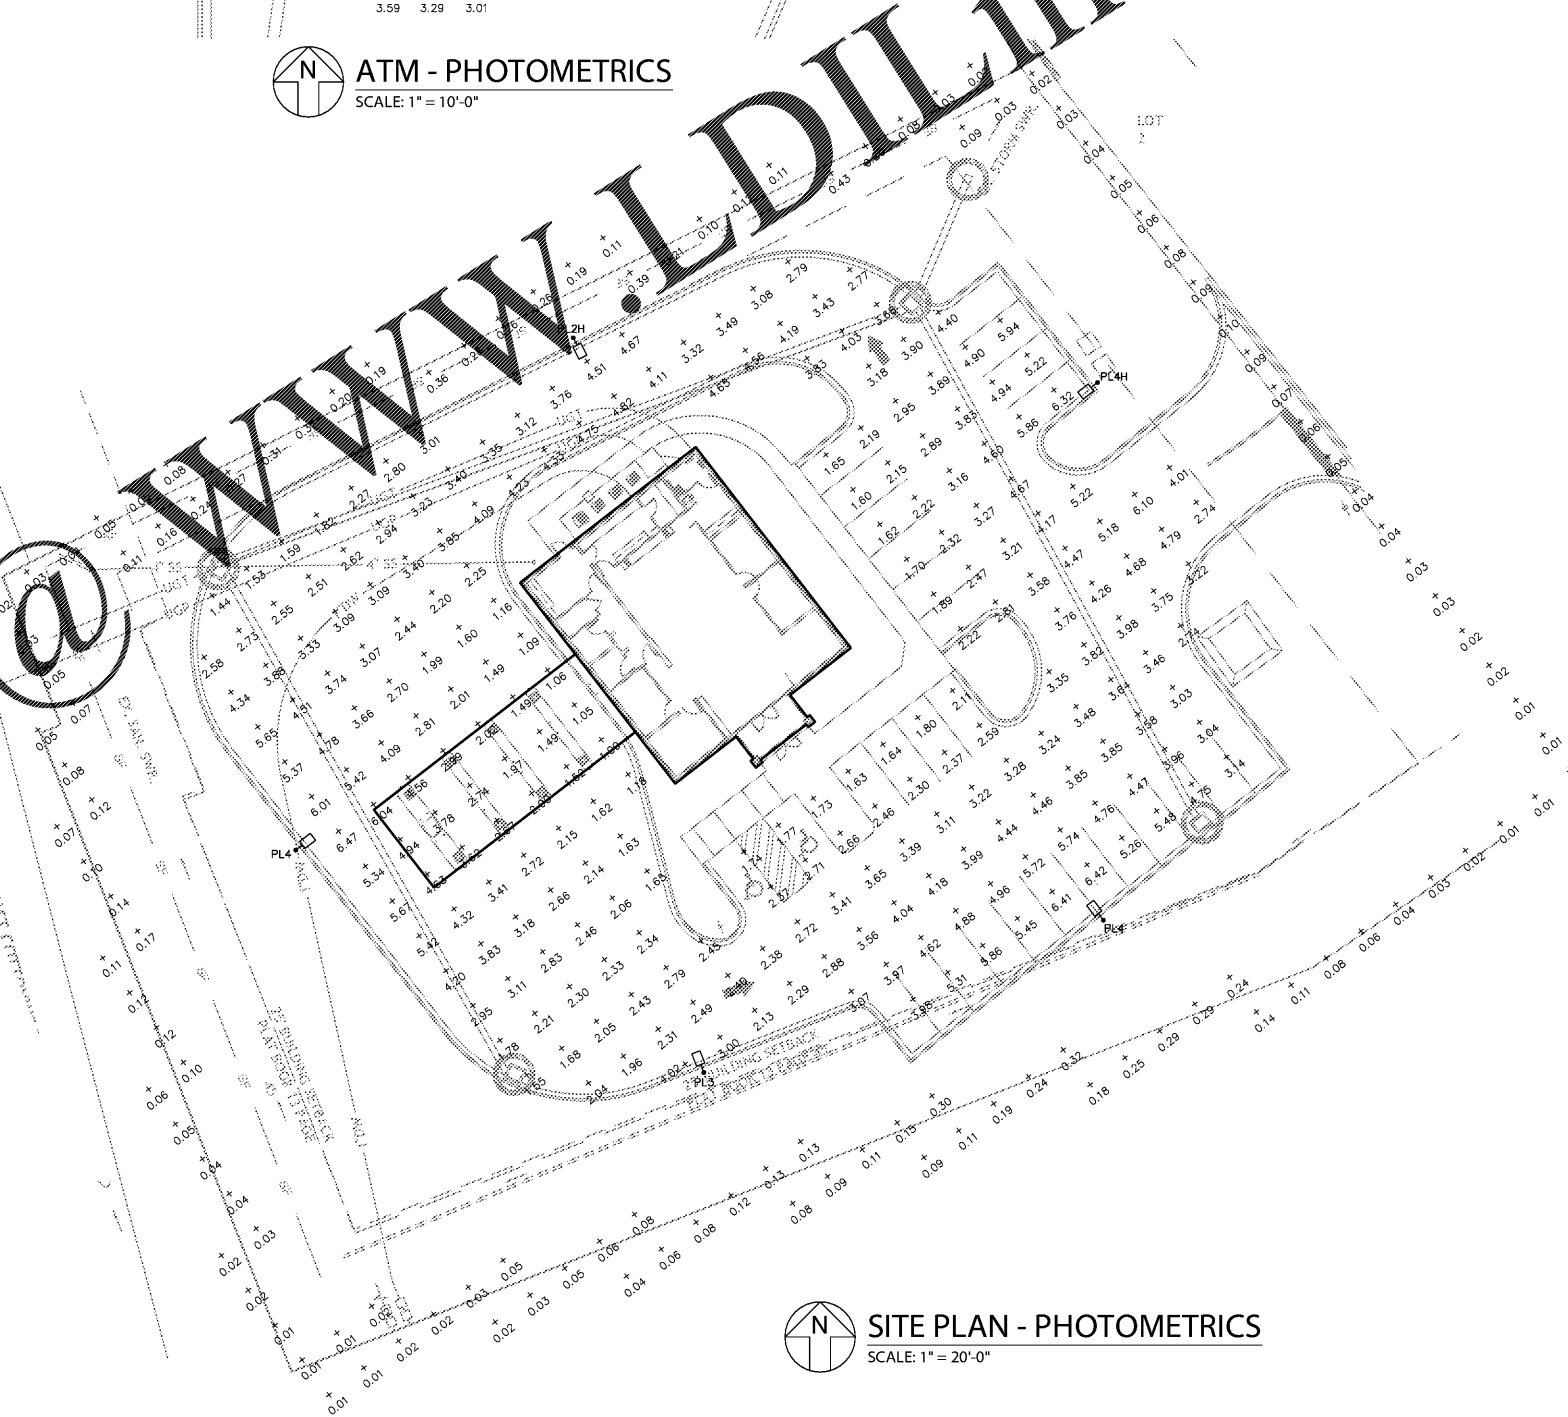

SITE PLAN - PHOTOMETRICS  
 SCALE: 1" = 20'-0"

TYPE 'PL2H', 'PL3', 'PL4', & 'PL4H'  
 SCALE: NONE

RELEASES / DESCRIPTION / DATES	
NOT FOR CONSTRUCTION	<input type="checkbox"/>
RELEASED FOR CONSTRUCTION	<input checked="" type="checkbox"/>
DATE	06.23.2020
DRAWN	---
CHECKED	---
APPROVED	HHHA
PROJECT NUMBER	20012.01
SHEET TITLE	SITE PLAN - PHOTOMETRICS
DRAWING NO.	E1.02

A New Branch Bank for  
**Tyndall**  
 FEDERAL CREDIT UNION  
 Dothan, Alabama