


This document, together with the concepts and designs presented herein, as an instrument of service, is intended only for the specific purpose and client for which it was prepared. Reuse of and improper reliance on this document without written authorization and adaptation by Kimley-Horn and Associates, Inc. shall be without liability to Kimley-Horn and Associates, Inc.

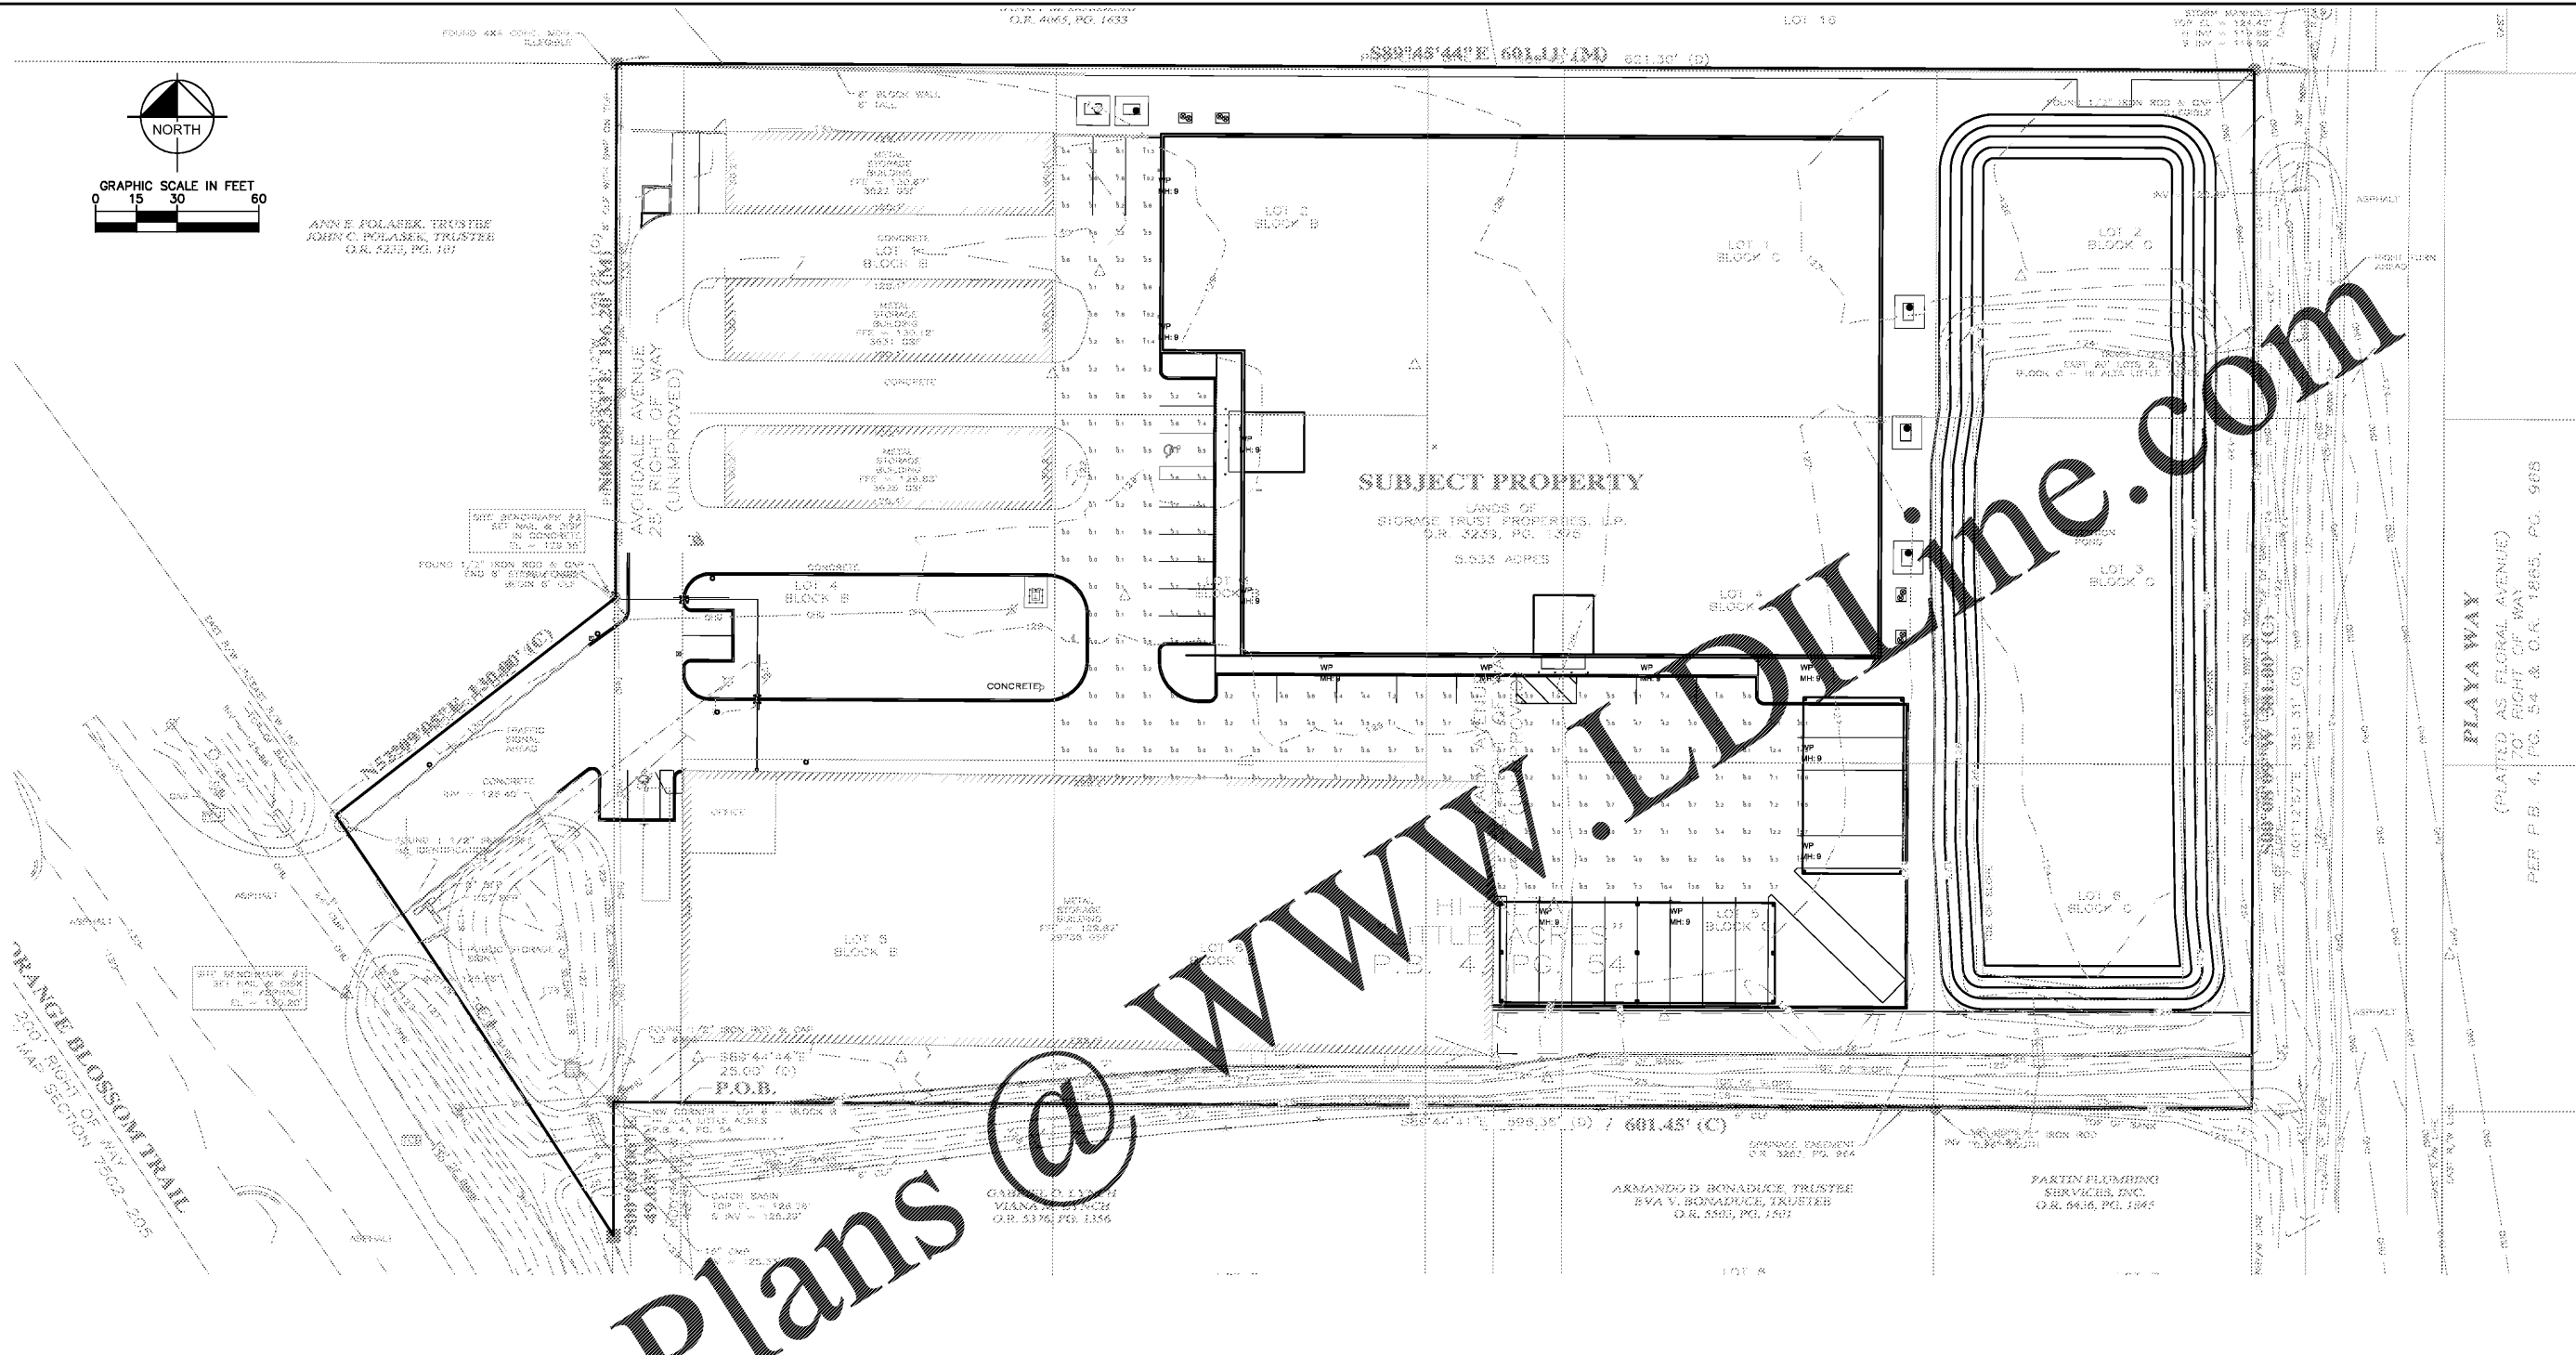

Order Plans @ WWW.KIMLEY-HORN.COM

Lighting Partners of CF Luminaire Schedule

Symbol	Qty	Label	Lum. Watts	Num. Lumens	CF	Manufacturer	Part Number	BUG Rating
WP	12	WP	113	12,177	0.912	EATON - MCGRAW-EDISON (FORMER COOPER LIGHTING)	GWC-AF-02-LED-E1-T4FT	B2-U0-G3

Calculation Summary

Label	CalcType	Units	Avg	Max	Min	Avg/Min	Max/Min
SITE LIGHTING	Illuminance	Fc	1.73	20.1	0.0	N.A.	N.A.
CALCS	Illuminance	Fc	3.20	20.1	0.0	N.A.	N.A.

No.	REVISIONS	DATE	BY

Kimley»Horn
 © 2020 KIMLEY-HORN AND ASSOCIATES, INC.
 445 24TH STREET, SUITE 200, VERO BEACH, FL 32960
 PHONE: 772-794-1100
 WWW.KIMLEY-HORN.COM CA 00000696

Licensed Professional
 CHRISTOPHER J. HOLLEN, P.E.
 FLORIDA LICENSE NUMBER: 74685
 DATE: _____
 CHECKED BY: C/JH

PHOTOMETRIC PLAN

PUBLIC STORAGE APOPKA
 2431 S. ORANGE BLOSSOM TRAIL
 SEMINOLE COUNTY, FLORIDA

SHEET NUMBER
P-100

