


NORTH

FLOOR PLAN - LIGHTING
 SCALE: 1/4" = 1' - 0"

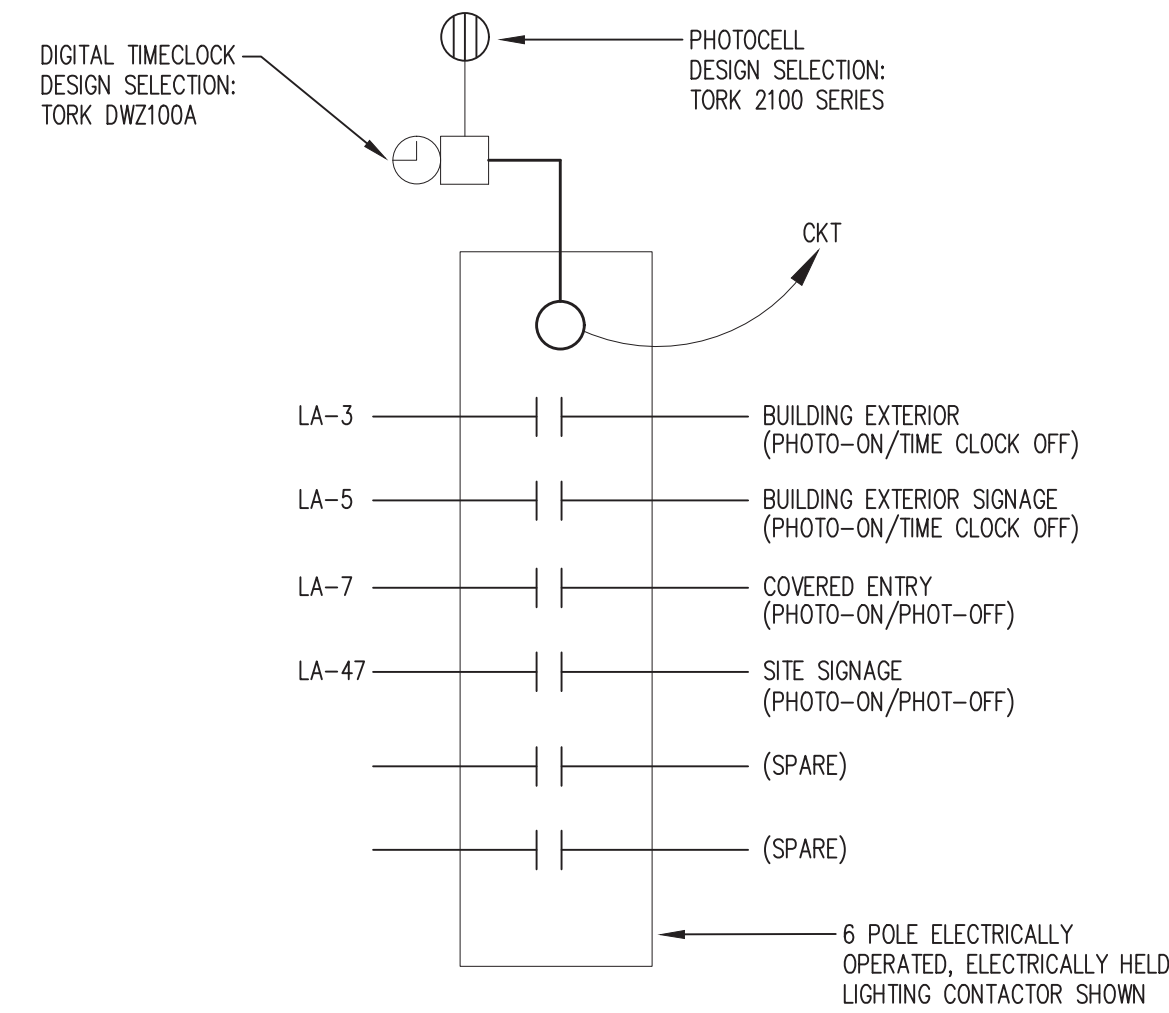

LIGHTING CONTACTOR DETAIL

NO SCALE

GENERAL NOTES:

1. PROVIDE POWER PACKS AS REQUIRED FOR OCCUPANCY SENSORS.
2. ALL WALL MOUNTED OCCUPANCY SENSORS ARE MANUAL ON/AUTOMATIC OFF.
3. PROVIDE ALL LOW VOLTAGE CONTROL CABLING FOR LIGHTING, PLENUM RATED.
4. PROVIDE SEPARATE NEUTRAL FOR EACH 120V BRANCH CIRCUIT.

WORK NOTES:

- 1 DISCONNECTING MEANS MOUNTED AT BUILDING SIGNAGE. SWITCH TO BE ACCESSIBLE, EITHER INCORPORATED INTO OR ADJACENT TO SIGNAGE, NOT IN DIRECT LINE OF SIGHT FROM GROUND LEVEL. COORDINATE LOCATION WITH SIGN INSTALLER PRIOR TO ROUGH-IN AND CONNECT SIGN FOR OPERATION.
- 2 WIRE CIRCUIT THRU PHOTO-CELL FOR DUSK TO DAWN OPERATION.

CALIBER CAPITAL CARWASH
 LAKE WALES, FLORIDA

FLOOR PLAN - LIGHTING

CONN + ARCHITECTS
 Tallahassee, Florida 32308 | 850-878-8784
 1950-C Buford Boulevard | Tallahassee, Florida 32308
 www.CONNarchitects.com | LIC. NO. AA-C001652

DATE
APRIL 28, 2020

DRAWN BY
MRC/JML

REVISED

JOB NO.
19-249-1

James M. Lamb
 Professional Engineer, License No. 52688

APPLIED RESEARCH AND DESIGN, INC.
 2623 S. BLAIRSTONE ROAD
 TALLAHASSEE, FL 32301
 FL CA#8948
 JAMES M. LAMB, PE#52688
 Tel: (850) 668-6324 -- E-mail: jmlamb@ard-eng.com

SHEET NUMBER
E1.2