


COPYRIGHT © 2019 CONN + ASSOCIATES, INC. ALL RIGHTS RESERVED. PRINTED IN THE UNITED STATES OF AMERICA.  
 NO PART OF THESE DOCUMENTS MAY BE REPRODUCED, STORED IN A RETRIEVAL SYSTEM, OR TRANSMITTED, IN ANY FORM OR BY ANY MEANS, WITHOUT THE WRITTEN PERMISSION OF CONN + ASSOCIATES, INC.



REFER TO SHEETS E0.3 & E0.4 FOR CAR WASH EQUIPMENT INFORMATION.

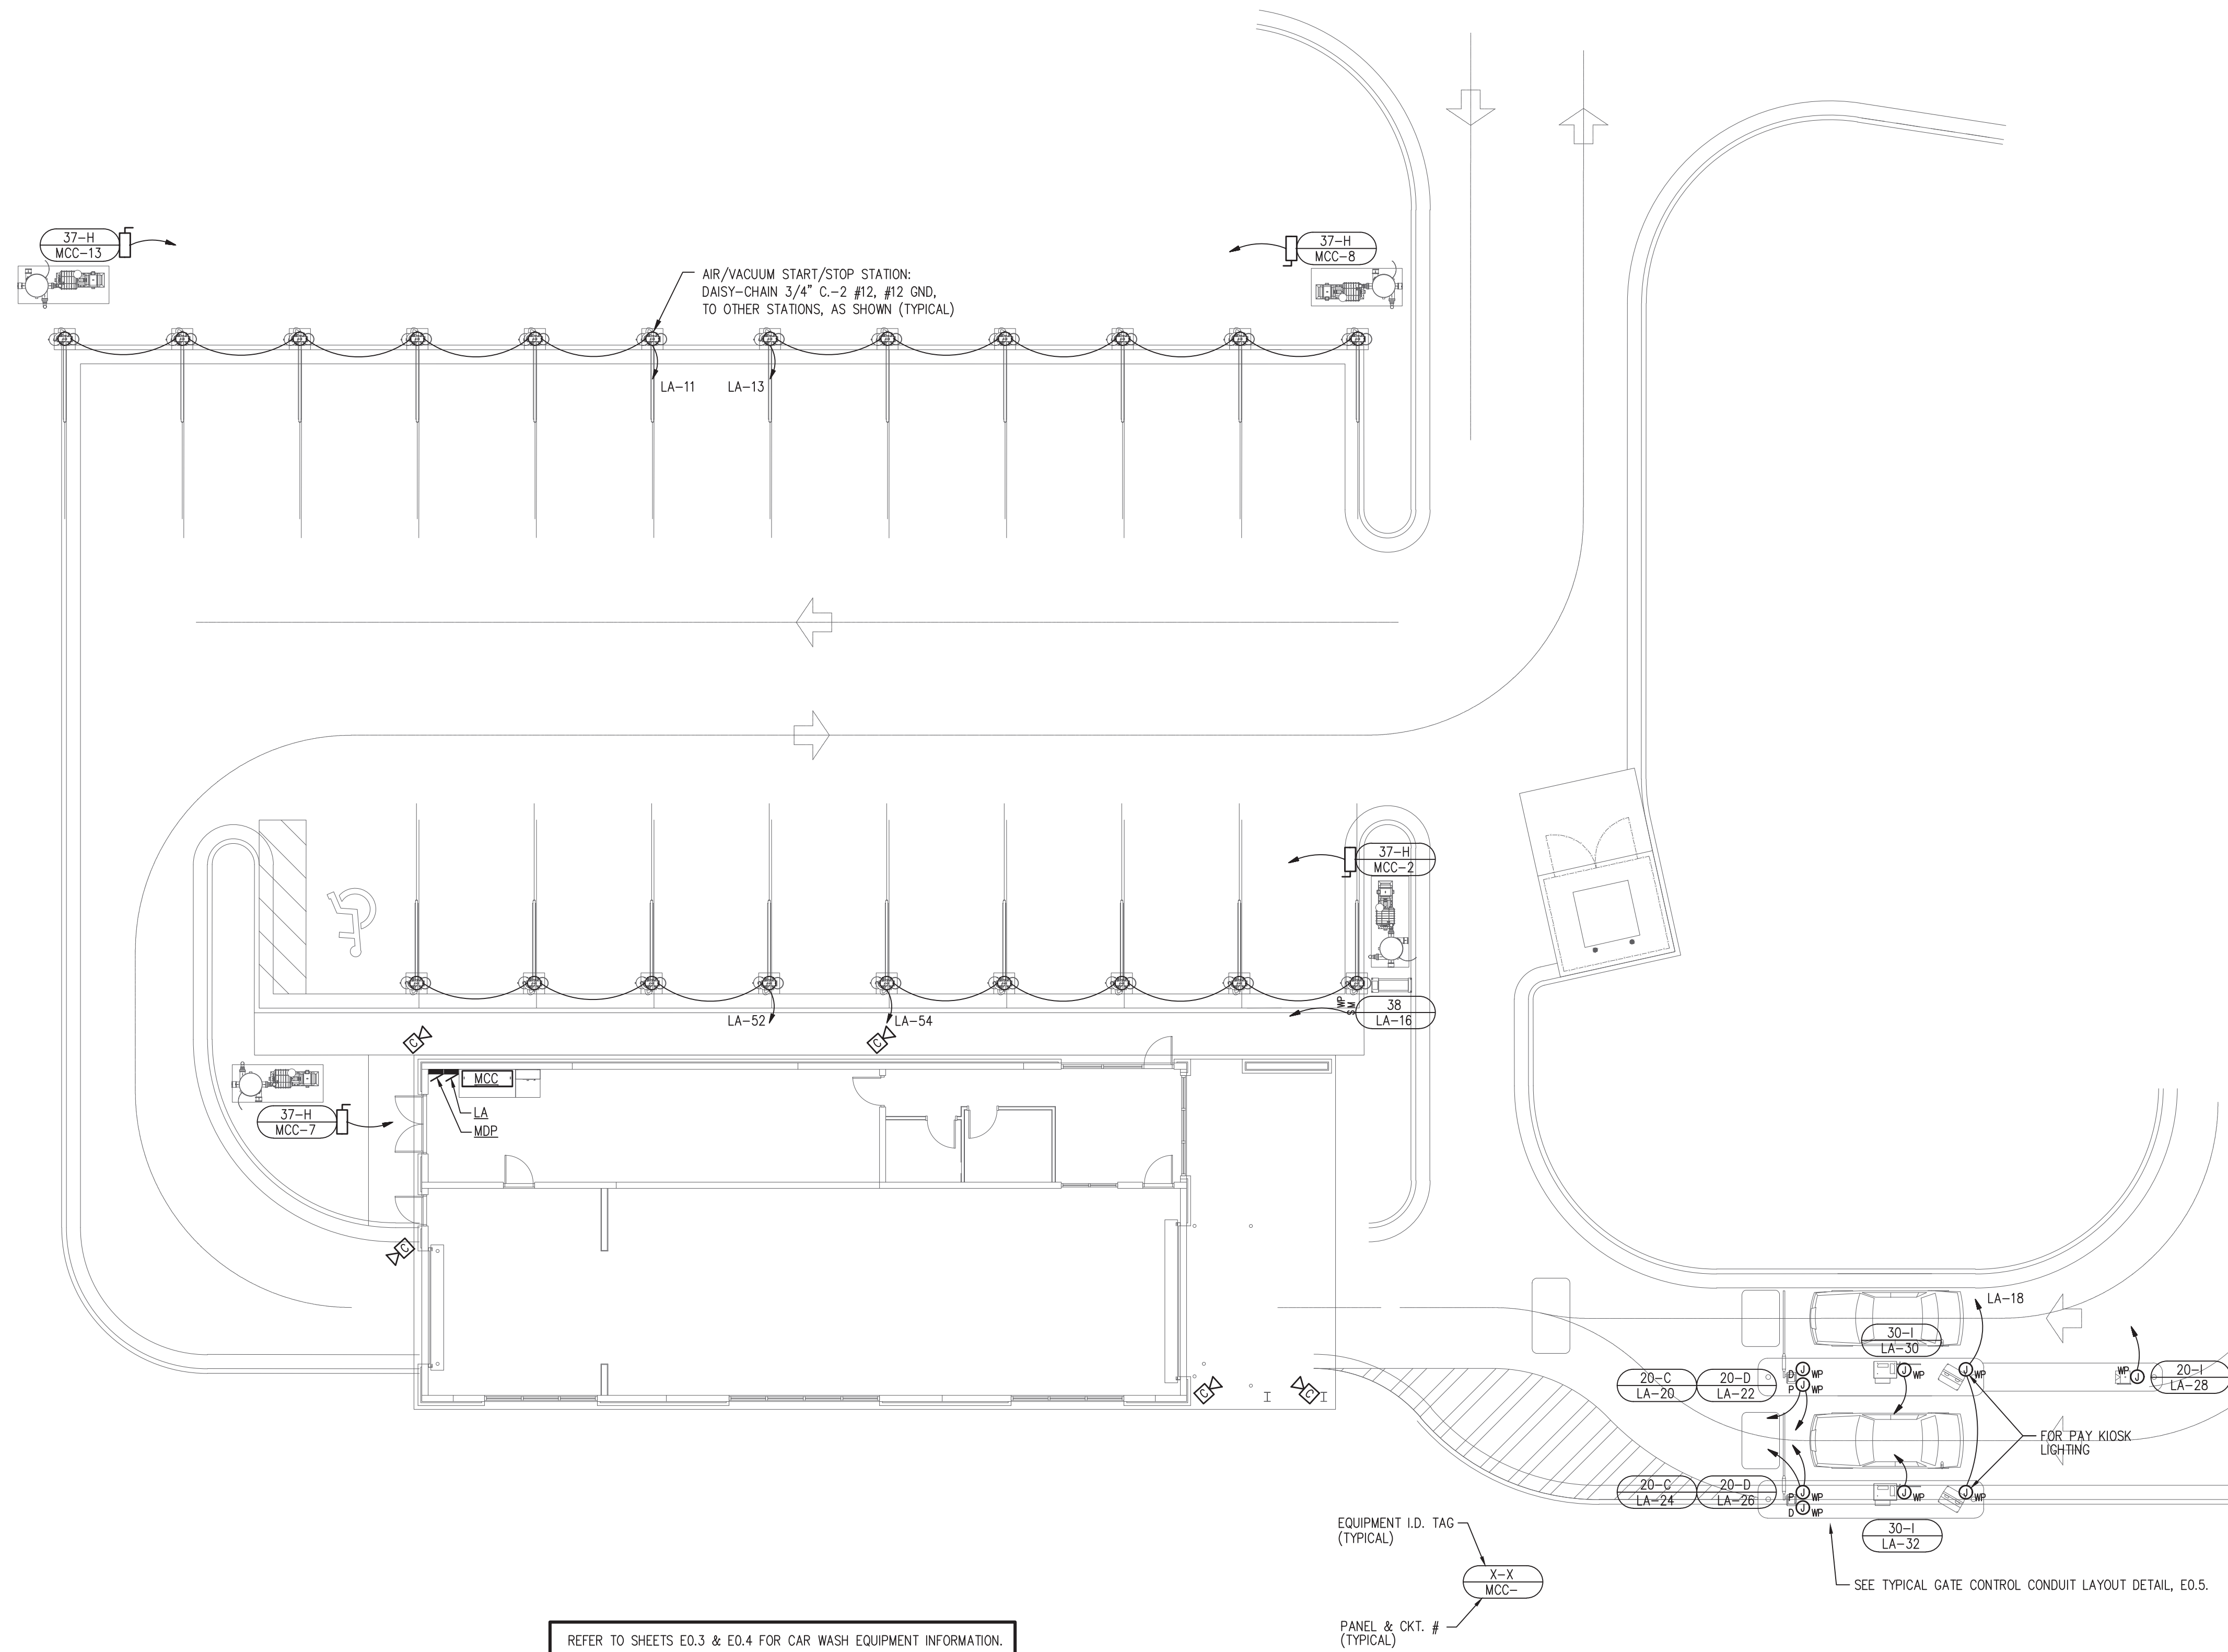

## SITE PLAN EQUIPMENT - ELECTRICAL

SCALE: 3/32" = 1' - 0"

EQUIPMENT I.D. TAG  
(TYPICAL)  
X-X  
MCC-

PANEL & CKT. #  
(TYPICAL)

### GENERAL NOTES:

1. PROVIDE DEDICATED NEUTRAL WITH ALL 120V BRANCH CIRCUITS.
2. EQUIPMENT IS BASED ON EQUIPMENT INFORMATION PROVIDED AT THE TIME OF DESIGN. CONTRACTOR SHALL VERIFY FINAL EQUIPMENT SELECTIONS AND REQUIREMENTS (INCLUDING ROUGH-IN LOCATIONS, ELEVATIONS, CONNECTION REQUIREMENTS, DISCONNECT REQUIREMENTS, ETC.) AND LAYOUT INFORMATION AT ROUGH-IN; NOTIFY ENGINEER OF ANY DISCREPANCIES.
3. SEE E1.0 FOR ADDITIONAL SITE ELECTRICAL WORK.
4. SEE VENDOR SHOP DRAWINGS FOR LOW-VOLTAGE DEVICE WIRING REQUIREMENTS, ADDITIONAL EQUIPMENT ROUGH-IN REQUIREMENTS, AND DETAILS.

ARD PROJECT #0052  
**APPLIED RESEARCH AND DESIGN, INC.**  
 2623 S. BLAIRSTONE ROAD  
 TALLAHASSEE, FL 32301  
 FL CA#8948  
 JAMES M. LAMB, PE#52688  
 Tel: (850) 668-6324 -- E-mail: jlamb@ard-eng.com

CALIBER CAPITAL CARWASH  
 LAKE WALES, FLORIDA

SITE PLAN EQUIPMENT - ELECTRICAL

**CONN + ARCHITECTS**  
 Tallahassee, Florida 32308 | 850-878-8784  
 www.connarchitects.com | Lic. No. AA-C001652

DATE  
APRIL 28, 2020

DRAWN BY  
MRC/JML

REVISED

JOB NO.  
19-249-1

James M. Lamb  
Professional Engineer, License No. 52688

This item has been digitally signed and sealed by James M. Lamb on the date indicated here. Printed copies of this document are not considered signed and sealed and the signature must be verified on any electronic copies.

SHEET NUMBER  
E1.4