

CONSTRUCTION NOTES
 THIS SHEET ONLY


- ALL DIMENSIONS ARE FINISH DIMENSIONS U.N.O.
- ALL NEW SUSPENDED CEILING SHALL BE AT HEIGHTS AND LOCATIONS INDICATED ON PLANS.
- DIFFUSERS AND GRILLES SHALL MATCH CORRESPONDING CEILING COLOR U.N.O.
- ALL CEILING GRIDS SHALL BE CENTERED IN ROOMS, UNLESS OTHERWISE NOTED.
- CEILING HEIGHT TO BE BASED UPON HIGH POINT IN SLAB WITHIN SPACE. CONTRACTOR TO VERIFY IN FIELD.
- CEILING GRID SYSTEMS SHALL BE INSTALLED WITHOUT VISIBLE FASTENERS FROM BELOW, TYP.
- FOR LIGHTING SPECIFICATIONS - SEE ELECTRICAL FIXTURE SCHEDULE.
- SEE SHEET 30.01 FOR FINISH SCHEDULE.
- LIGHTS TO BE CENTERED IN ACOUSTICAL CEILING TILE, UNLESS NOTED OTHERWISE.
- RESET SPRINKLER LAYOUT WITHIN EACH SPACE. IN GENERAL, (1) HEAD PER 10'-0" x 10'-0" (100 SF). NO CLOSER THAN 2'-0" FROM WALL.
- SECURITY GATES ARE TO BE FURNISHED AND INSTALLED BY SECURITY GATE CONTRACTOR. SECURITY CONTRACTOR SHALL COORDINATE ALL FINAL CONNECTIONS WITH GATE MANUFACTURER AND ELECTRICAL CONTRACTOR FOR A COMPLETE AND OPERATIONAL SYSTEM. SECURITY GATE TO BE INSTALLED PER MANUFACTURER'S REQUIREMENTS.
- EXISTING SUB-STRUCTURE TO BE PAINTED P-1c (ITEM C1) AND SPRAYED ACOUSTICAL FINISH (ITEM C-1, K13). CONTRACTOR TO CONFIRM WITH LOCAL CODES IF EXISTING SUB-STRUCTURE MUST MAINTAIN SPECIFIC FIRE RATING. INSTALLING NEW OR PATCHING EXISTING FIRE PROOFING MAY BE REQUIRED.

LEGEND
 THIS SHEET ONLY


- EXISTING WALL/CEILING/HVAC/LIGHTING, ETC TO REMAIN.
 - LOCATION OF NEW WALL TO BE CONSTRUCTED
- KEYNOTES**
 THIS SHEET ONLY
- ROLL-DOWN PERFORATED ALUMINUM SECURITY GATE WITH RECESSED RAILS MOUNTED ON STEEL BRACKETS AND ATTACHED TO VERTICAL STEEL TUBES ENGINEERED AND FURNISHED BY SECURITY GATE MANUFACTURER. SEE ROLLING GRILL SECTION ON SHEET 31.02 FOR ADDITIONAL INFORMATION.
 - GYPSUM BOARD BULKHEAD.
 - EXIT LIGHT/SIGN - SEE ELECTRICAL DRAWINGS FOR ADDITIONAL INFORMATION.
 - SUSPENDED 2' x 2' ACOUSTICAL CEILING TILE CEILING. REFER TO PLAN FOR CEILING HEIGHTS - SEE ELECTRICAL ON SHEET 31.02 FOR ADDITIONAL INFORMATION. CONTRACTOR TO REVIEW ALL CEILING CONDITIONS AND VERIFY THAT PROPOSED CEILING CAN BE INSTALLED AT CEILING HEIGHTS INDICATED ON PLAN. IF CONFLICT, CONTACT VZ PROJECT MANAGER FOR DIRECTION.
 - TRACK LIGHTING IN THIS AREA - OPEN TO STRUCTURE ABOVE. CONTRACTOR SHALL PAINT EXPOSED STRUCTURE P-1c (ITEM C1) AND SHALL PROVIDE SPRAY APPLIED ACOUSTICAL FINISH (ITEM C1-K13). CONTRACTOR SHALL PAINT EXPOSED METAL DECK WITH RUST INHIBITOR PRIMER TO APPLICATION OF ACOUSTICAL SPRAY. CONTRACTOR SHALL PREPARE AND READY EXISTING SURFACE AS REQUIRED PER MANUFACTURER'S REQUIREMENTS - SEE FINISH SCHEDULE AND SPECIFICATIONS FOR ADDITIONAL INFORMATION.
 - UNDERCABINET LIGHTING (typ.) - SEE ELECTRICAL DRAWINGS FOR ADDITIONAL INFORMATION.
 - SEALED GYPSUM BOARD CEILING FOR IMPROVED AIR QUALITY.
 - EXISTING EXTERIOR LIGHT FIXTURE TO REMAIN.
 - APPROXIMATE LOCATION OF TRACK LIGHTING. VERIFY IN FIELD THAT CONCEALED TO STRUCTURE ABOVE SHALL NOT INTERFERE WITH HVAC. COORDINATE FINAL LOCATION WITH VERIZON PROJECT MANAGER.

CEILING FIXTURE LEGEND


- CUSTOM 16" GOODYEAR PENDANT BARN LIGHT. B.O. OF LIGHT FIXTURE IS AT 65" A.F.F. - SEE ELECTRICAL DRAWINGS FOR ADDITIONAL INFORMATION.
- CUSTOM 12" GOODYEAR PENDANT BARN LIGHT. B.O. OF LIGHT FIXTURE IS AT 65" A.F.F. - SEE ELECTRICAL DRAWINGS FOR ADDITIONAL INFORMATION.
- EXIT LIGHT FIXTURE - CEILING, WALL WITH LIGHTS - SEE ELECTRICAL DRAWINGS FOR ADDITIONAL INFORMATION.
- LED TRACK LIGHT FIXTURE. B.O. OF LIGHTING TRACK SYSTEM IS AT 11'-0" A.F.F. WITH ONE LIGHT ADJUSTABLE LED ACCENT LIGHT FIXTURE MOUNTED WITH BASK TRACK. SEE ELECTRICAL DRAWINGS FOR ADDITIONAL INFORMATION.
- 2 x 2 SURFACE MOUNTED LED LIGHT FIXTURE. SEE ELECTRICAL DRAWINGS FOR ADDITIONAL INFORMATION.
- 2 x 2 RECESSED LED FIXTURE. SEE ELECTRICAL DRAWINGS FOR ADDITIONAL INFORMATION.
- SUSPENDED LINEAR PENDANT LED LIGHT FIXTURE. B.O. OF PENDANT FIXTURE IS AT 6'-6" A.F.F. SEE ELECTRICAL DRAWINGS FOR ADDITIONAL INFORMATION.
- TWO-LIGHT ADJUSTABLE LED ACCENT LIGHT FIXTURE. MOUNTED WITH MONOPOINT BASE AND DOWN RODS AS NEEDED. MONOPOINT CONNECTION AT 11'-0" A.F.F. SEE ELECTRICAL DRAWINGS FOR ADDITIONAL INFORMATION.
- LED UNDERCABINET LIGHT FIXTURE - SEE ELECTRICAL DRAWINGS FOR ADDITIONAL INFORMATION.
- ROLL-DOWN PERFORATED ALUMINUM SECURITY GATE WITH RECESSED RAILS MOUNTED ON STEEL BRACKETS AND ATTACHED TO VERTICAL STEEL TUBES ENGINEERED AND FURNISHED BY SECURITY GATE MANUFACTURER. SEE ROLLING GRILL SECTION ON SHEET 31.02 FOR ADDITIONAL INFORMATION.

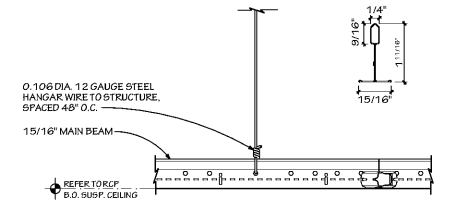

2 ACOUSTICAL CEILING DETAIL
 SCALE: 3" = 1'-0"

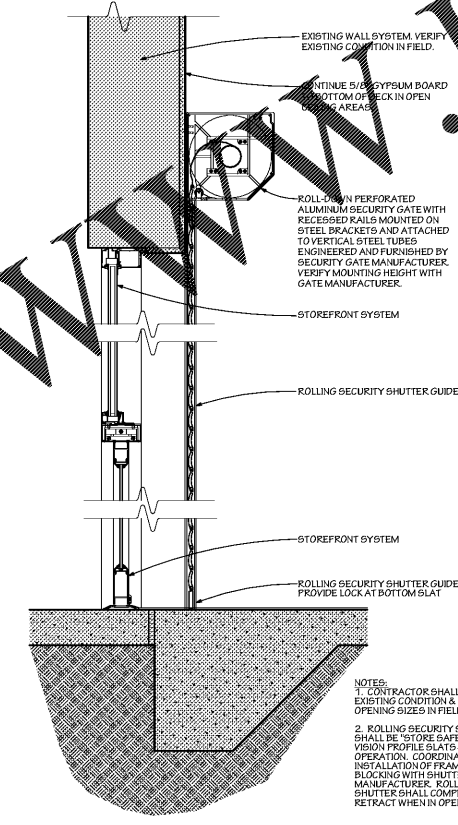

3 ROLLING GRILLE
 SCALE: 1-1/2" = 1'-0"

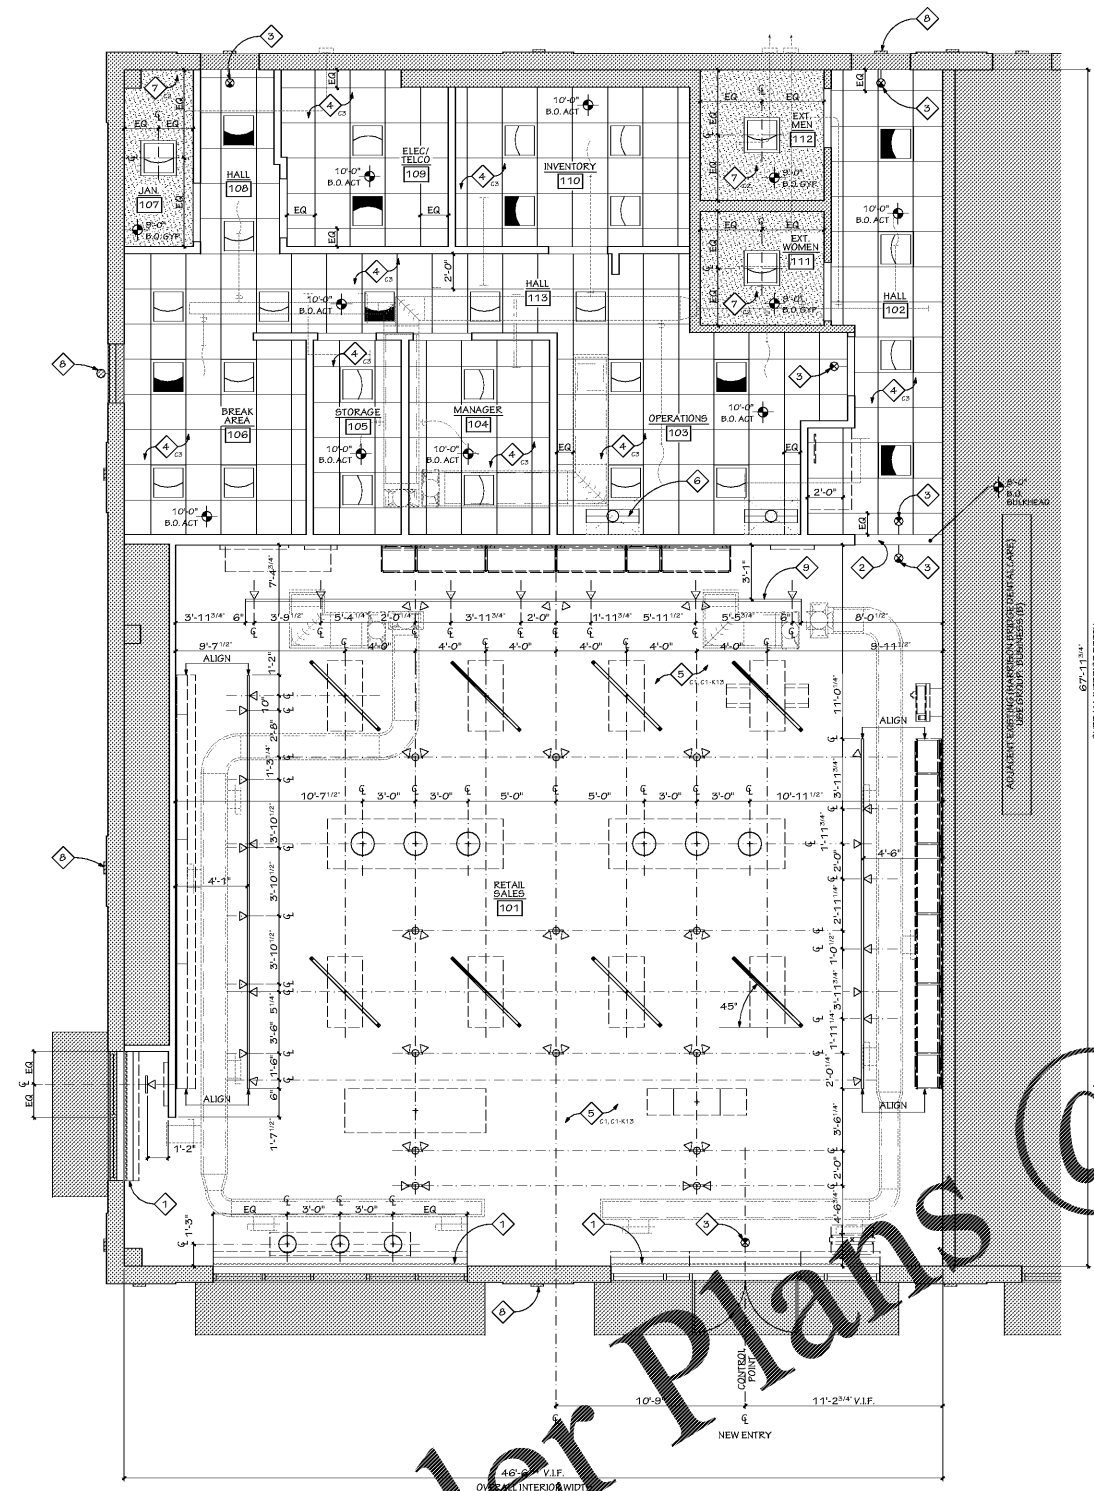

1 REFLECTED CEILING PLAN
 SCALE: 1/4" = 1'-0"



Order Plans @ www.LDILine.com