



TELECENT ENGINEERING, INC.  
2116 Convent Road, Suite 1  
Pikesville, MD 21150  
410-405-5816  
www.tei-eng.com

Client:  
Verizon  
Jared Yerg  
3700 Arco Corporate Drive  
Charlotte, North Carolina 28273

Verizon  
Simpsonville  
NextGen  
340 Harrison Bridge Road  
Simpsonville, SC 29680

© CONTENTS COPYRIGHT 2020  
TELECENT ENGINEERING, INC.

NO.	REVISION	DATE
FILE	DRAWN	ISSUED
20013J	CH	06/19/2020

SHEET TITLE  
**Fire Alarm Plan**

SHEET NUMBER


**92.04**

Bid/Permit Documents

**DRAWING NOTES**

- ① FIRE ALARM DEVICES ARE SHOWN IN RECOMMENDED LOCATION; THE CONTRACTOR'S FIRE ALARM VENDOR SHALL COORDINATE FINAL DEVICE LAYOUT, QUANTITY AND CANDELA RATINGS OF DEVICES, AND LOCATION OF DEVICES. IF TWO OR MORE DEVICES ARE VISIBLE FROM ONE LOCATION, THE DEVICES SHALL BE SYNCHRONIZED. ALL CANDELA RATINGS SHOWN ON PLAN ARE FOR REFERENCE ONLY; EXACT CANDELA RATINGS SHALL BE DETERMINED BY FIRE PROTECTION ENGINEER. SYSTEM SHOULD BE INCORPORATED INTO BASE BUILDING FIRE ALARM SYSTEM.
- ② PROVIDE HALL MOUNTED ADA COMPLIANT FIRE ALARM AUDIBLE/VISUAL DEVICE.
- ③ PROVIDE HALL MOUNTED ADA COMPLIANT FIRE ALARM VISUAL DEVICE.
- ④ PROVIDE FIRE ALARM FULL STATION.
- ⑤ PROVIDE CEILING MOUNTED ADA COMPLIANT FIRE ALARM VISUAL DEVICE.
- ⑥ PROVIDE CEILING MOUNTED ADA COMPLIANT FIRE ALARM AUDIBLE/VISUAL DEVICE.
- ⑦ PROVIDE FIRE ALARM FULL STATION WITH VISUAL/AUDIBLE DEVICE ABOVE.
- ⑧ PROPOSED RELOCATED FIRE ALARM CONTROL PANEL (FP-1).


SECURITY VENDOR IS TO COORDINATE SECURITY AND FIRE ALARM SYSTEM REQUIREMENTS WITH THE FIRE MARSHAL AND CONTRACTOR PRIOR TO THE START OF CONSTRUCTION.

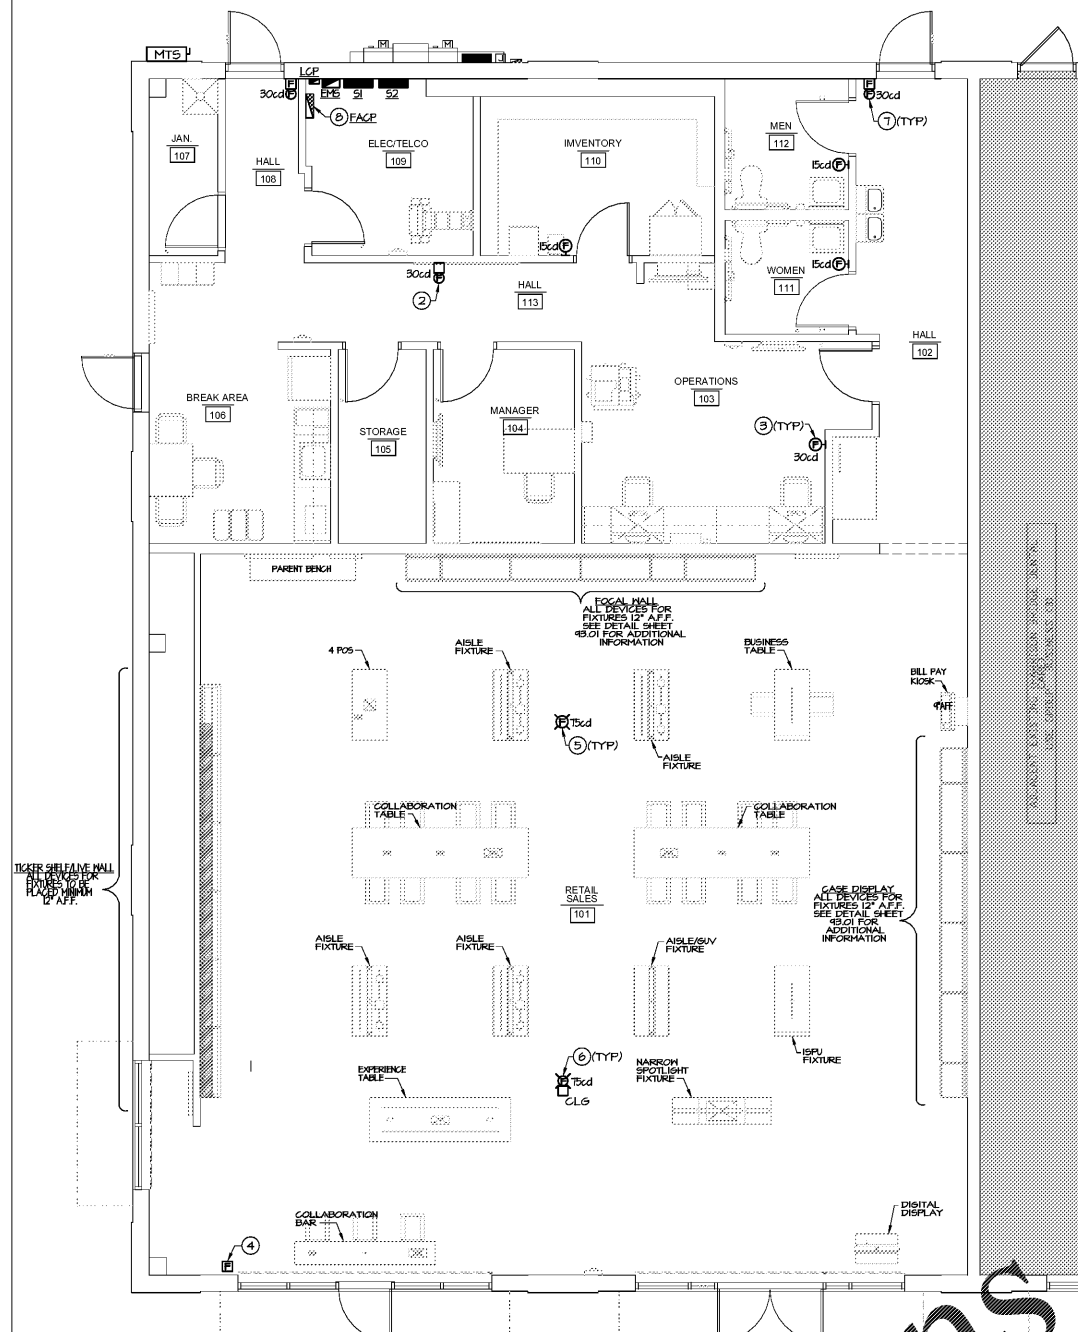

**① FIRE ALARM PLAN**  
SCALE: 1/4" = 1'-0"

NOTE: ALL FIRE ALARM DEVICES SHALL BE WHITE WITH RED LETTERING

 NOTE: ALL FIRE ALARM SHALL COMPLY WITH NFPA 72-2015 AND CONTRACTOR SHALL SUBMIT SHOP DRAWINGS FOR APPROVAL AND PERMITTING.



Order Plans @ www.LDILine.com