

ENGINEER OF RECORD
RYAN S. JONES
 ENGINEER LICENSE NUMBER
 047868
 SHEETS BEARING THIS SEAL ARE
 AUTHENTICATED. RESPONSIBILITY FOR
 ALL OTHER PLANS, SPECIFICATIONS
 OR INSTRUMENTS ARE DISCLAIMED.

CJD
 Engineering | Energy | Innovation
 2225 West Chesapeake Boulevard, Suite 200, Springfield, MO 65807
 P: 417.877.1700
 www.cjd-eng.com


PROJECT:
NEW O'REILLY AUTO PARTS STORE
2801 SOUTH MIAMI BLVD.
DURHAM, NC 27703
GRIDPOINT EMS

O'Reilly AUTO PARTS
 CORPORATE OFFICES
 233 SOUTH PATTERSON
 SPRINGFIELD, MISSOURI 65802
 (417) 862-2674 TELEPHONE

DRAWN BY: **JBR** CHECKED BY: **CRF**
 DATE: **12/20/19**
 REVISION:
 PROJECT NUMBER:
19261-DC1

SHEET NUMBER
EM1.1

REPRODUCTION PROHIBITED WITHOUT THE EXPRESSED WRITTEN CONSENT OF THE DESIGN PROFESSIONAL.

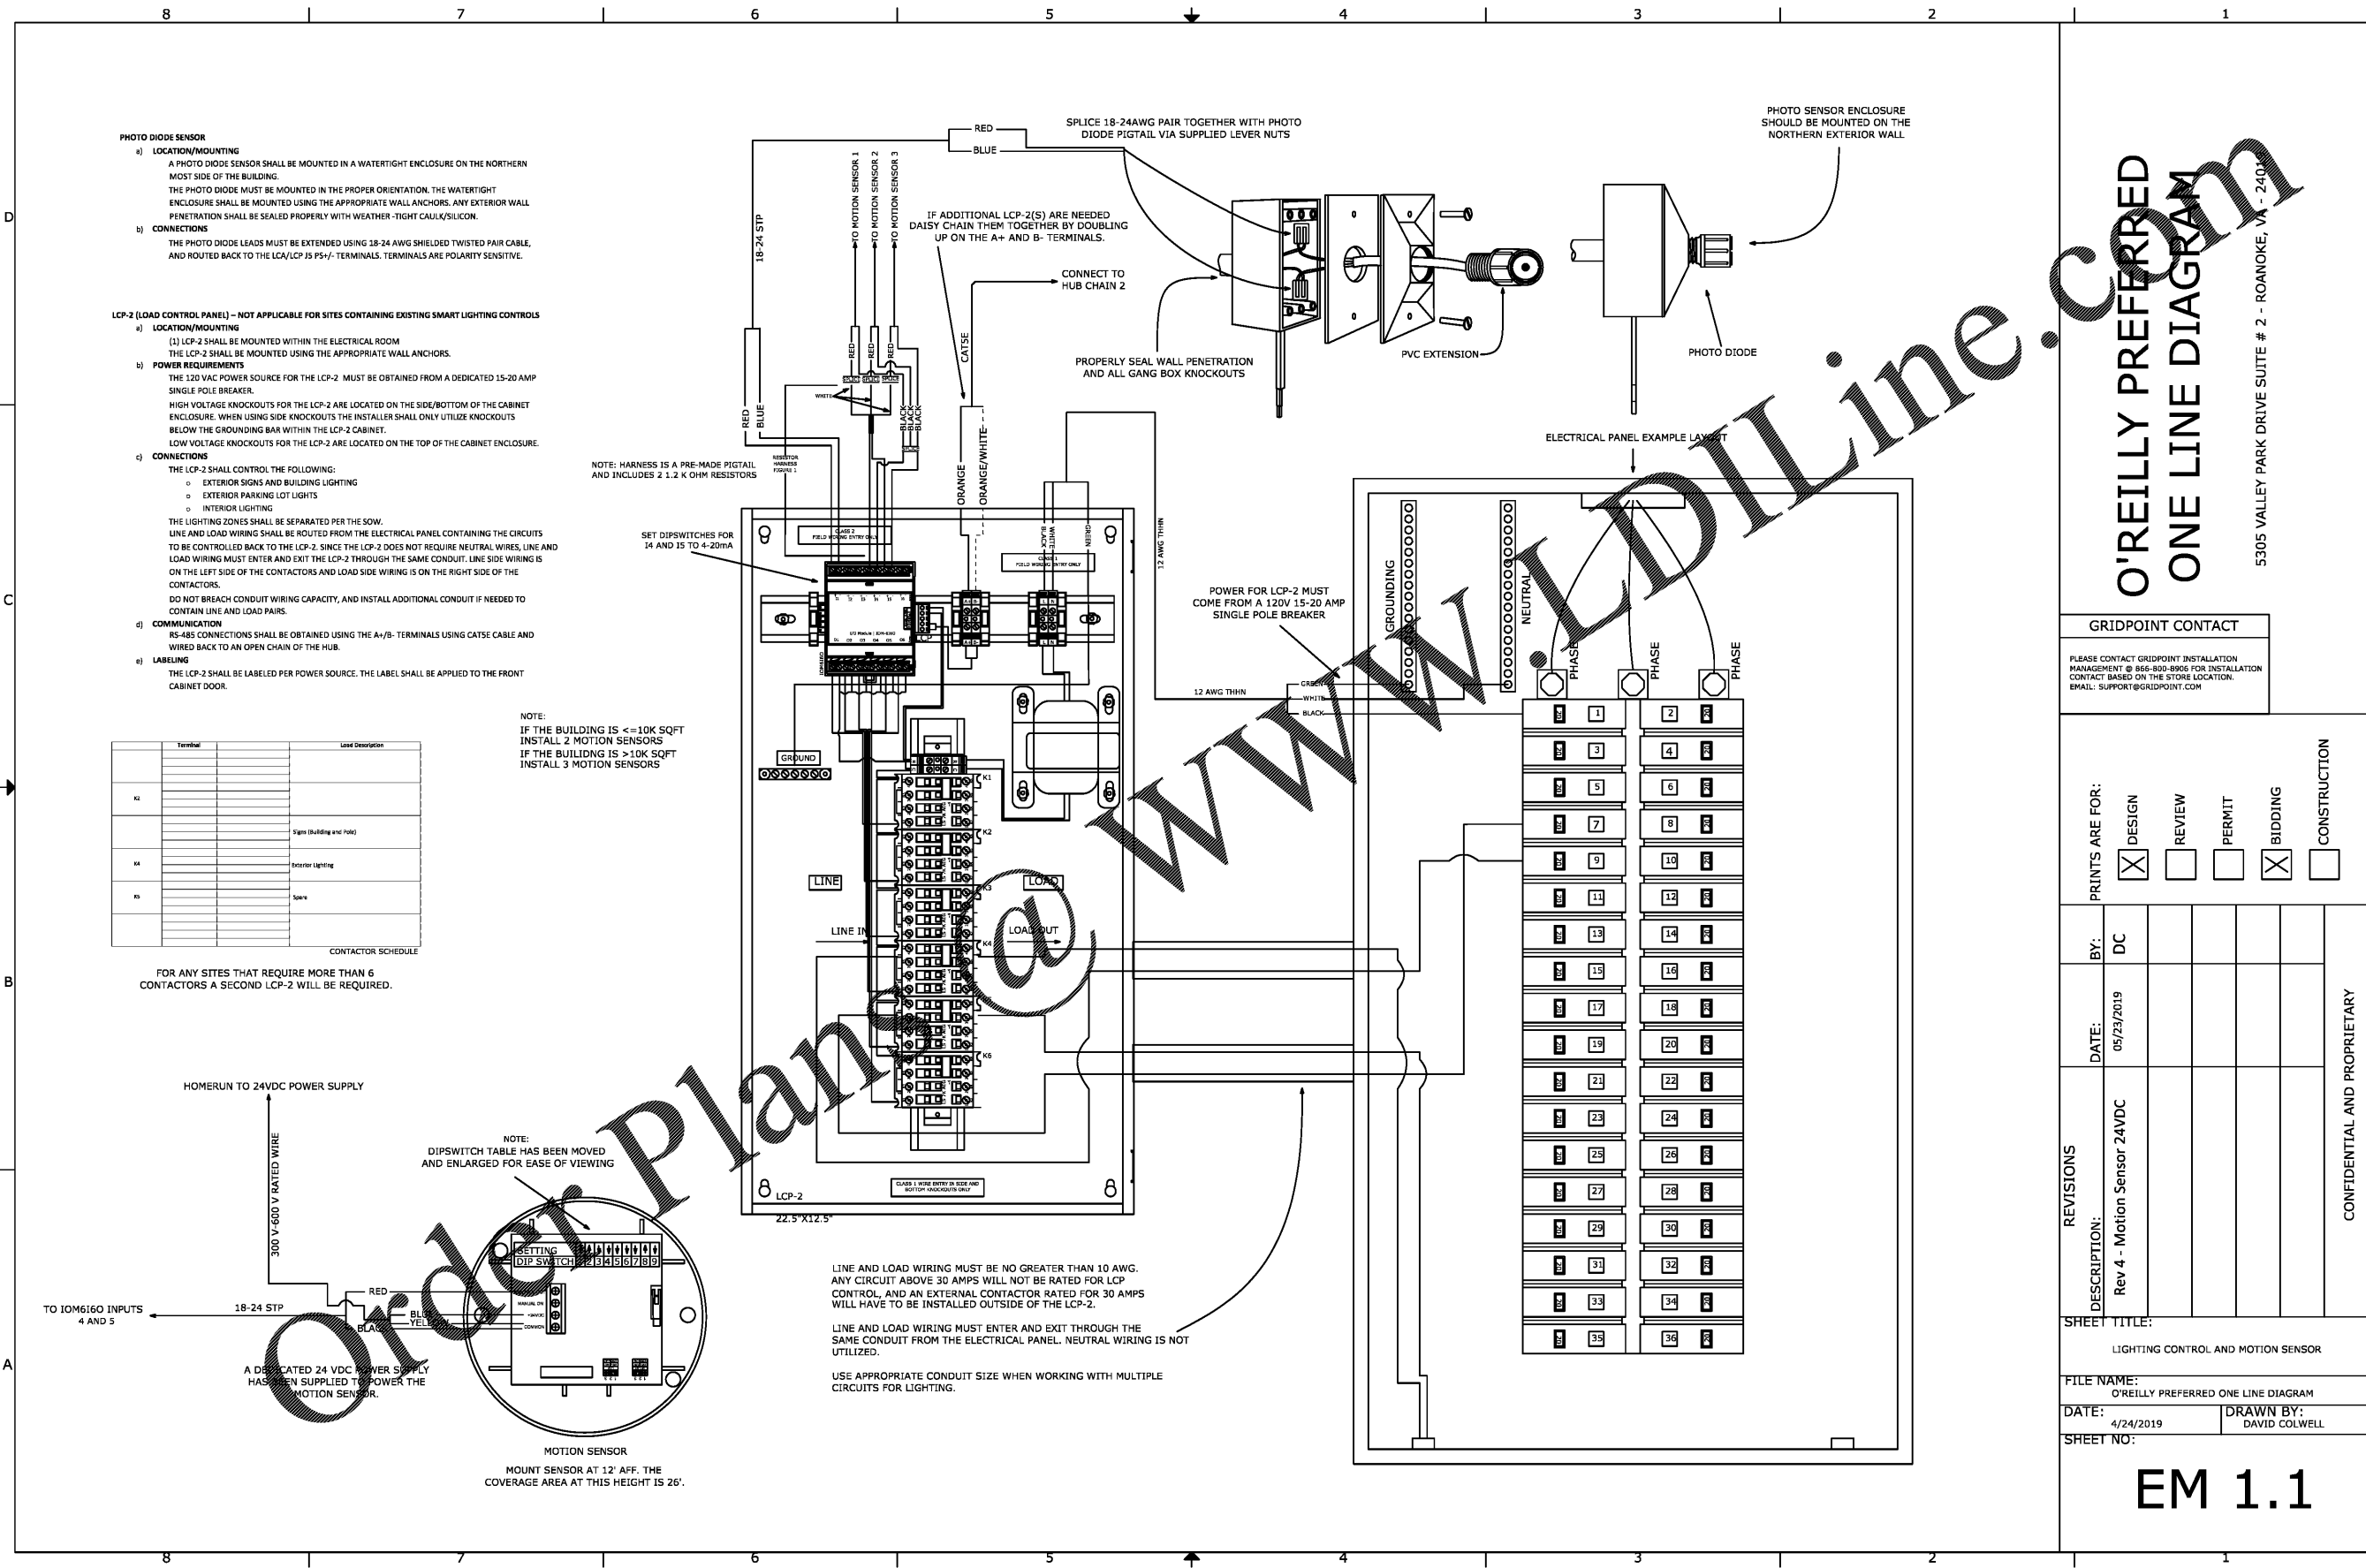

O'REILLY PREFERRED ONE LINE DIAGRAM
 5305 VALLEY PARK DRIVE SUITE # 2 - ROANOKE, VA - 24012

GRIDPOINT CONTACT
 PLEASE CONTACT GRIDPOINT INSTALLATION MANAGEMENT @ 866-800-8906 FOR INSTALLATION CONTACT BASED ON THE STORE LOCATION.
 EMAIL: SUPPORT@GRIDPOINT.COM

PRINTS ARE FOR:
 DESIGN
 REVIEW
 PERMIT
 BIDDING
 CONSTRUCTION

REVISIONS
 DESCRIPTION: Rev 4 - Motion Sensor 24VDC
 DATE: 05/23/2019
 BY: DC

SHEET TITLE:
 LIGHTING CONTROL AND MOTION SENSOR

FILE NAME:
 O'REILLY PREFERRED ONE LINE DIAGRAM
 DATE: 4/24/2019
 DRAWN BY: DAVID COLWELL

EM 1.1