


GENERAL NOTES

REFER TO SHEET MP1 FOR GENERAL NOTES PERTAINING TO THIS SHEET.

- KEYNOTES**
- 15.403 CONNECT TO EXISTING SANITARY PIPE OF EQUAL OR LARGER SIZE. VERIFY SIZE, LOCATION, ELEVATION, AND FLOW DIRECTION AT SITE.
 - 15.404 CONNECT TO EXISTING VENT PIPE OF EQUAL OR LARGER SIZE. VERIFY SIZE AND LOCATION AT SITE.
 - 15.405 PROPERLY CAP, PLUG AND CONCEAL ANY PIPING LEFT OPEN. CAP ABANDONED SEWER PIPING 6" BELOW FINISHED FLOOR. MATCH EXISTING FLOOR FINISHES. REMOVE UNUSED WATER AND VENT PIPING ABOVE CEILING AND REMAIN OPEN.
 - 15.406 EXISTING PIPING TO REMAIN (VERIFY LOCATION AND SIZE).
 - 15.407 PATCH EXISTING CONCRETE FLOOR OR INSTALLATION OF NEW UNDERGROUND PLUMBING PIPE. MATCH EXISTING CONSTRUCTION AND FINISHES.

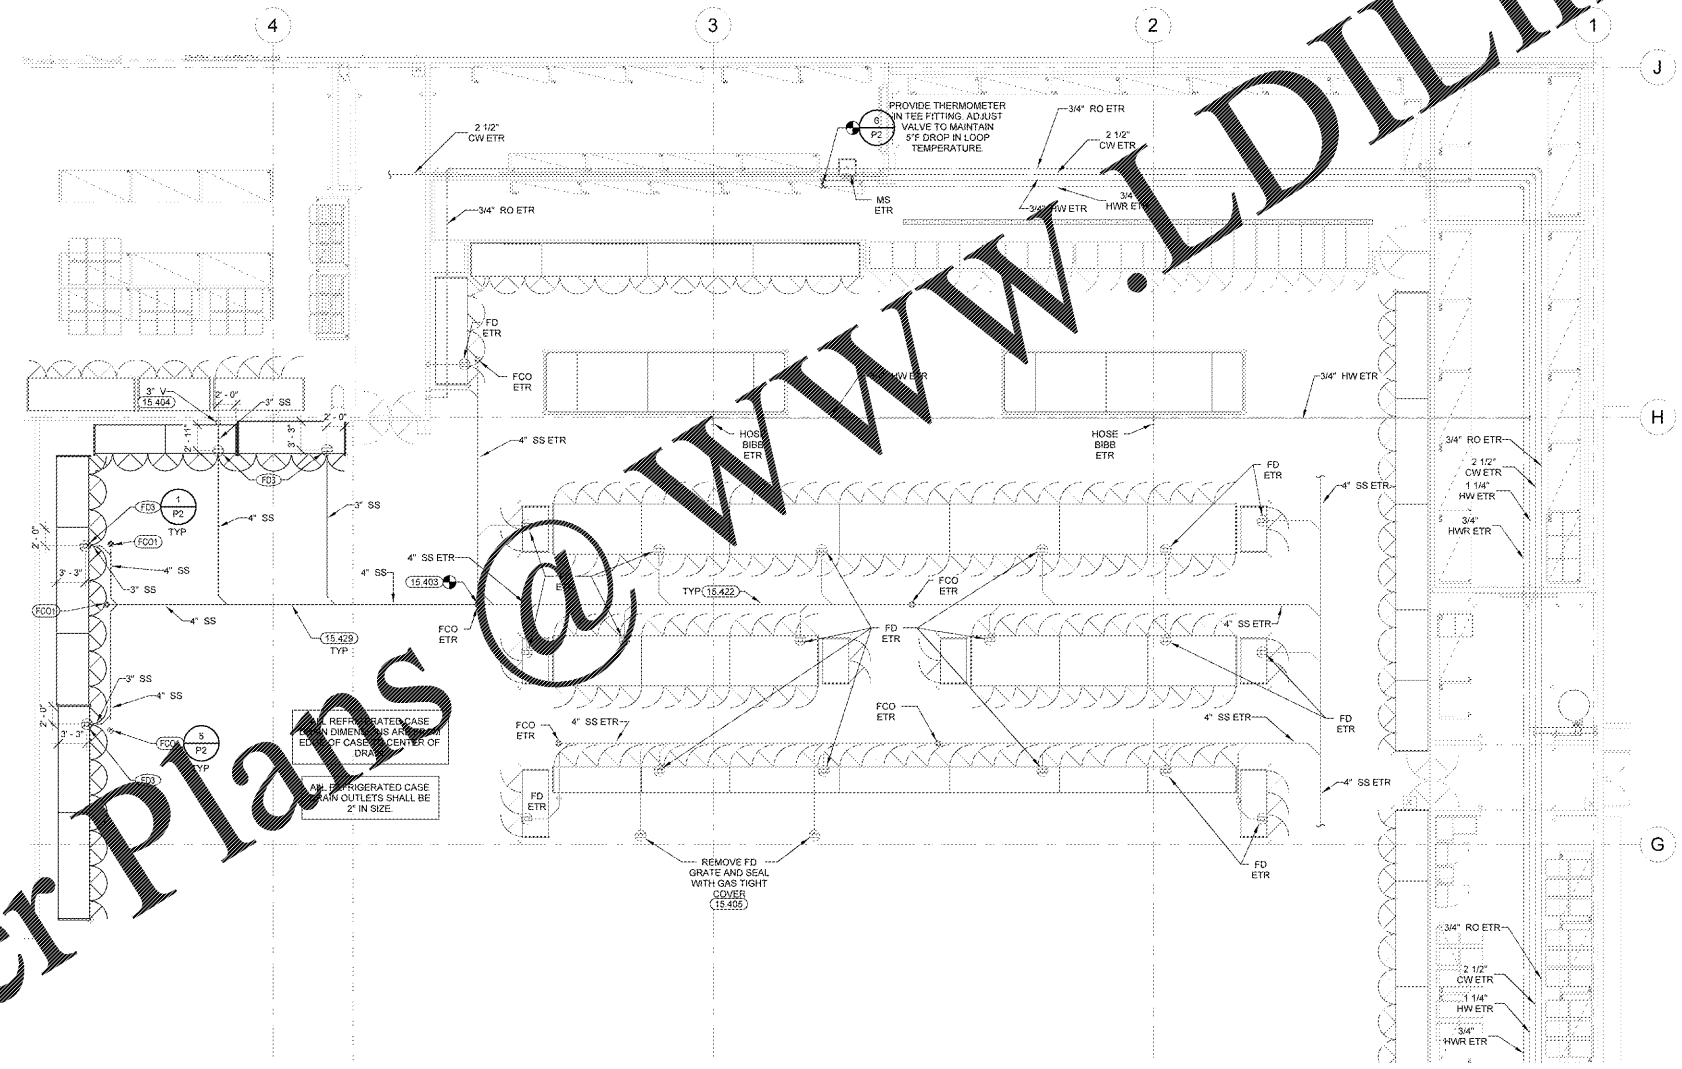

1 REAR GROCERY PLUMBING PLAN
1/8" = 1'-0"

Order Plans @ www.LDILine.com

STIPULATION FOR REUSE
THIS DOCUMENT IS THE PROPERTY OF CYNERGY ENGINEERING, PLLC. IT IS TO BE USED ONLY FOR THE PROJECT AND SITE SPECIFICALLY IDENTIFIED HEREIN. IT IS NOT TO BE REPRODUCED, COPIED, OR TRANSMITTED IN ANY FORM OR BY ANY MEANS, ELECTRONIC OR MECHANICAL, INCLUDING PHOTOCOPYING, RECORDING, OR BY ANY INFORMATION STORAGE AND RETRIEVAL SYSTEM, WITHOUT THE WRITTEN PERMISSION OF CYNERGY ENGINEERING, PLLC.

CONSULTANTS

Walmart
FAYETTEVILLE, NC
STORE NO. 1261-248
JOB NUMBER: USRM007256 | PHOTO: 156-SC

ISSUE BLOCK

NO.	DATE	DESCRIPTION

CHECKED BY: JJB
DRAWN BY: KOW
PROTO CYCLE: 02/28/2020
DOCUMENT DATE: 04/15/2020

DOCUMENTS WITHOUT SIGNATURE AND REQUIRED SEAL OF A PROFESSIONAL ENGINEER ARE NOT FOR CONSTRUCTION

CYNERGY ENGINEERING, PLLC
CA # F-0584
EXPIRES 06/30/2020
MICHAEL D. OBERMARK
REGISTERED PROFESSIONAL ENGINEER

REAR GROCERY PLUMBING PLAN

SHEET: GP1.1

EACH SUBCONTRACTOR IS RESPONSIBLE FOR HAVING A THOROUGH KNOWLEDGE OF ALL DRAWINGS AND SPECIFICATIONS IN THEIR RELATED FIELD. THE FAILURE TO ACQUAINT THEMSELVES WITH THIS KNOWLEDGE DOES NOT RELIEVE THE RESPONSIBILITY OF PERFORMING THE WORK PROPERLY. NO ADDITIONAL COMPENSATION SHALL BE ALLOWED BECAUSE OF CONDITIONS THAT OCCUR DUE TO FAILURE TO FAMILIARIZE WORKERS WITH THIS KNOWLEDGE.

EXISTING CONDITIONS WERE TAKEN FROM ORIGINAL DRAWINGS AND MAY NOT REFLECT EXACT "AS-BUILT" CONDITIONS. CONTRACTOR SHALL FIELD VERIFY ALL EXISTING CONDITIONS PRIOR TO SUBMITTING FINAL BIDS. CONTRACTOR SHALL CAREFULLY COORDINATE NEW WORK AND DEMOLITION WITH ALL OTHER DISCIPLINES AND EXISTING CONDITIONS.