


Order Plans @

www.LDILine.com

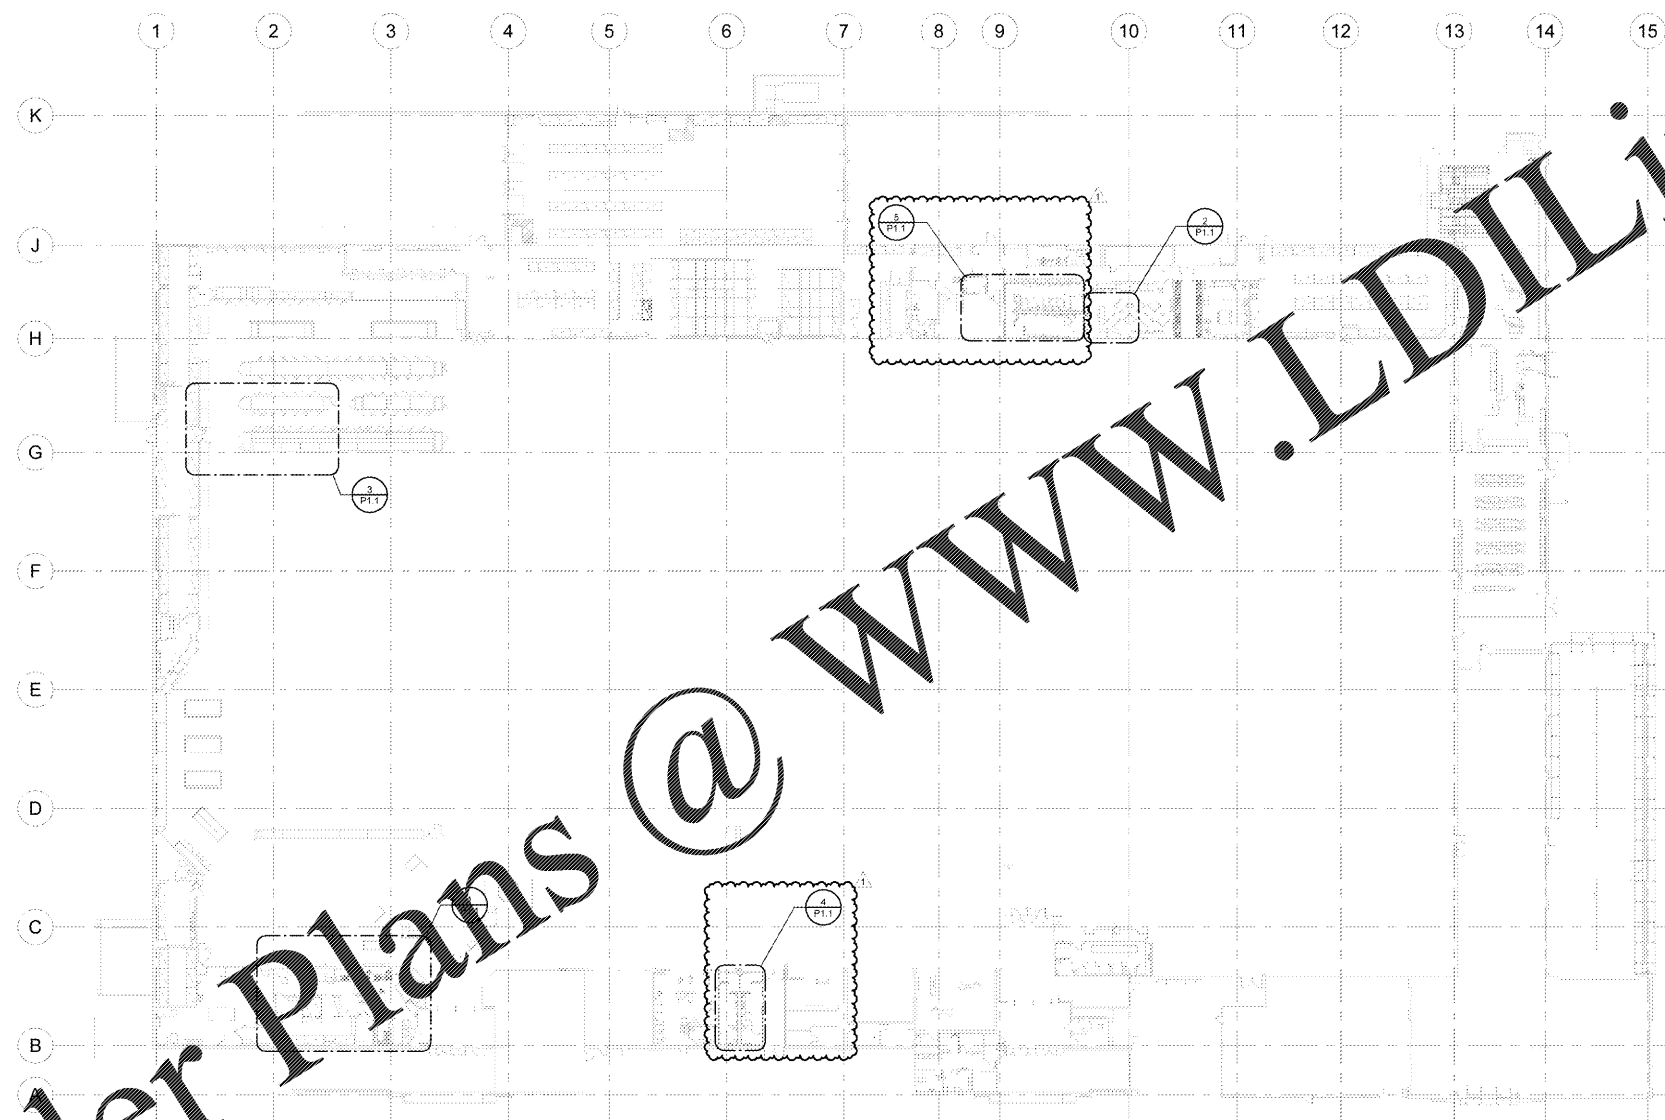

1 OVERALL PLUMBING PLAN
1" = 30'-0"

GENERAL NOTES

1. GENERAL NOTES ARE APPLICABLE TO ALL PLUMBING DRAWINGS.
2. PROVIDE ALL MATERIALS FOR A COMPLETE INSTALLATION IN ALL RESPECTS AND READY FOR INTENDED USE AND IN STRICT ACCORDANCE WITH STATE AND LOCAL CODES AND MANUFACTURERS RECOMMENDATIONS.
3. STORE MUST BE KEPT IN OPERATION. ARRANGE ALL WORK TO KEEP DISRUPTIONS TO STORE OPERATIONS TO A MINIMUM. COORDINATE WITH EXISTING AND NEW CONSTRUCTION. PAY ALL NECESSARY FEES AND PERMITS.
4. IF NEW CONSTRUCTION DISRUPTS EXISTING UNDERGROUND SERVICES (GAS, SEWER, DOMESTIC WATER, FIRE SPRINKLER, ETC.), PROVIDE ALL MATERIALS AND LABOR AS REQUIRED TO MAINTAIN THEIR PROPER OPERATION.
5. CONTRACTOR IS RESPONSIBLE FOR UTILIZING OWNER APPROVED ROOFING CONTRACTORS FOR CUTTING AND PATCHING ROOF.
6. EXISTING PIPES AND LOCATIONS HAVE NOT BEEN FIELD VERIFIED. CONTRACTOR IS RESPONSIBLE TO VERIFY LOCATION AND SIZES OF ALL EXISTING PIPING THAT IS BEING CONNECTED TO OR RELOCATED, AND TO VERIFY THAT PROPER SLOPES ARE AVAILABLE. MAINTAIN MINIMUM SLOPE OF 1/8" PER FOOT FOR SAN SEWER AND 1/4" PER FOOT FOR COLD WATER PIPING. MAINTAIN SLOPE OF 1/2" PER FOOT FOR SAN SEWER PIPING SMALLER THAN 12" DIA. REFER ARCH. FOR TRENCHING REQUIREMENTS.
7. PLUMBING CONTRACTOR SHALL VERIFY EXISTING SEWER AND VENT PIPE SIZE AND ELEVATION AND SHALL VERIFY THAT PROPER SLOPES ARE AVAILABLE BEFORE CUTTING FLOOR SLAB FOR NEW SEWER PIPING.
8. PROVIDE ACCESS DOORS TO NEW WATER VALVES AND CLEANOUTS AS NECESSARY WHEN INSTALLED IN INACCESSIBLE AREAS.
9. PLUMBING CONTRACTOR SHALL PROVIDE ONE YEAR WARRANTY FOR PROPER SEWER SYSTEM OPERATION.
10. SANITARY DRAINAGE LINES AND FITTINGS (RAIN, WASTE AND VENT) SHALL BE CAST IRON COATED INSIDE AND OUTSIDE. WHERE PERMITTED BY LOCAL CODES, PVC-DWV PLASTIC SCHEDULE 40 MAY BE USED IN LIEU OF CAST IRON. ALL PHOTO LAB PLUMBING SHALL BE PVC.
11. WATER PIPING ABOVE GRADE SHALL BE TYPE "L" HARD DRAWN COPPER JOINED WITH WROUGHT COPPER FITTINGS. MAKE JOINTS USING LEAD-FREE SOLDER AND A NON-CORROSIVE, PASTE-TYPE FLUX. MAKE PIPING CONNECTIONS TO A FIXTURE WITH CHROME-PLATED SEAMLESS BRASS TUBE. INSULATE HOT & COLD WATER PIPING WITH RIGID GLASS FIBER A MINIMUM OF 1/2" THICK WITH WHITE ALL-SERVICE JACKET (VAPOR RETARDER).
12. FLOOR CUTS SHALL BE STRAIGHT AND CLEAN. REPLACE REMOVED SLAB WITH CONCRETE FLUSH AND SMOOTH WITH ADJACENT FLOOR SLAB. REFERENCE ARCHITECTURAL SHEETS. COORDINATE WITH GENERAL CONTRACTOR.
13. CAP ALL PIPING OPENINGS DURING CONSTRUCTION UNTIL FINAL CONNECTIONS TO EQUIPMENT AND ACCESSORIES ARE MADE.
14. CUT AND PATCH EXISTING CONCRETE FLOOR SLAB FOR INSTALLATION OF NEW UNDERGROUND PLUMBING PIPE. MATCH EXISTING CONSTRUCTION.
15. PROVIDE ESCUTCHEON PLATES FOR PLUMBING PENETRATIONS THROUGH GROCERY CEILINGS AND WALLS.
16. AT CONTRACTOR'S OPTION (I/N/O), IN LIEU OF COPPER WATER PIPING, PEX OR AQUATHERM PIPING MAY BE USED. REFER TO EQUIVALENT NOMINAL PIPE SIZES SCHEDULE AND SPECIFICATIONS.
17. BUILDING COMPONENTS ABANDONED BY THE SCOPE OF WORK SHALL BE SECURED TO PREVENT FALLING, LOSING OR CAUSING DAMAGE OF ANY KIND IN THE FUTURE.

STIPULATION FOR REUSE
THIS DRAWING AND ALL INFORMATION CONTAINED HEREIN IS THE PROPERTY OF HENDERSON ENGINEERS. IT IS TO BE USED ONLY FOR THE PROJECT AND SITE SPECIFICALLY IDENTIFIED HEREIN. IT IS NOT TO BE REPRODUCED, COPIED, OR TRANSMITTED IN ANY FORM OR BY ANY MEANS, ELECTRONIC OR MECHANICAL, INCLUDING PHOTOCOPYING, RECORDING, OR BY ANY INFORMATION STORAGE AND RETRIEVAL SYSTEM, WITHOUT THE WRITTEN PERMISSION OF HENDERSON ENGINEERS.

CONSULTANTS
HENDERSON ENGINEERS
6645 LEBLANC AVENUE SUITE 200
TEL 615.763.2600 FAX 615.752.8601
WWW.HENDERSONENGINEERS.COM
N.C. CORP. REG. FILE NO. C-1482
E.P.R.F.E.S. 8/26/2015

Walmart
LELAND NC
1112 NEW POINT BOULEVARD
STORE NO. 4273-26
JOB NUMBER: 2060314232 | PHOTO:
2020 SPRB

ISSUE BLOCK		
1	PR #1	06/15/20

CHECKED BY: AI
DRAWN BY: TNJ
PROTO CYCLE: 02/28/20
DOCUMENT DATE: 04/08/20

NOT FOR CONSTRUCTION

OVERALL PLUMBING PLAN

SHEET: P1

EXISTING CONDITIONS WERE TAKEN FROM ORIGINAL DRAWINGS AND MAY NOT REFLECT EXACT "AS-BUILT" CONDITIONS. CONTRACTOR SHALL FIELD VERIFY ALL EXISTING CONDITIONS PRIOR TO SUBMITTING FINAL BIDS. CONTRACTOR SHALL CAREFULLY COORDINATE NEW WORK AND DEMOLITION WITH ALL OTHER DISCIPLINES AND EXISTING CONDITIONS.

EACH SUBCONTRACTOR IS RESPONSIBLE FOR HAVING A THOROUGH KNOWLEDGE OF ALL DRAWINGS AND SPECIFICATIONS IN THEIR RELATED FIELD. THE FAILURE TO ACQUAINT THEMSELVES WITH THIS KNOWLEDGE DOES NOT RELIEVE THE RESPONSIBILITY OF PERFORMING THE WORK PROPERLY. NO ADDITIONAL COMPENSATION SHALL BE ALLOWED BECAUSE OF CONDITIONS THAT OCCUR DUE TO FAILURE TO FAMILIARIZE WORKERS WITH THIS KNOWLEDGE.