



CEILING LEGEND	
	2' X 2' GRID
	2' X 2' RECESSED TROFFER
	STRIP PENDANT
	PENDANT
	DECORATIVE PENDANT
	6' RECESSED CAN LIGHT
	SCONCE
	FANLIGHT COMBO
	EXIT SIGN
	AIR SUPPLY
	OCCUPANCY SENSOR

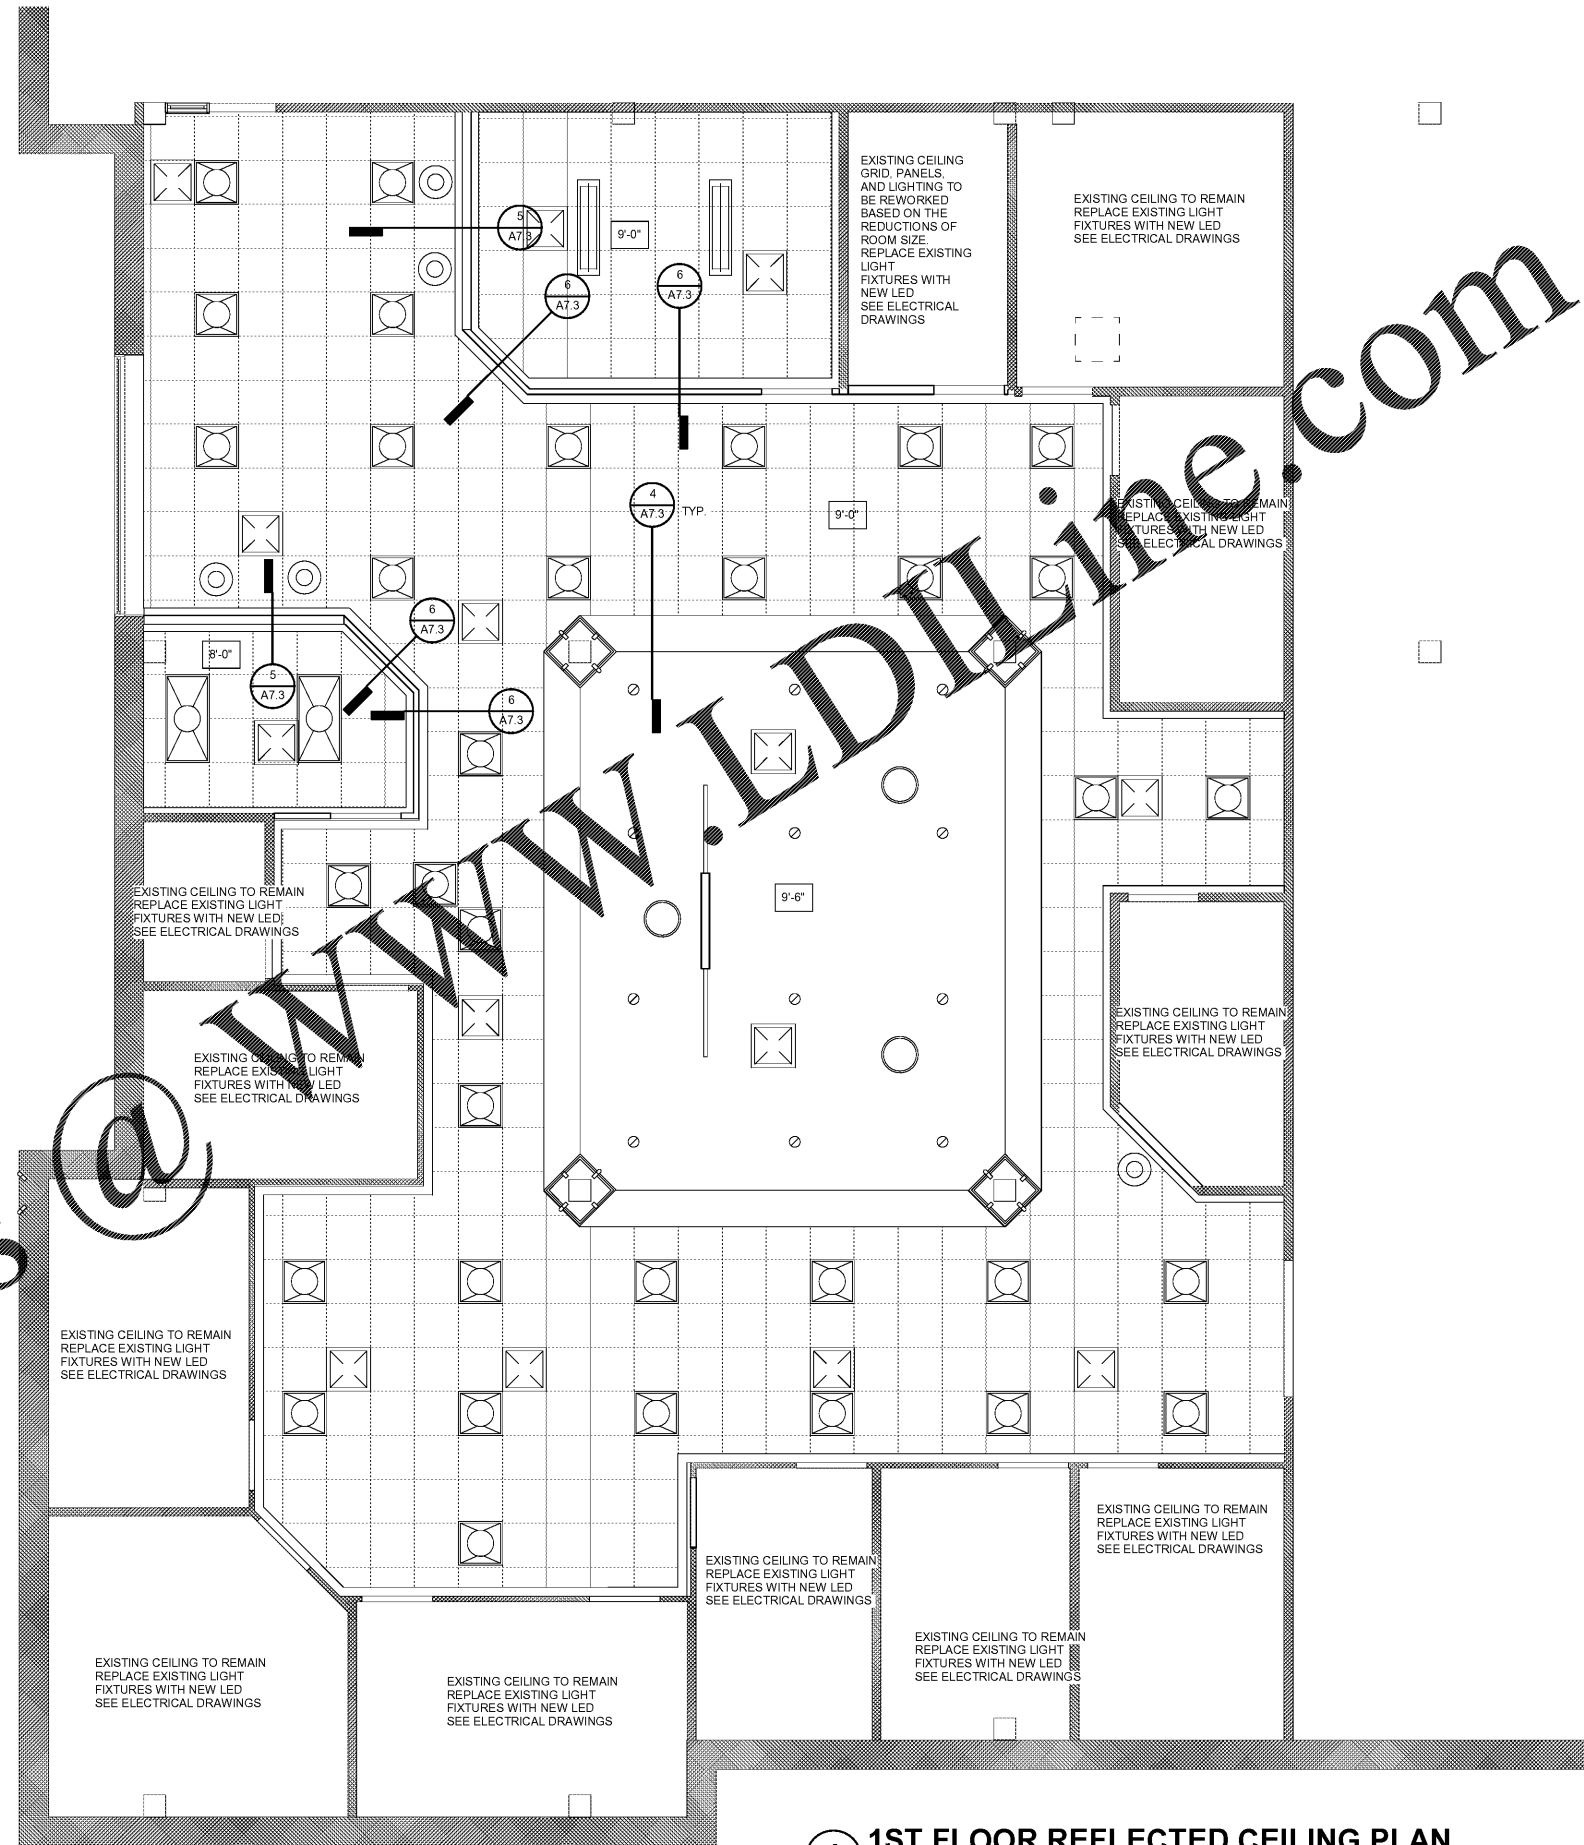

Order Plans @ www.LDOnline.com

1 1ST FLOOR REFLECTED CEILING PLAN
SCALE: 1/4" = 1'-0"

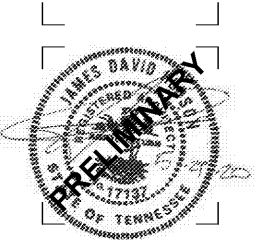

ISSUE DATES
INITIAL ISSUE 05-26-20

JOB NO. # | DWN | CKD
Author | Checker

A7.1

REFLECTED CEILING
PLAN FIRST FLOOR