 




 





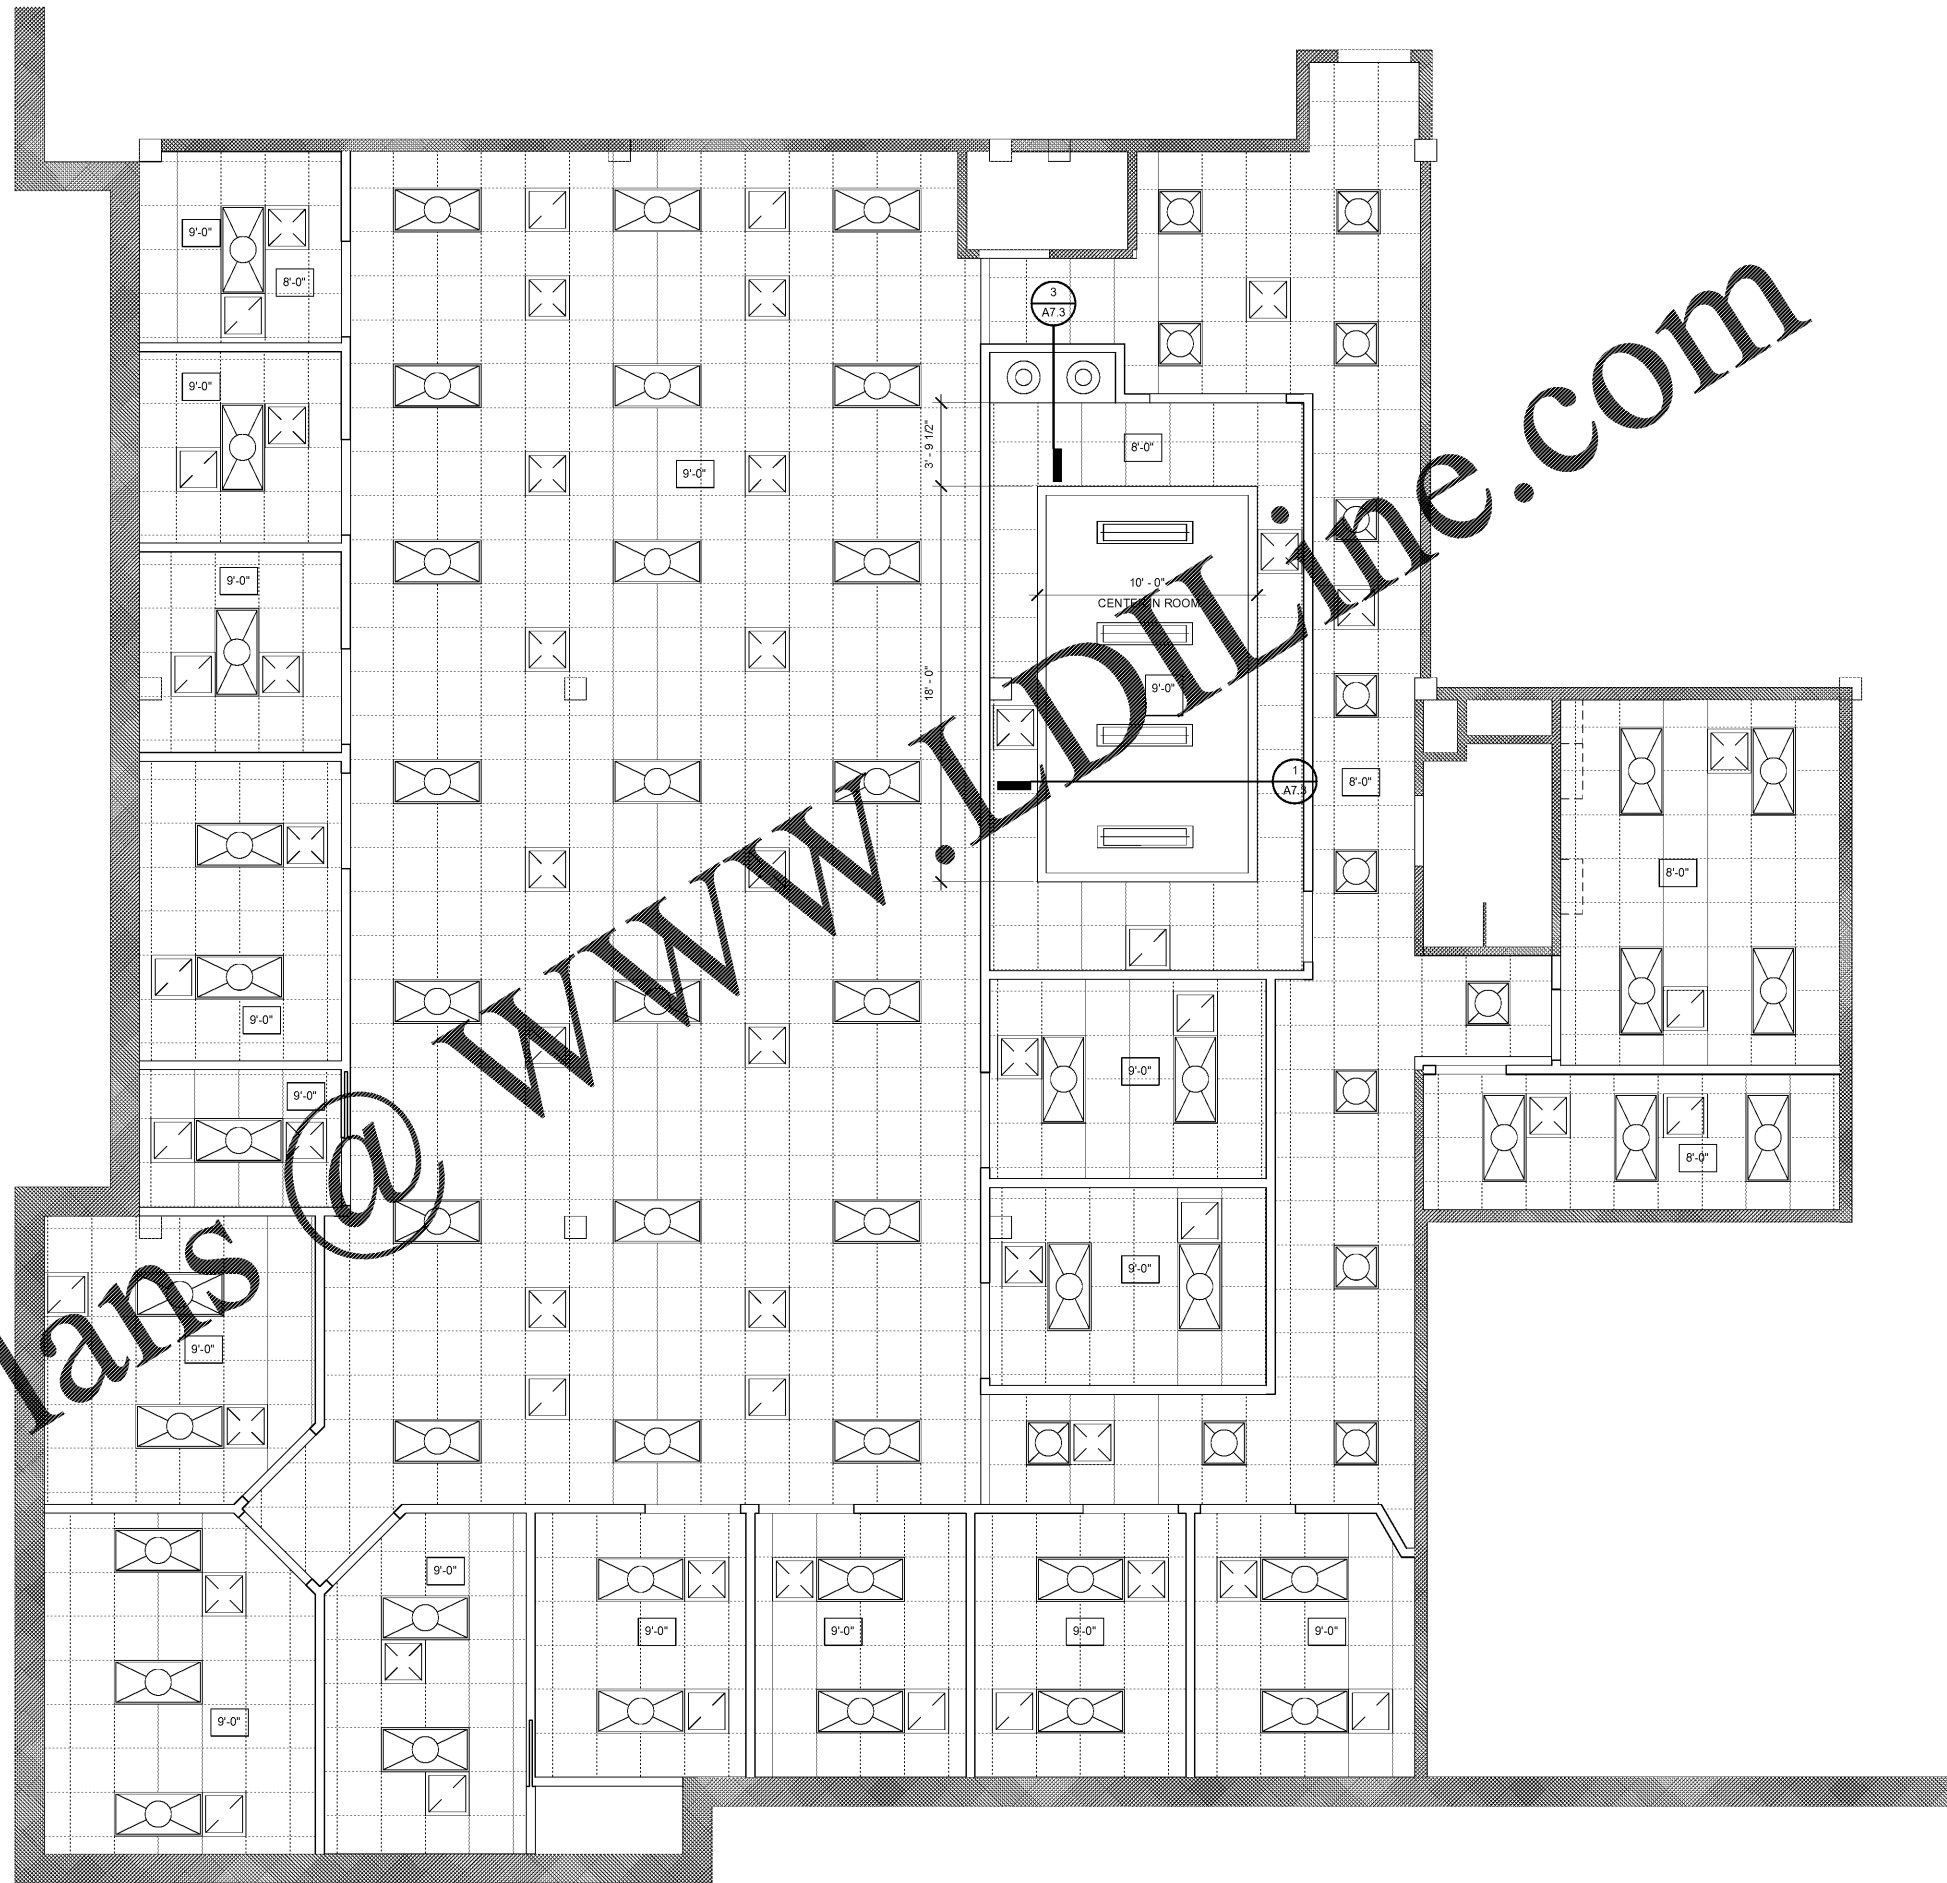


**CEILING LEGEND**

-  2 X 2 GRID
-  2 X 2 RECESSED TROFFER
-  STRIP PENDANT
-  PENDANT
-  DECORATIVE PENDANT
-  6" RECESSED CAN LIGHT
-  SCONCE
-  FAN/LIGHT COMBO
-  EXIT SIGN
-  AIR SUPPLY
-  OCCUPANCY SENSOR



Order Plans @

WWW.LDILLINE.COM

**ART**  
 4743 FRZDDUWHVNDHWH  
 FRDNDWDRQJ/D/AHQ 6 173 ;  
 756159817646  
 2221DWHFKLSUR

**ROCK POINT BANK**

401 Chestnut Street Chattanooga Tennessee



ISSUE DATES  
INITIAL ISSUE 05/26/20

**1 2ND FLOOR REFLECTED CEILING PLAN**  
SCALE: 1/4" = 1'-0"

JOB NO. | DWN | CKD  
# | Author | Checker  
**A7.2**  
REFLECTED CEILING  
PLAN SECOND  
FLOOR