

GENERAL SHEET NOTES


- MECHANICAL CONTRACTOR SHALL COORDINATE WITH OTHER TRADES FOR COMPLETION OF PROJECT.
- MECHANICAL CONTRACTOR SHALL VERIFY THAT ALL EQUIPMENT SHOWN ON THESE DRAWINGS WILL NOT CONFLICT WITH ANY DRAINS, VENTS, MECHANICAL PIPING, SPRINKLERS, AND LIGHTS OR OTHER ELECTRICAL INSTALLATIONS.
- REFER TO ARCHITECTURAL REFLECTED CEILING PLAN FOR EXACT LOCATION OF GRILLES AND DIFFUSERS.
- DUCT DIMENSIONS DO NOT INCLUDE ALLOWANCES FOR INSULATION.
- PROVIDE MANUAL VOLUME BALANCING DAMPERS AT ALL TAKE-OFFS WHETHER INDICATED OR NOT.
- CLEAN / REMOVE/ RELOCATE EXISTING AIR RETURNS & SUPPLY GRILLES & DIFFUSERS AS REQUIRED. SUPPLY NEW GRILLES & DIFFUSERS TO MATCH EXISTING ONLY AS REQUIRED. LAYOUT SHOWN IS A SUGGESTED LAY-OUT ONLY.

MECHANICAL SCOPE:

- ALL THERMOSTATS TO REMAIN AS IS.
- MOVE EXISTING DIFFUSERS TO MATCH NEW RCP. ADD ADDITIONAL FLEX DUCT AS NEEDED.
- VAV BOXES TO REMAIN AS IS AND ZONES TO REMAIN AS IS UNLESS NOTED OTHERWISE.

KEYNOTES

- RELOCATE EXISTING DIFFUSERS/GRILLES TO MATCH NEW REFLECTED CEILING PLANS. RETURN GRILLES IN ENCLOSED OFFICES SHALL HAVE PRICE RETURN AIR CANOPY FOR PRIVACY.
- EXISTING VAVS/ZONE DAMPERS SHOWN FOR REFERENCE.
- DIFFUSER OVER NEW OFFICE 118 SHALL BE DISCONNECTED FROM THE ZONE IT IS CURRENTLY CONNECTED TO. RECONNECT DIFFUSER TO ZONE SERVING OFFICE 116. PATCH AND SEAL DUCT AS NEEDED.
- CONNECT NEW SUPPLY DIFFUSER (SD-1) TO EXISTING VAV SERVING THE COMMON AREA.

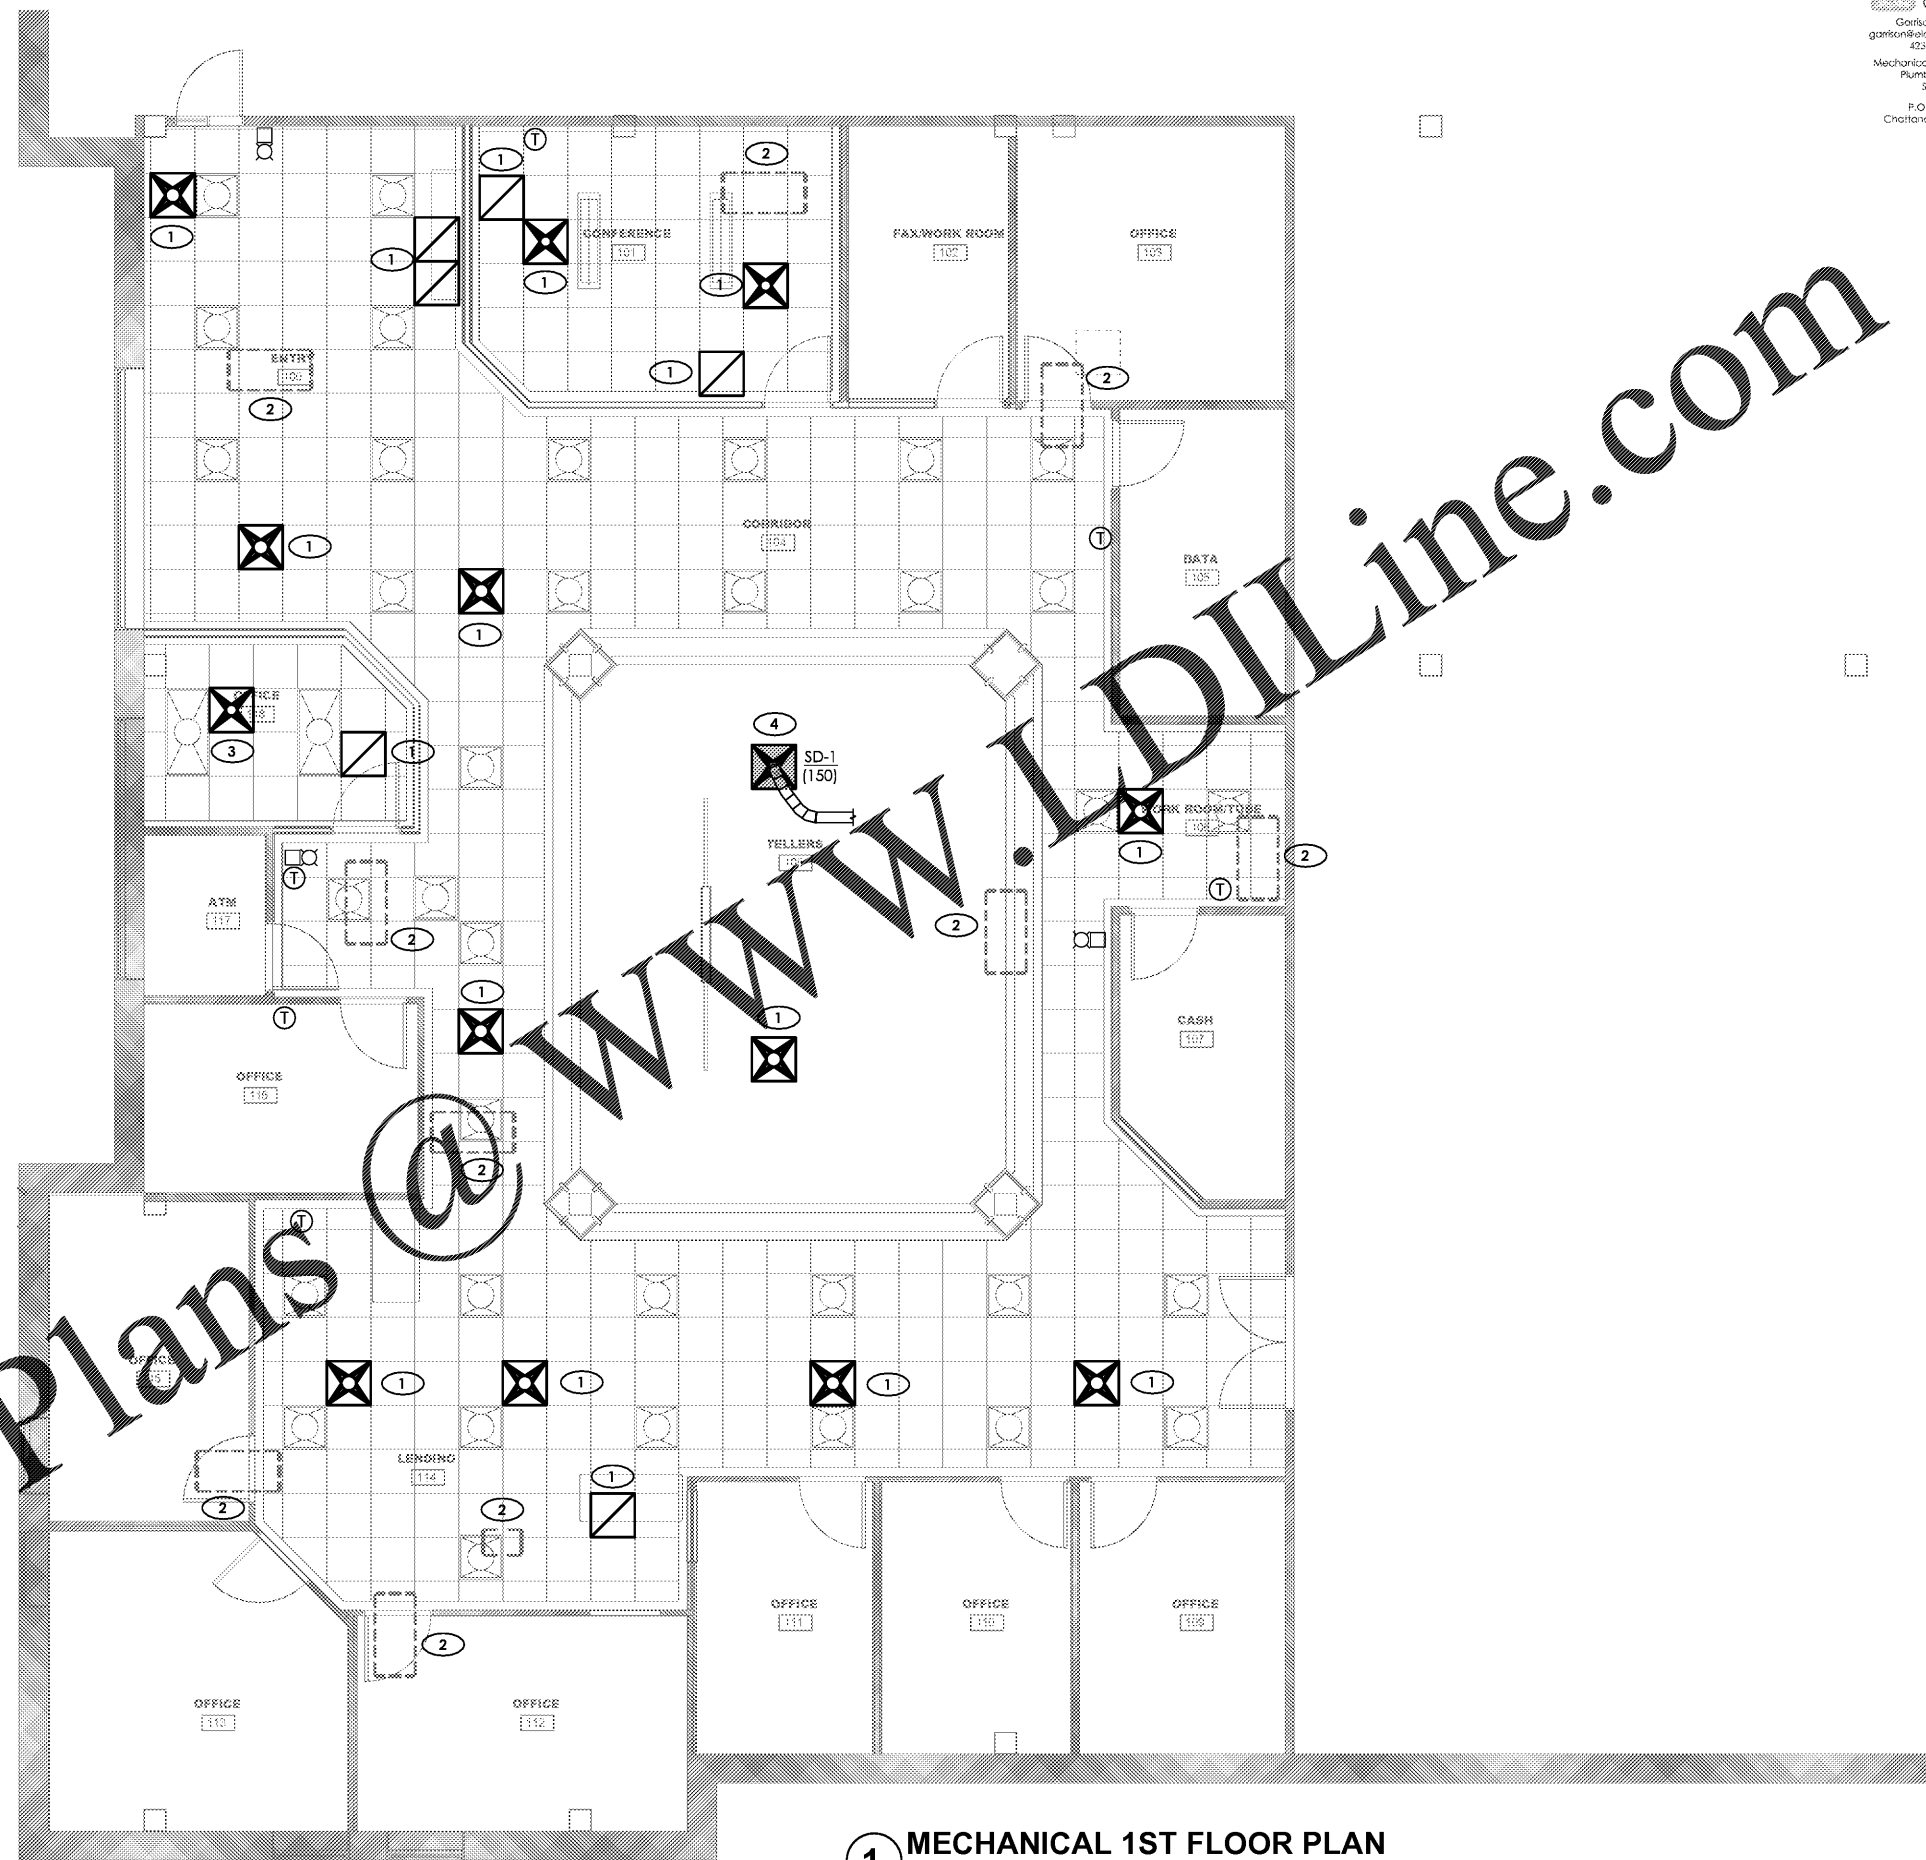

1 MECHANICAL 1ST FLOOR PLAN
 SCALE: 1/4" = 1'-0"

ROCK POINT BANK
 401 Chestnut Street Chattanooga, Tennessee



ISSUE DATES
 INITIAL ISSUE 05-27-20

JOB NO. 20-011 | DWN KP | CKD OGE
M1.0
 MECHANICAL 1ST FLOOR PLAN