


**LEGEND**

|  |                                 |
|--|---------------------------------|
| ⊕ ISA, 120V MOUNTED 1/2" AFFINIZED HOUSING | ⊕ ISA, 120V QUAD                |
| ⊕ ISA, GPO DUPLEX OUTLET                   | ⊕ TELEVISION OUTLET             |
| ⊕ ISA, 120V FLOOR FLOOR MOUNT              | ⊕ DATA OUTLET                   |
| ⊕ 20A, 120V, 240V RECEPTACLE               | ⊕ EXIT LIGHT                    |
| ⊕ 30A, 120V, 240V RECEPTACLE               | ⊕ BELLIGHT WITH EMERGENCY LIGHT |
| ⊕ LIGHT SWITCH                             | ⊕ EMERGENCY LIGHT               |
| ⊕ DISCONNECT                               | ⊕ J BOX                         |
| ⊕ MANUAL FIRE ALARM STATION                | ⊕ TAMPER SWITCH                 |
| ⊕ FIRE ALARM AUDIO VISUAL                  | ⊕ FLOW SWITCH                   |
| ⊕ SMOKE DETECTOR                           |                                 |
| ⊕ CARBON MONOXIDE DETECTOR                 |                                 |

**ELECTRICAL NOTES**

1. ALL WORK SHALL CONFORM TO THE NATIONAL ELECTRICAL CODE, TO NFPA 72, CURRENT EDITIONS, AND ALL STATE AND LOCAL CODES.
2. CONFIRM LOCATION OF ALL ELECTRICAL DEVICES WITH OWNER BEFORE INSTALLATION.
3. CONFIRM WITH OWNER WHICH LIGHTS TO BE DIMMED AND DIMMER AND SWITCH LOCATIONS.
4. REMOVE ALL UNUSED ELECTRICAL BACK TO THE PANEL.
5. REUSE EXISTING CIRCUITS.
6. HOMERUNS SHOWN ARE TO BE 30 AMP, 120 VOLT, #12 COPPER WITH #12 COPPER GND.
7. ALL OUTLETS WITHIN 6' OF SINK NEED TO BE GFCI.

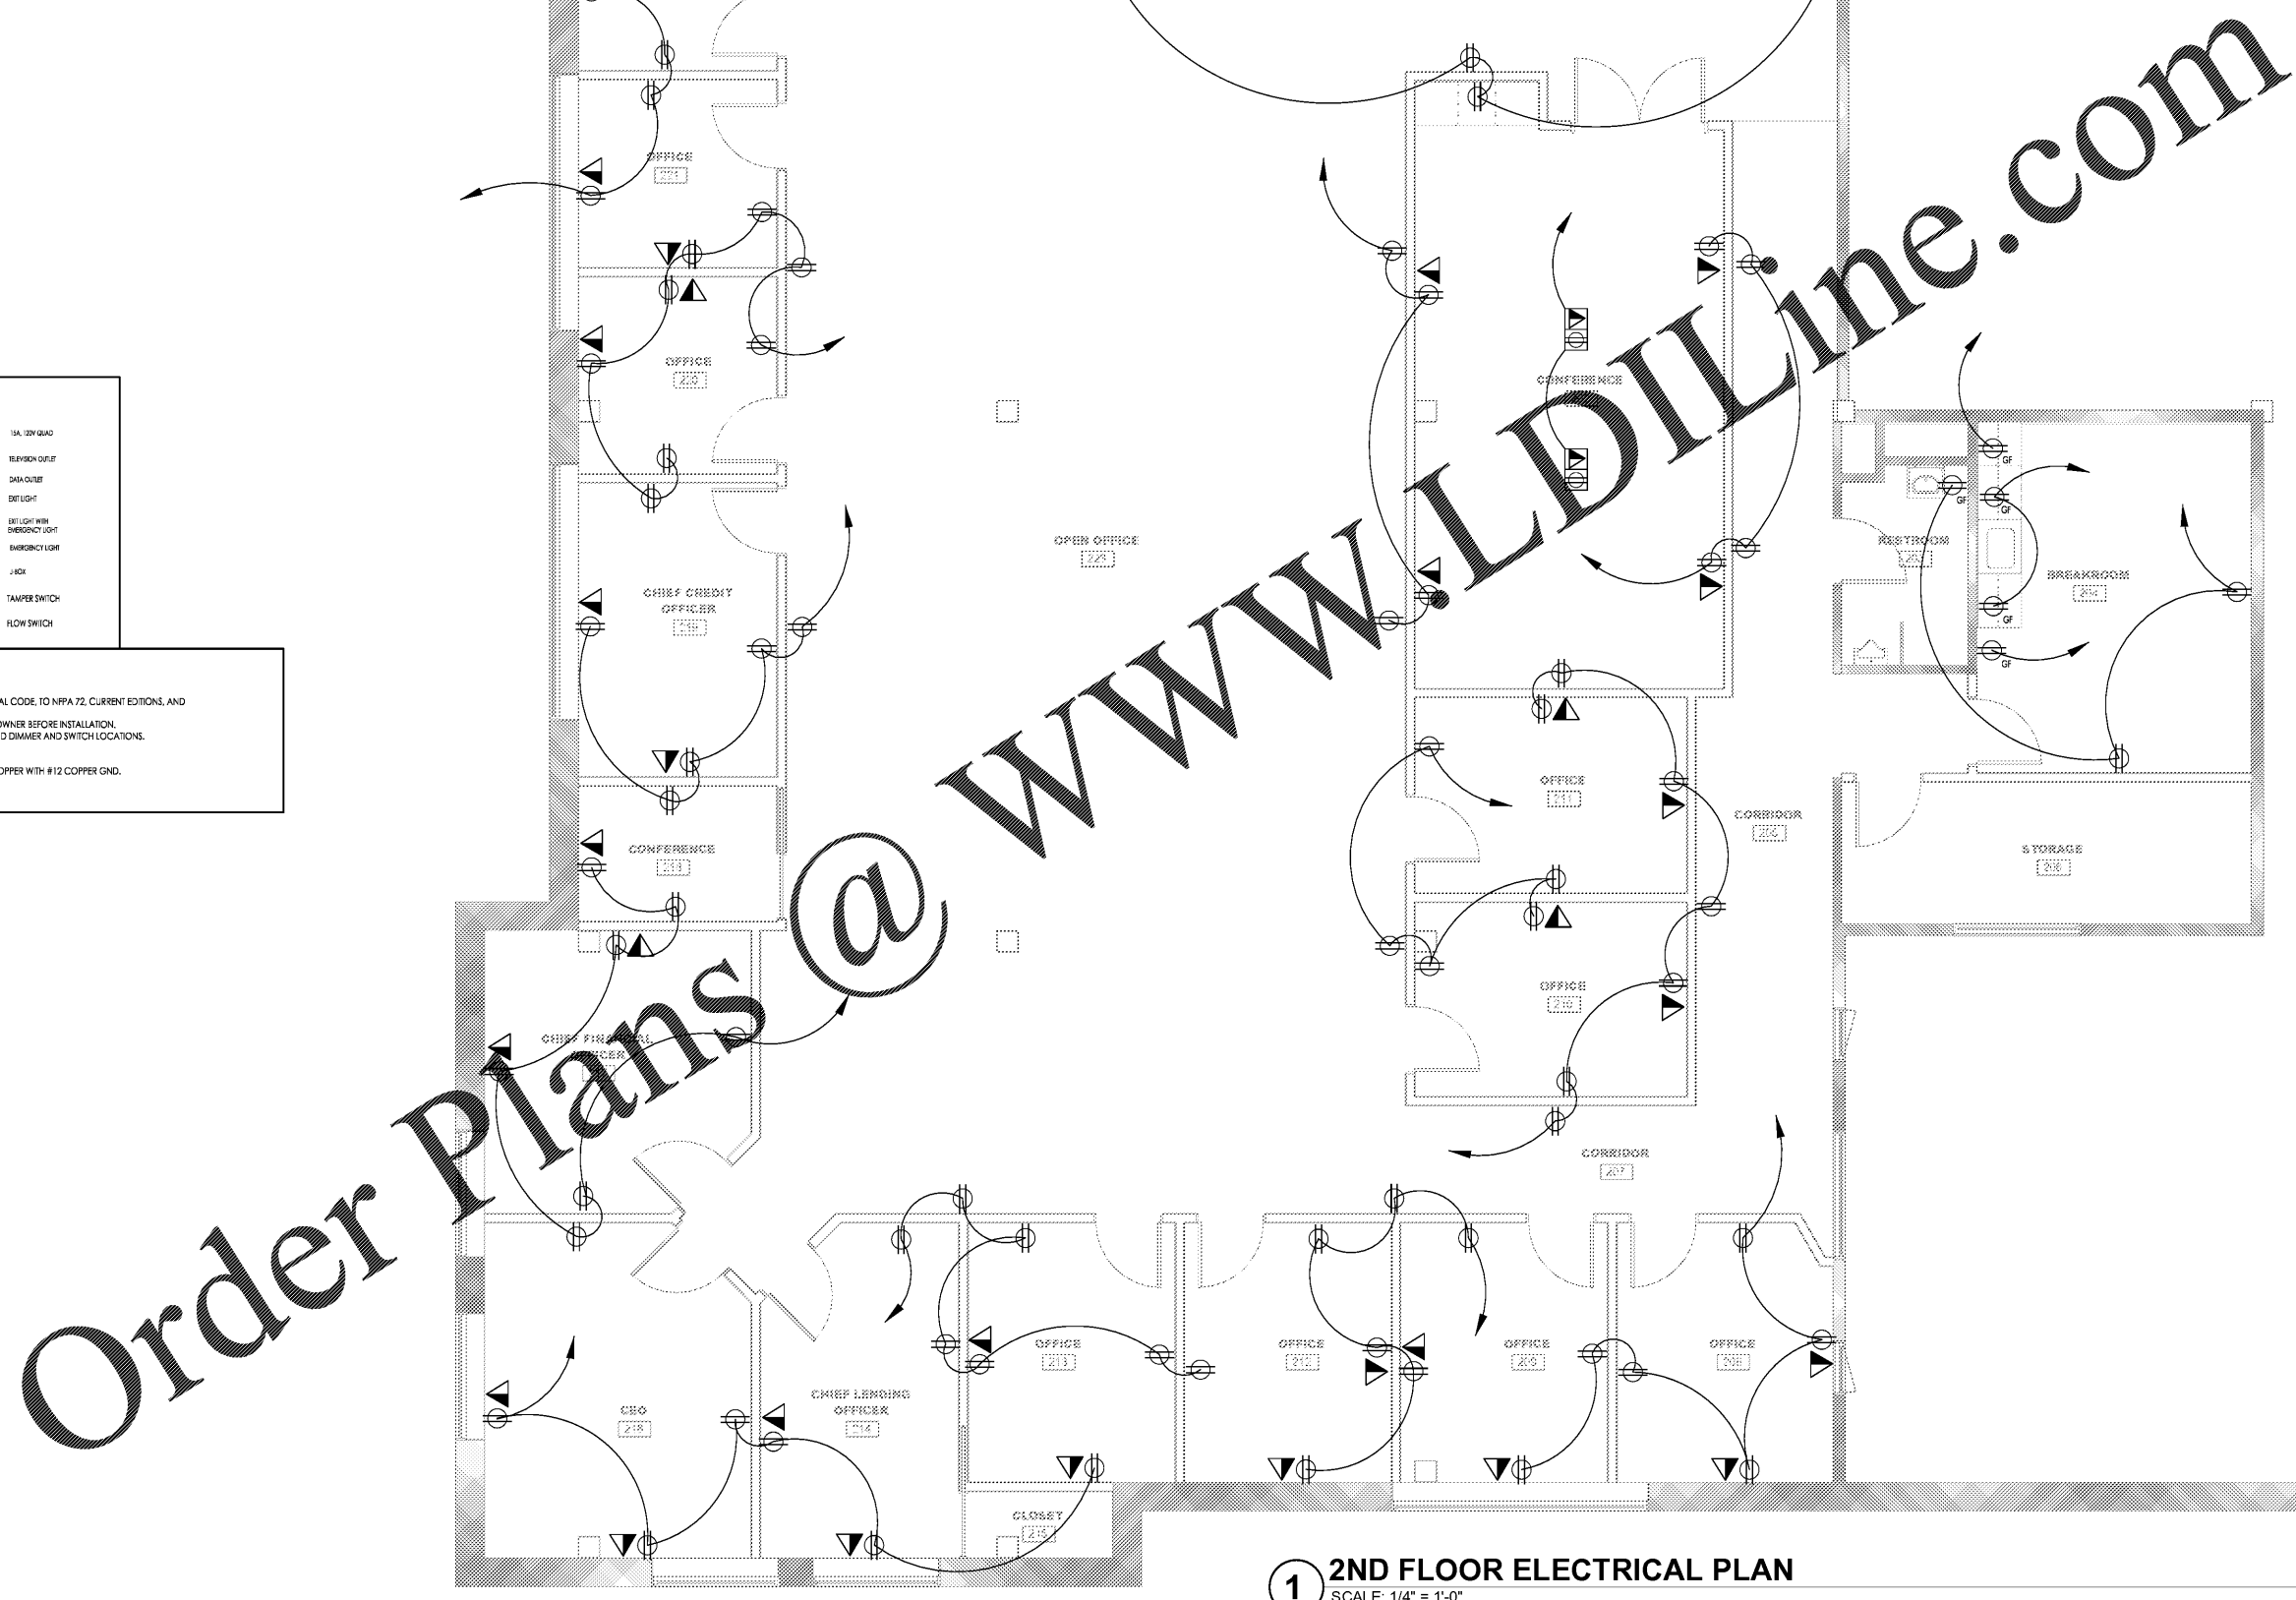

Order Plans @

**1 2ND FLOOR ELECTRICAL PLAN**  
 SCALE: 1/4" = 1'-0"



ISSUE DATES  
 INITIAL ISSUE 05-27-20

JOB NO. | DWN | CK'D  
 20-011 | RJC | RJC

**E3.0**  
 2ND FLOOR  
 ELECTRICAL PLAN