


Keynote Legend	
Key Value	Keynote Text
6	AIR HANDLING UNIT. SEE MECHANICAL DRAWINGS.
7	CONCRETE PAD. SEE CIVIL AND MECHANICAL DRAWINGS.
8	CHAIN LINK FENCE. SEE CIVIL DRAWINGS.
16	NEW EXTERIOR SUPPLY AIR DUCTWORK AND SUPPORT AS SHOWN ON DETAILS 9, 10 AND 11 ON MECHANICAL DRAWINGS M-401.

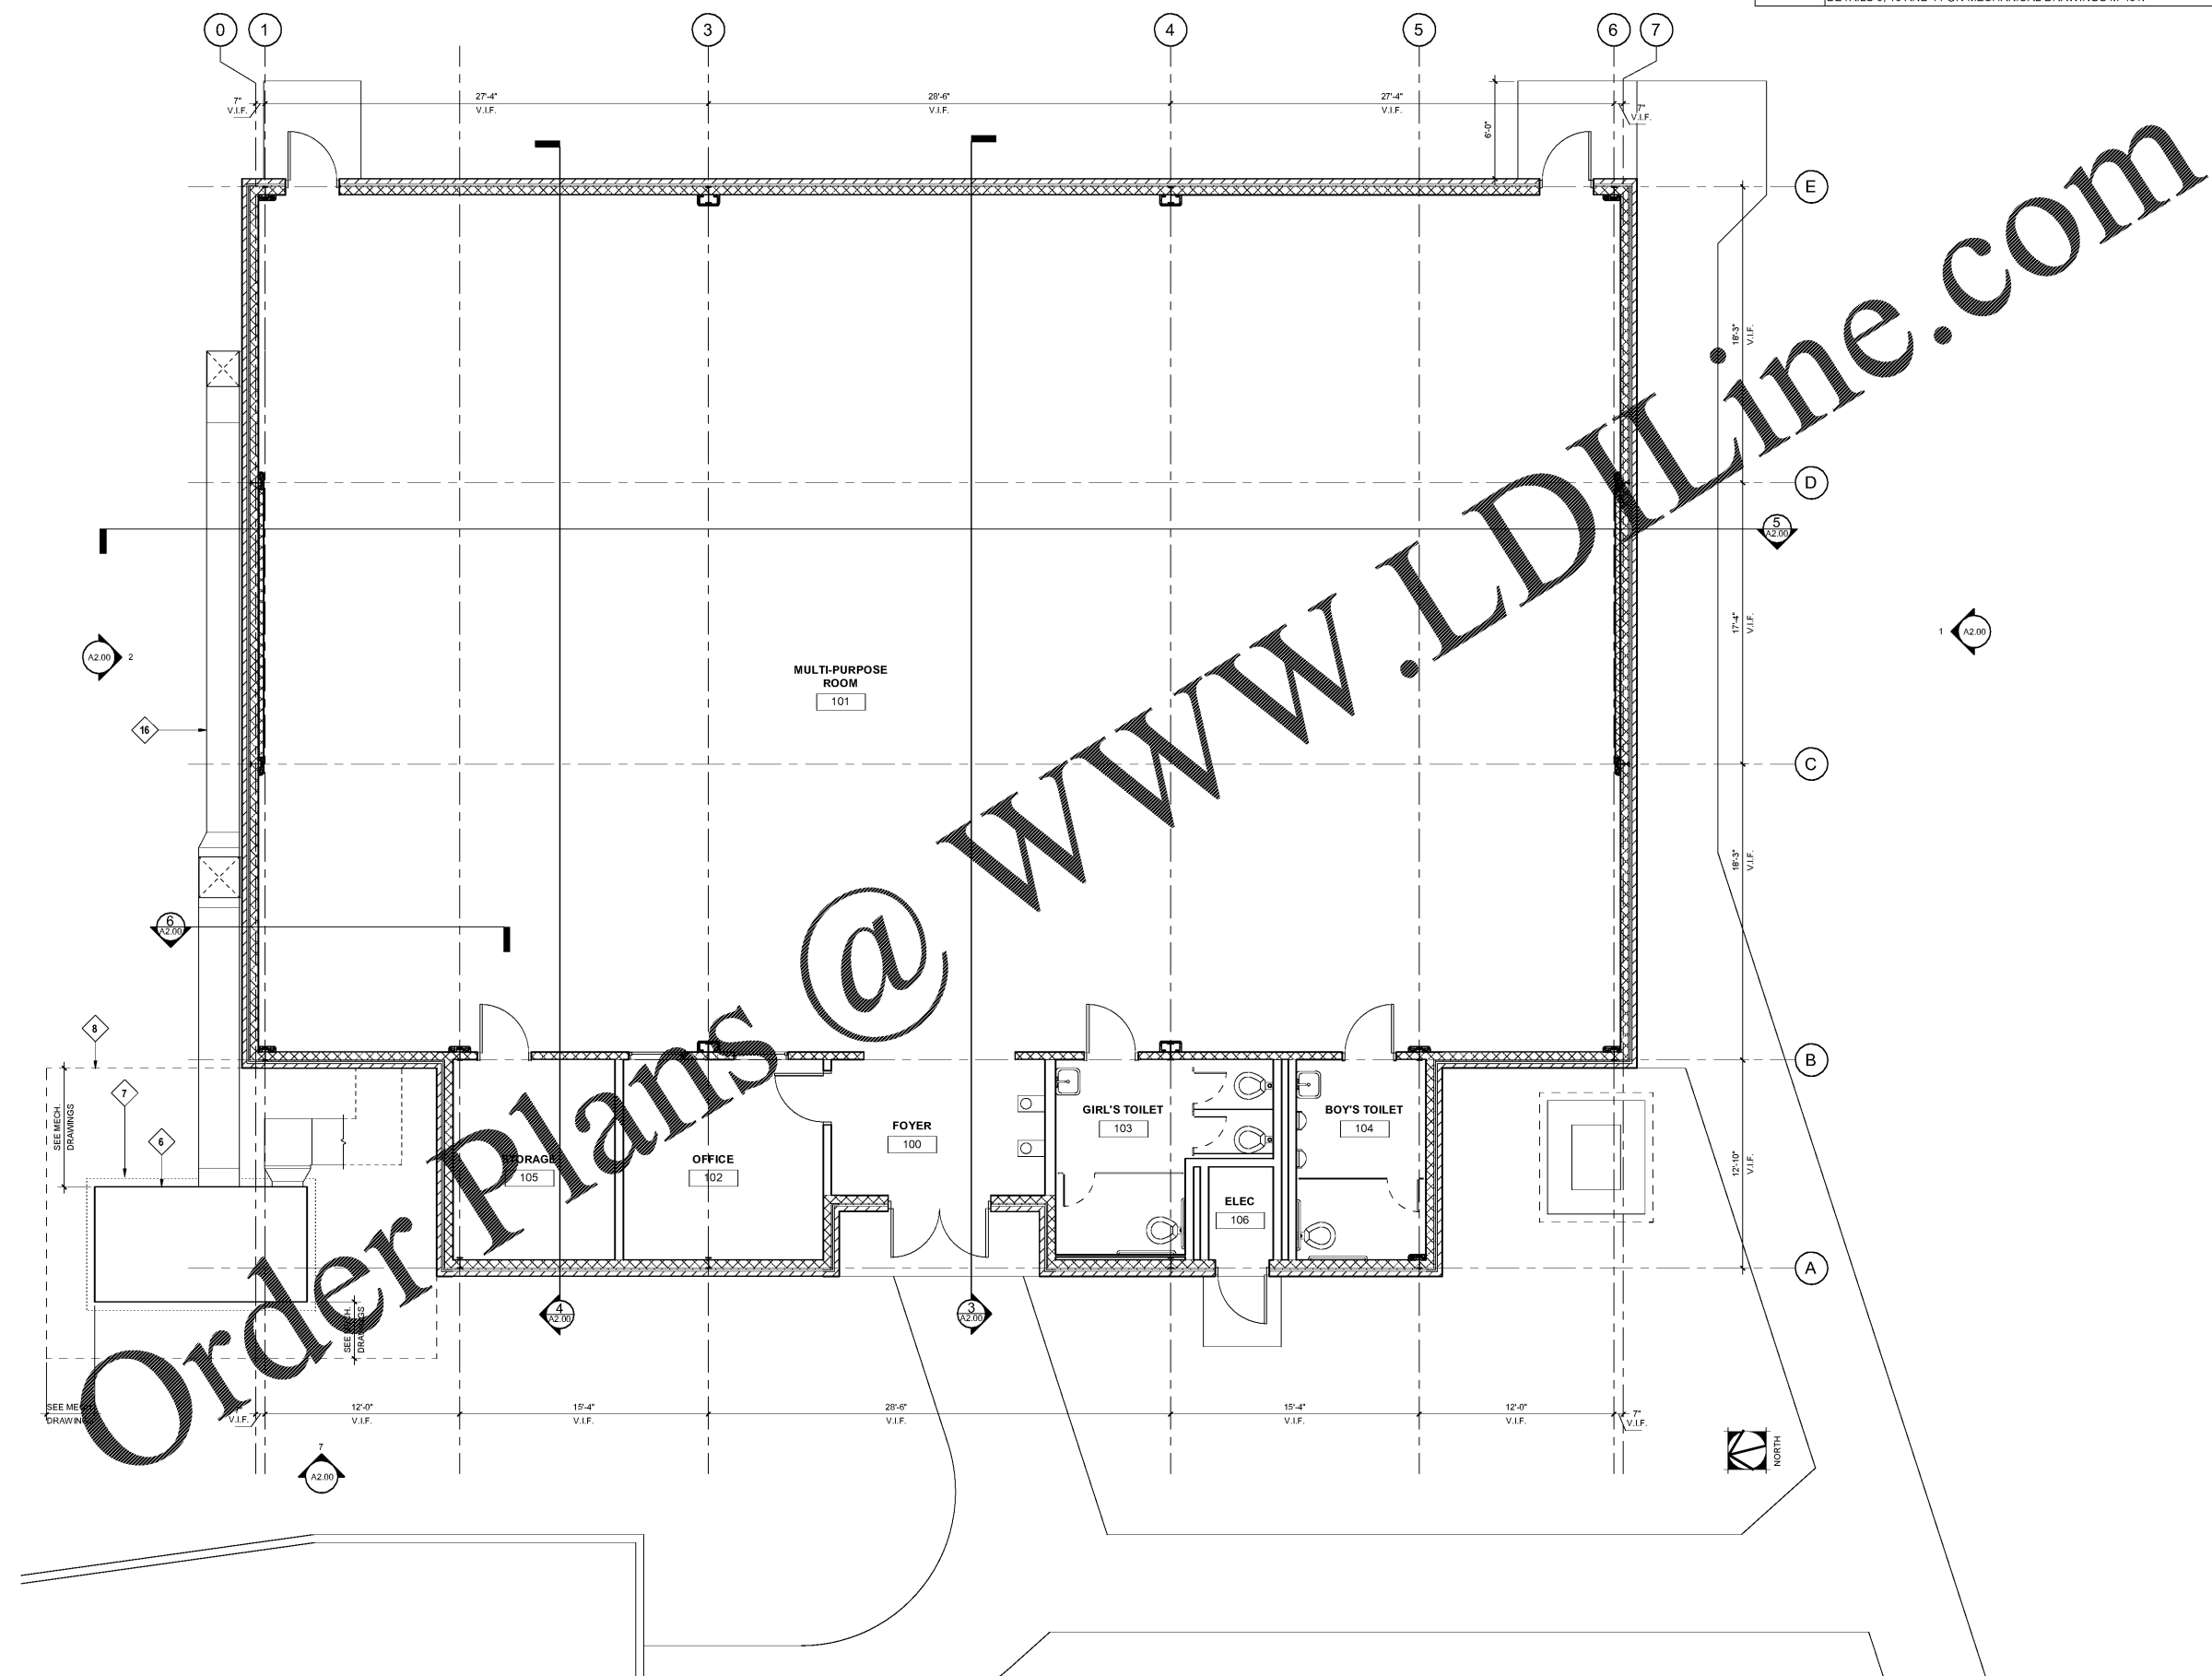

Order Plans @ www.LDILine.com

**BROCKETT ELEMENTARY SCHOOL  
GYM HVAC DESIGN**  
1855 Brockett Road  
Tucker, Georgia 30084

**STANLEY  
LOVE  
STANLEY  
P A C**

ARCHITECTURE  
INTERIORS PLANNING  
PROGRAM MANAGEMENT

1886 SPRING STREET, N.W.  
ATLANTA, GEORGIA 30388  
404-875-0208  
www.stanleylove.com

DRAWING TITLE  
**FLOOR PLAN**



SCALES AS STATED HEREON ARE VALID ON THE ORIGINAL DRAWING. THE DIMENSIONS OF WHICH ARE SHOWN ON THE SCALY. NOTED HEREON ARE HEREBY CHANGE BY THE PART OF THE OVERALL SHEET DIMENSIONS OF THE PRINT TO CORRESPONDING DIMENSIONS OF THE ORIGINAL DRAWING.

THE DRAWING IS THE PROPERTY OF STANLEY, LOVE & STANLEY P.C. AND IS NOT TO BE REPRODUCED OR COPIED IN WHOLE OR IN PART. IT IS TO BE USED ONLY FOR THE PROJECT AND SITE SPECIFICALLY IDENTIFIED HEREON AND IS NOT TO BE USED ON ANY OTHER PROJECT. IT IS TO BE RETURNED UPON REQUEST.

COPYRIGHT © 2018. ALL RIGHTS RESERVED.  
STANLEY, LOVE & STANLEY P.C.  
DRAWING NO.

DATE  
01/06/2020  
PROJECT NO.  
6919.9  
DRAWING NO.

**A1.00**

1/24/2020 3:56:44 PM

FLOOR PLAN  
1/4" = 1'-0"

RELEASED FOR CONSTRUCTION 01/06/2020